

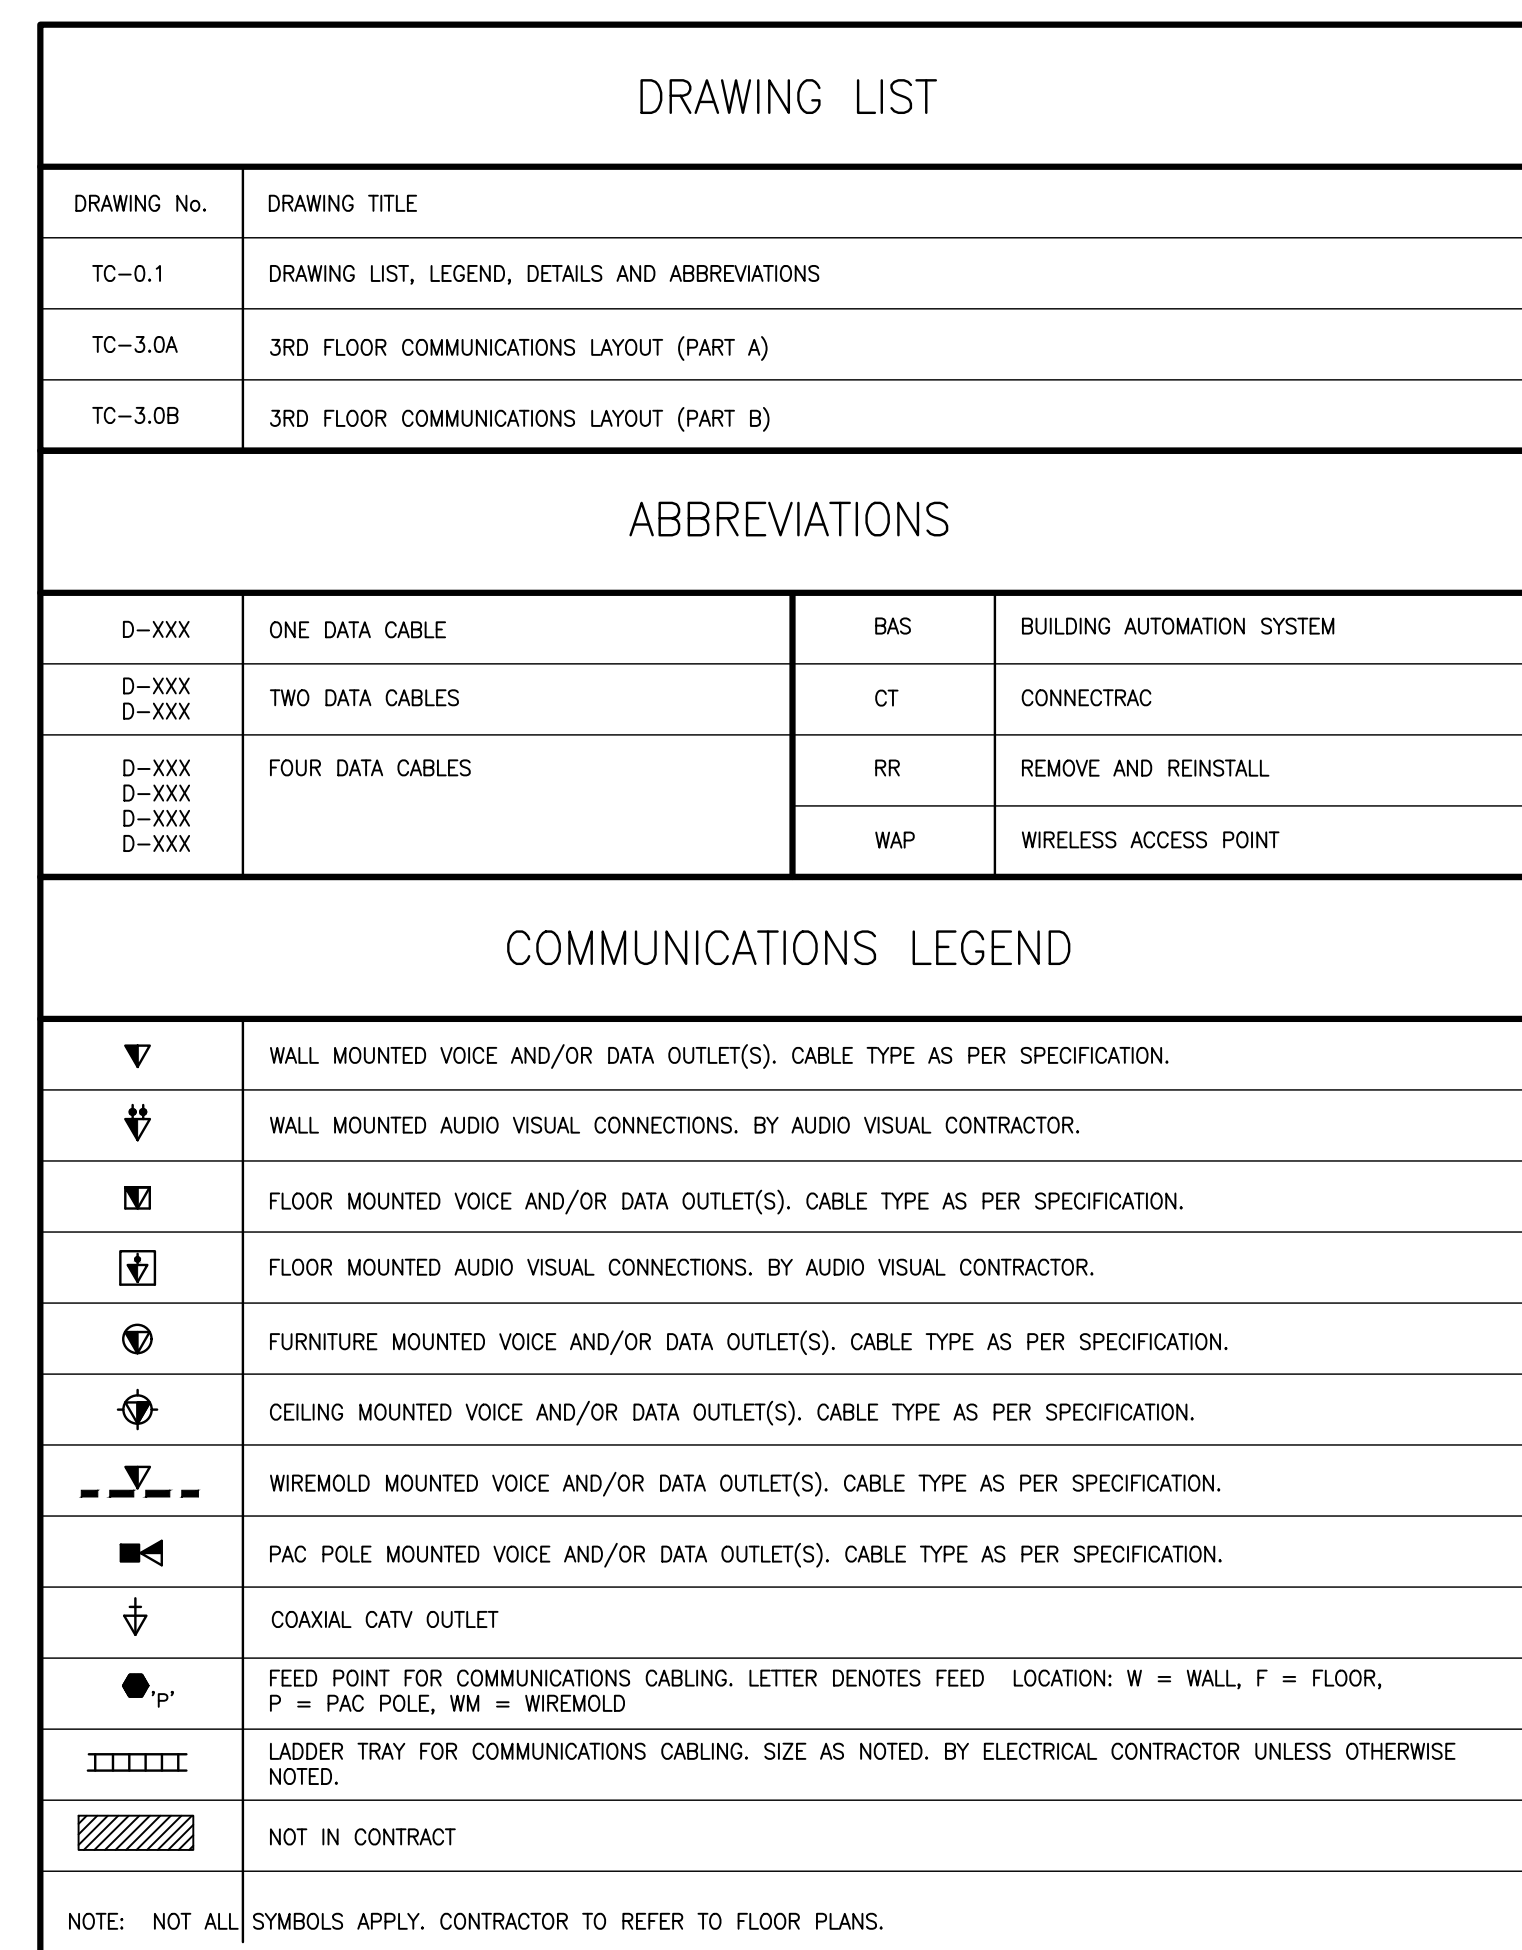
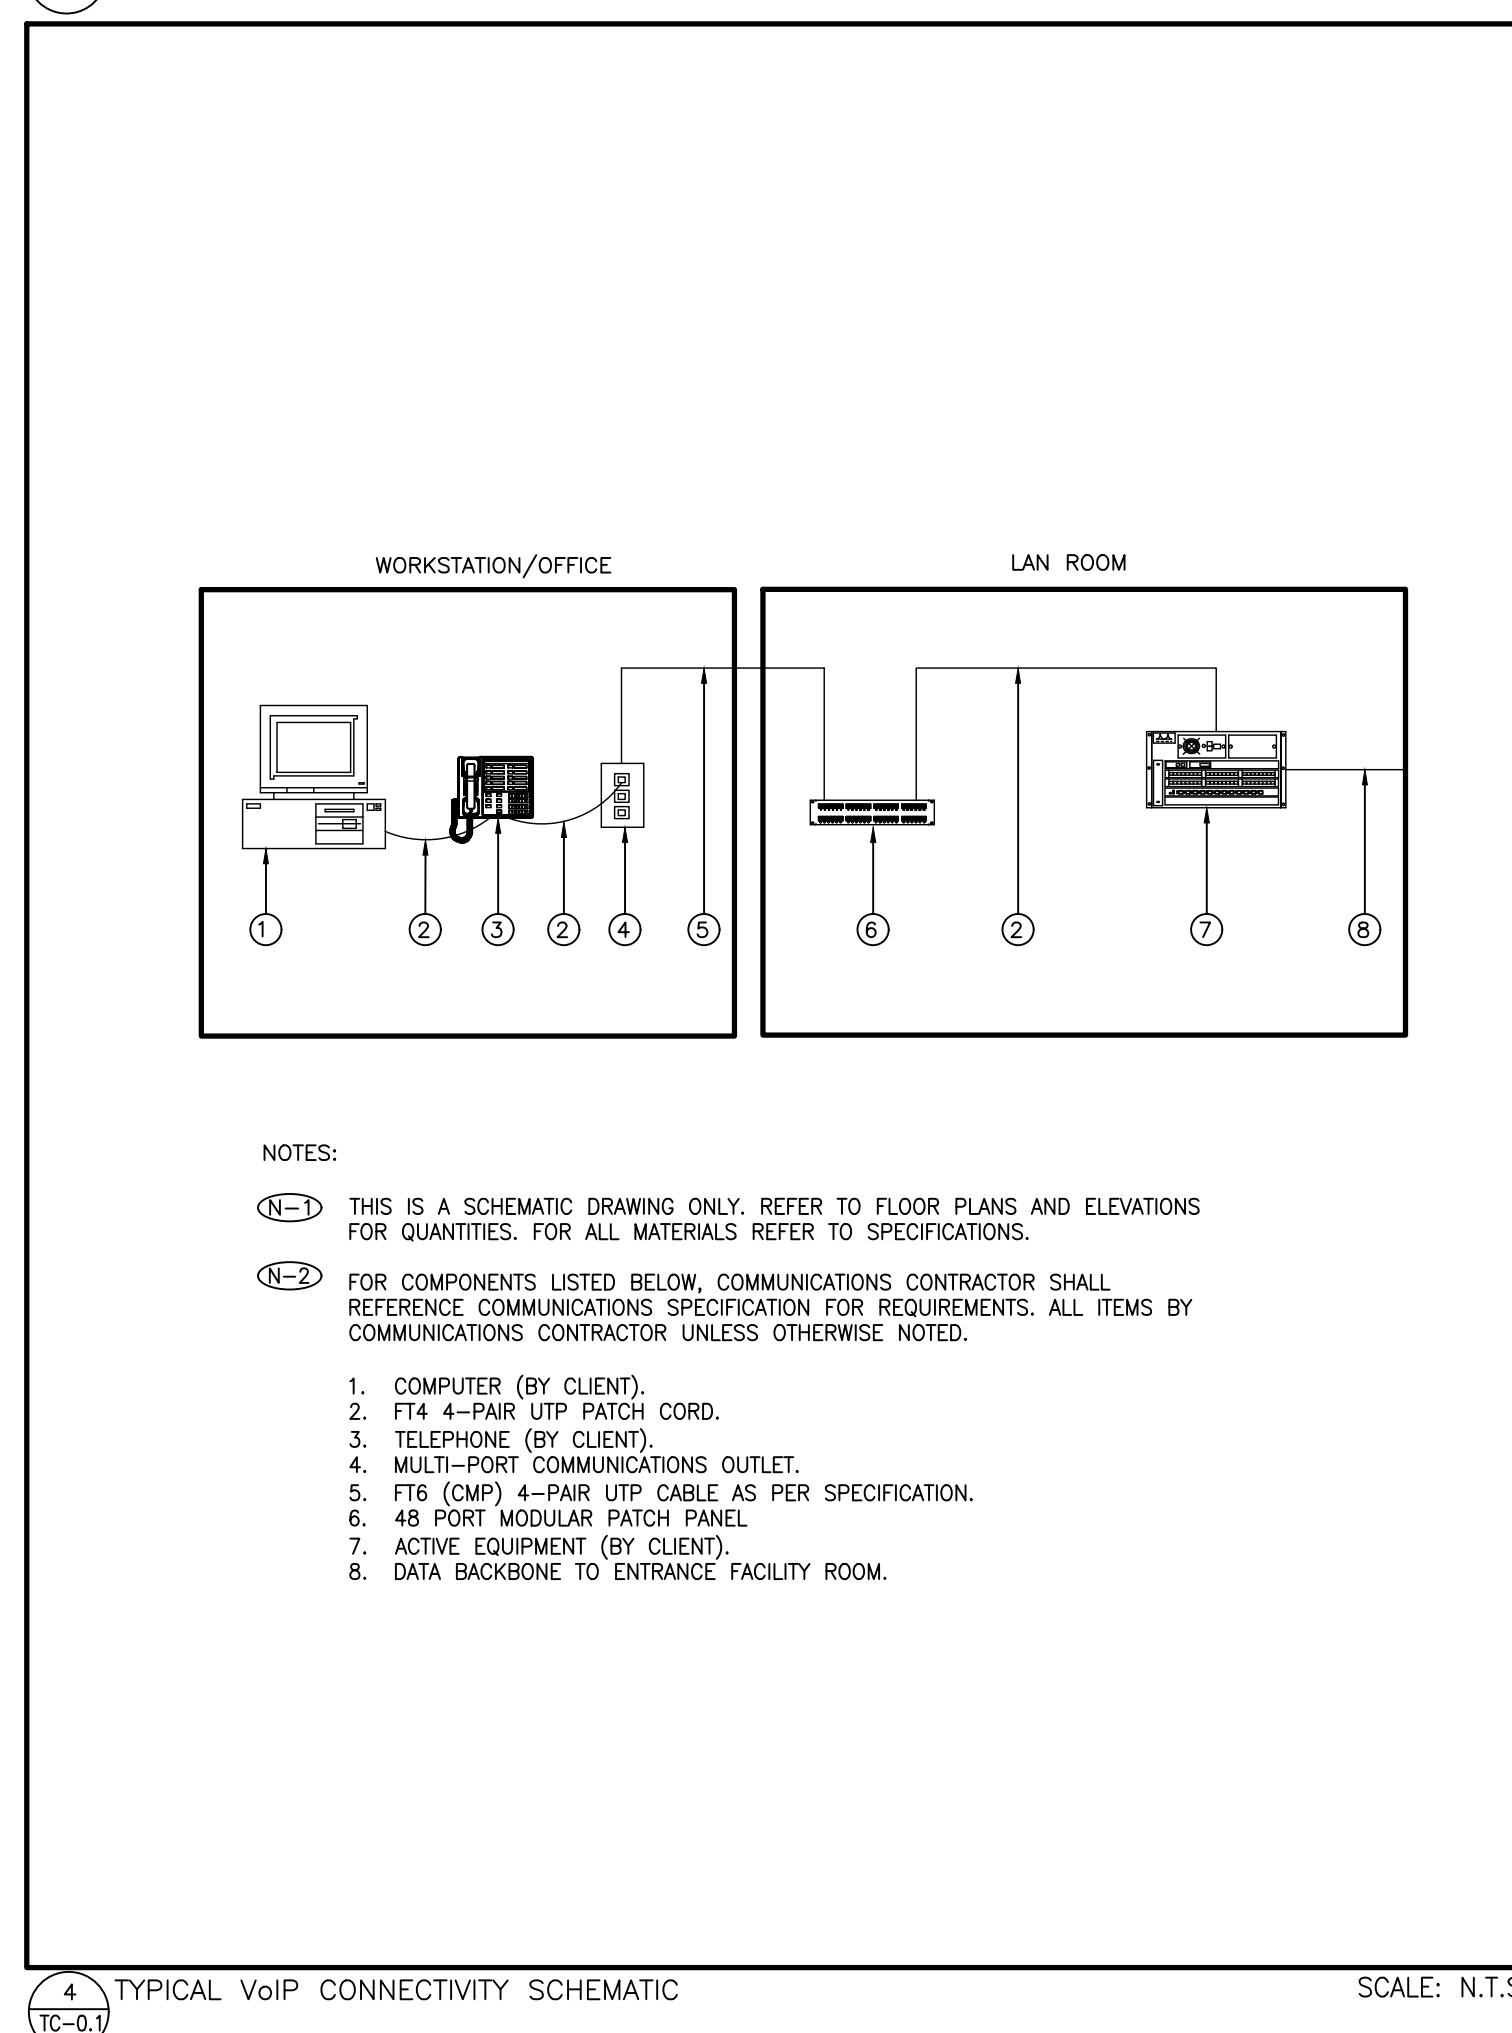
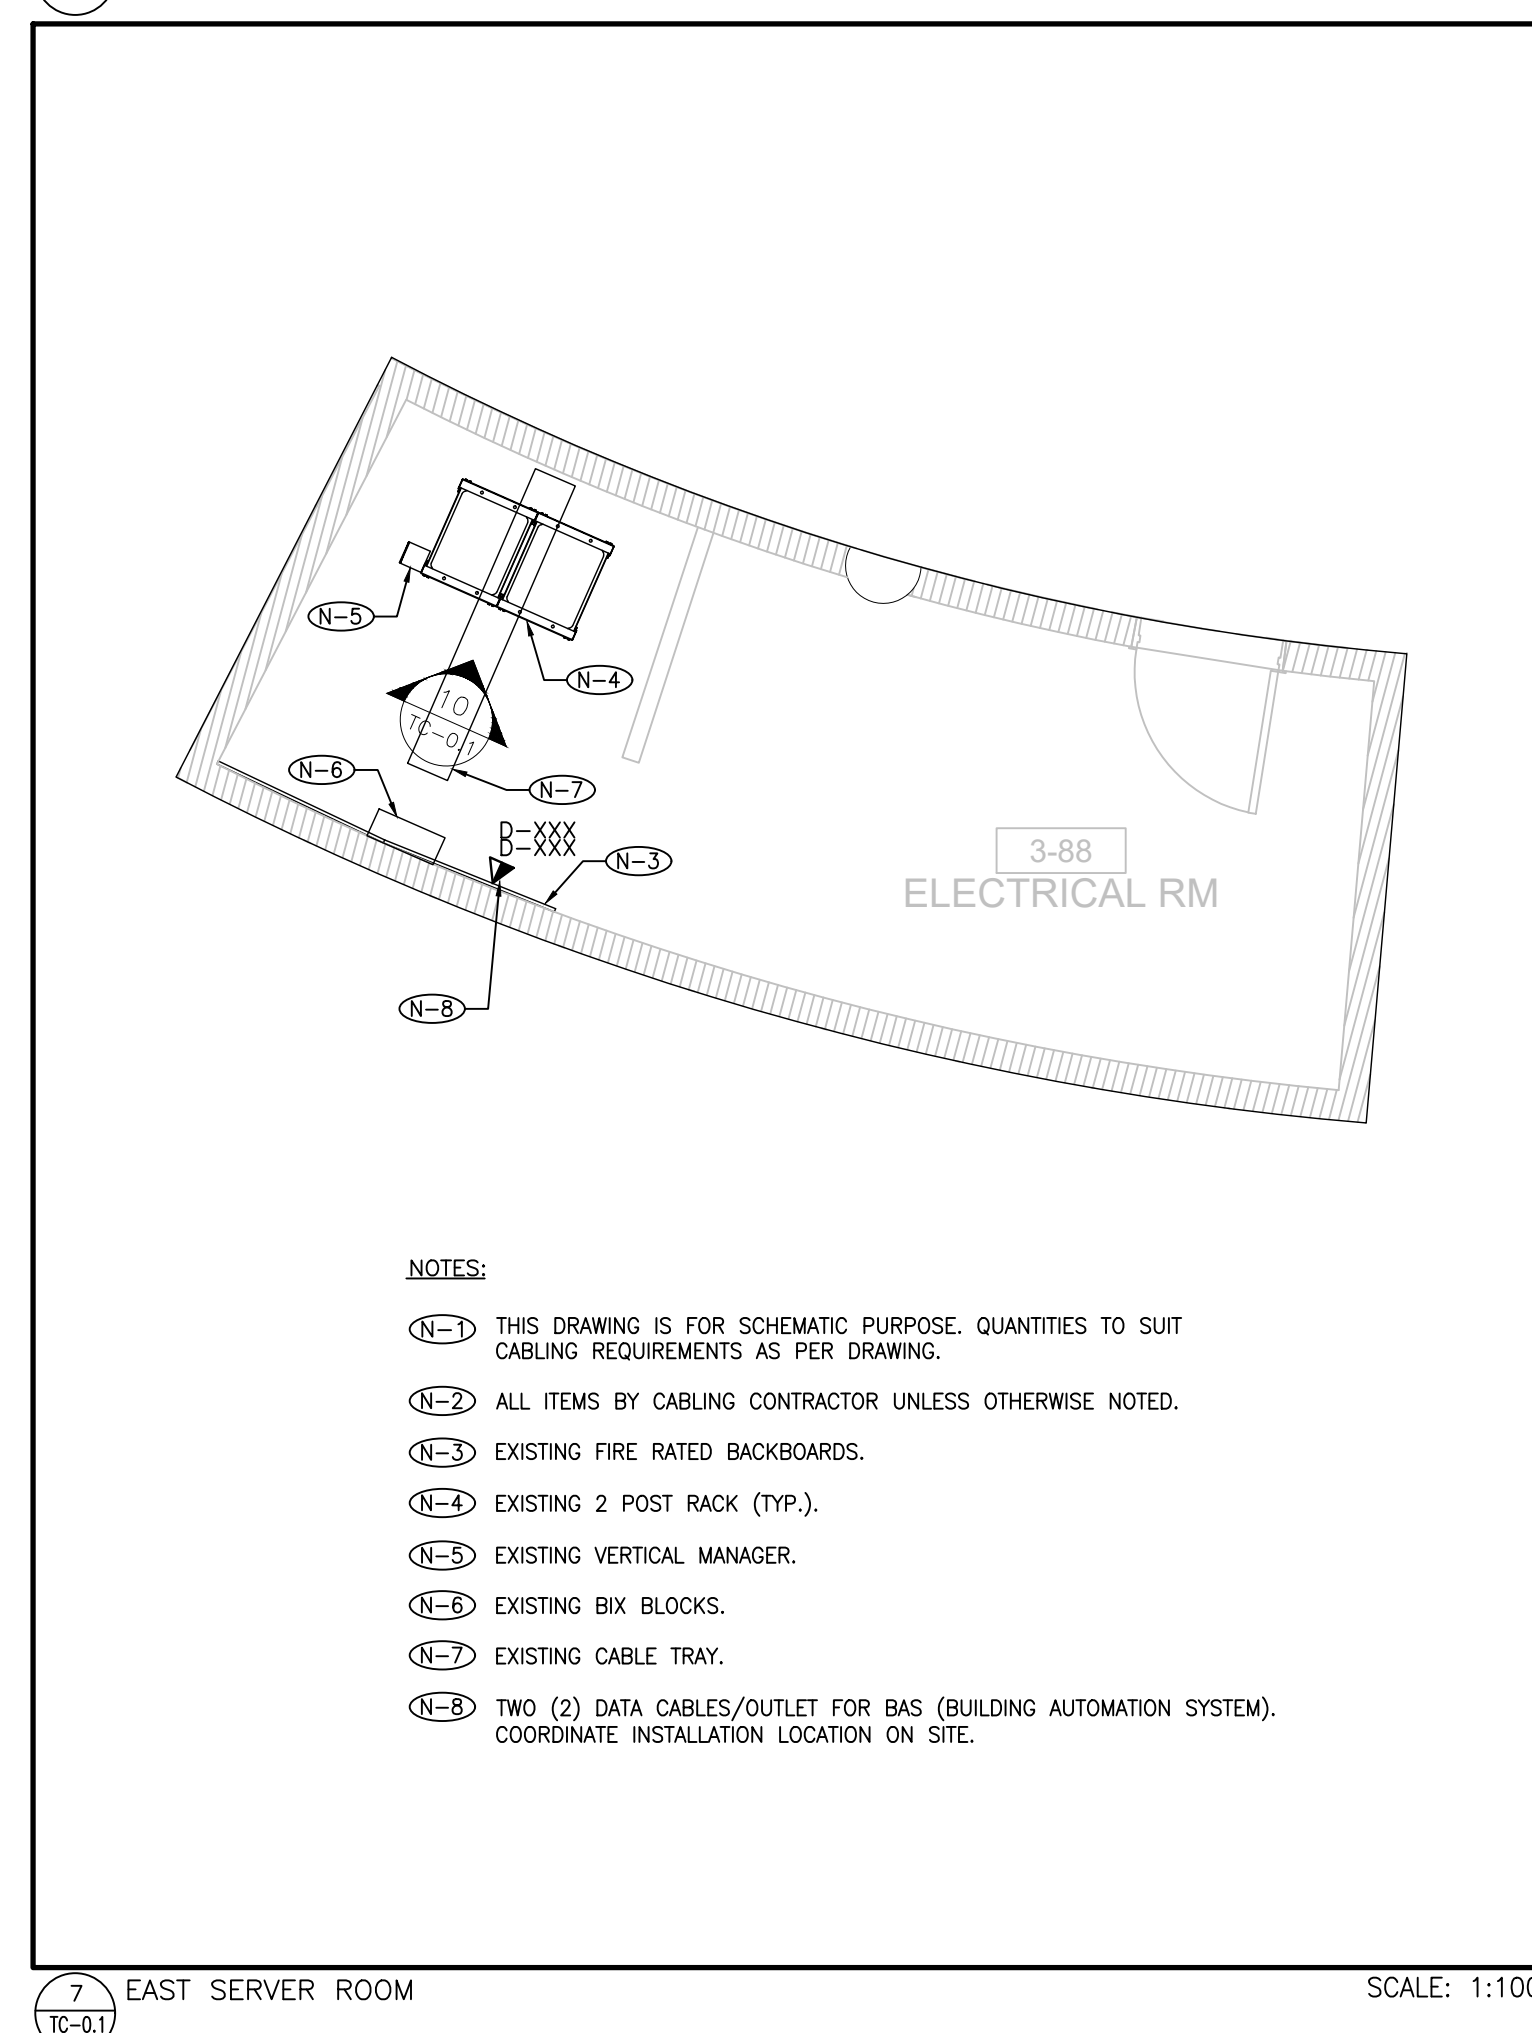
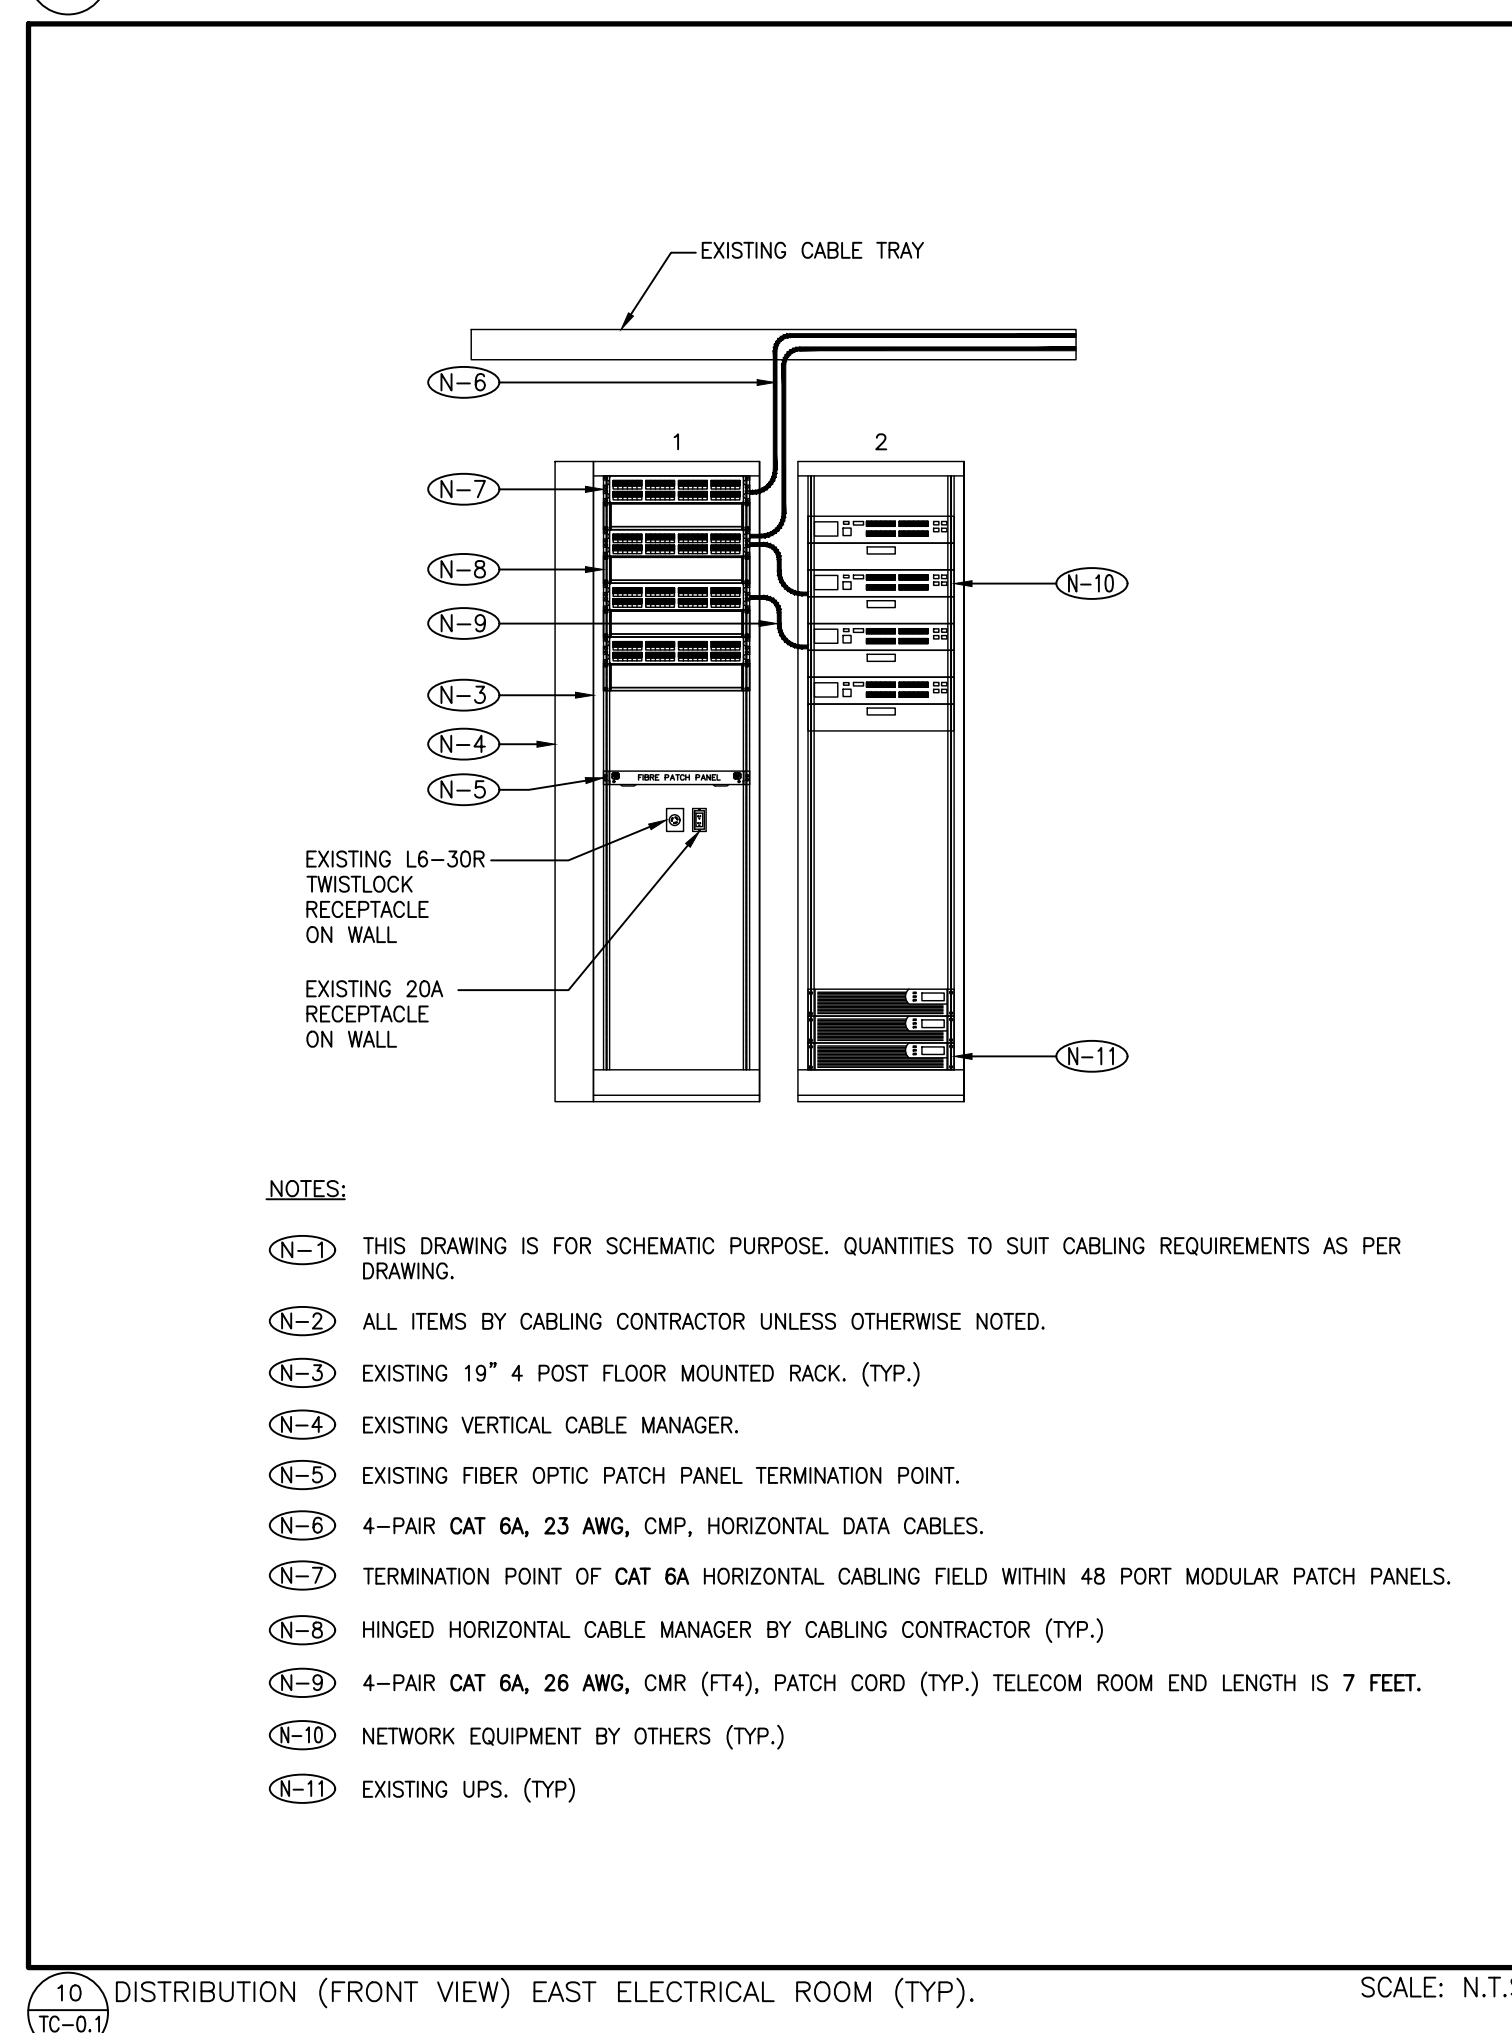
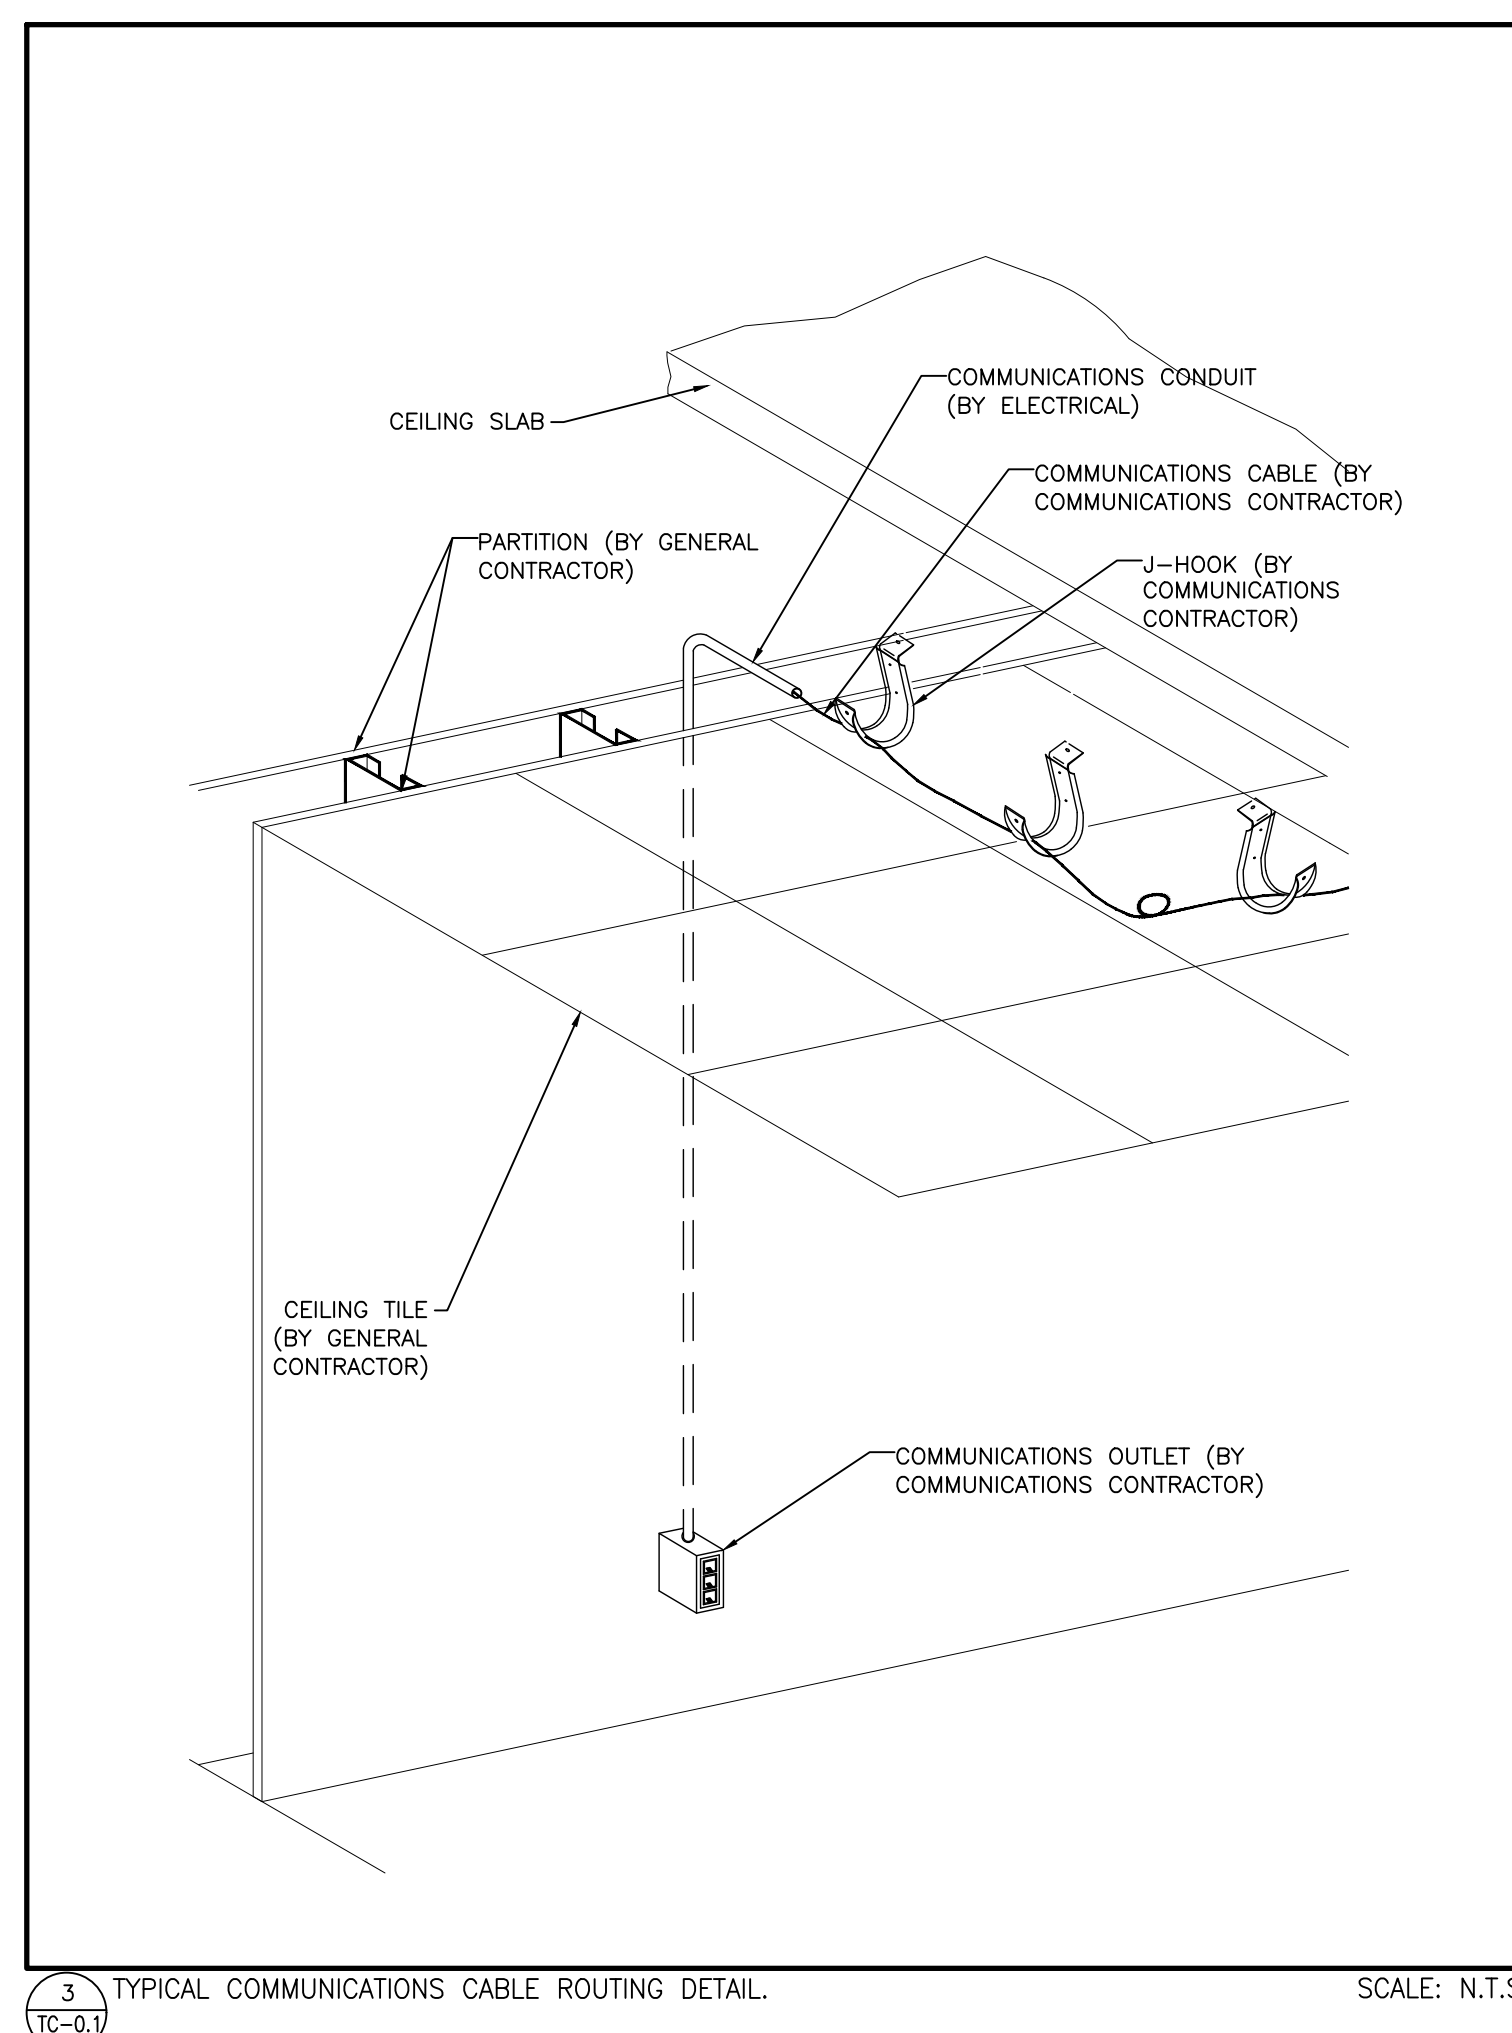
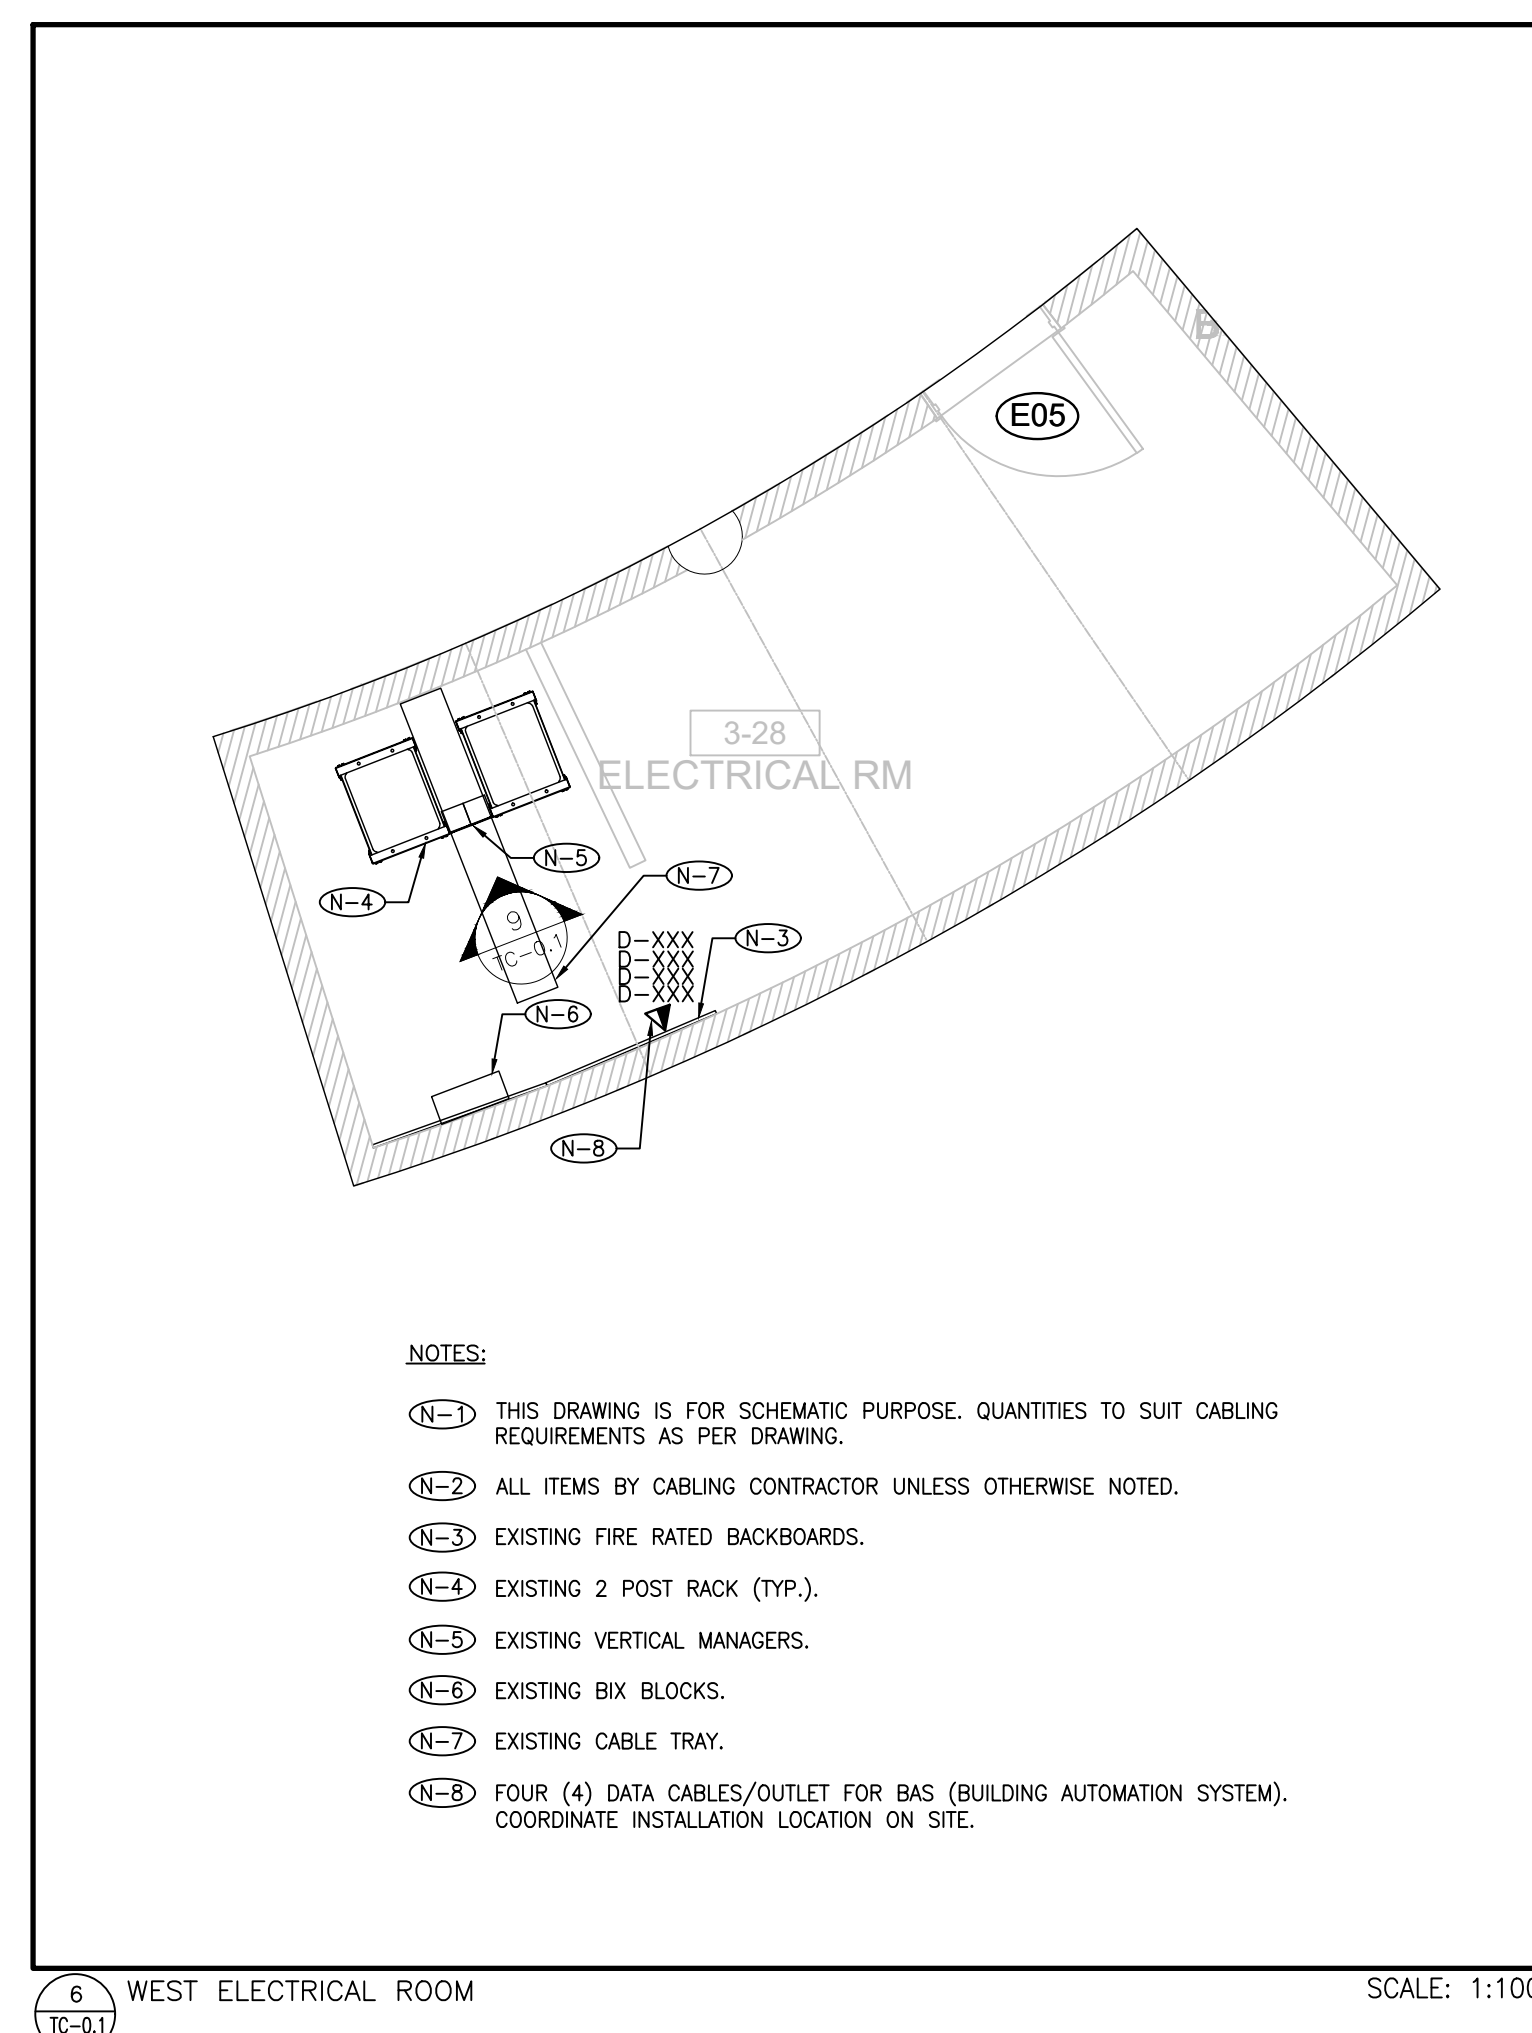
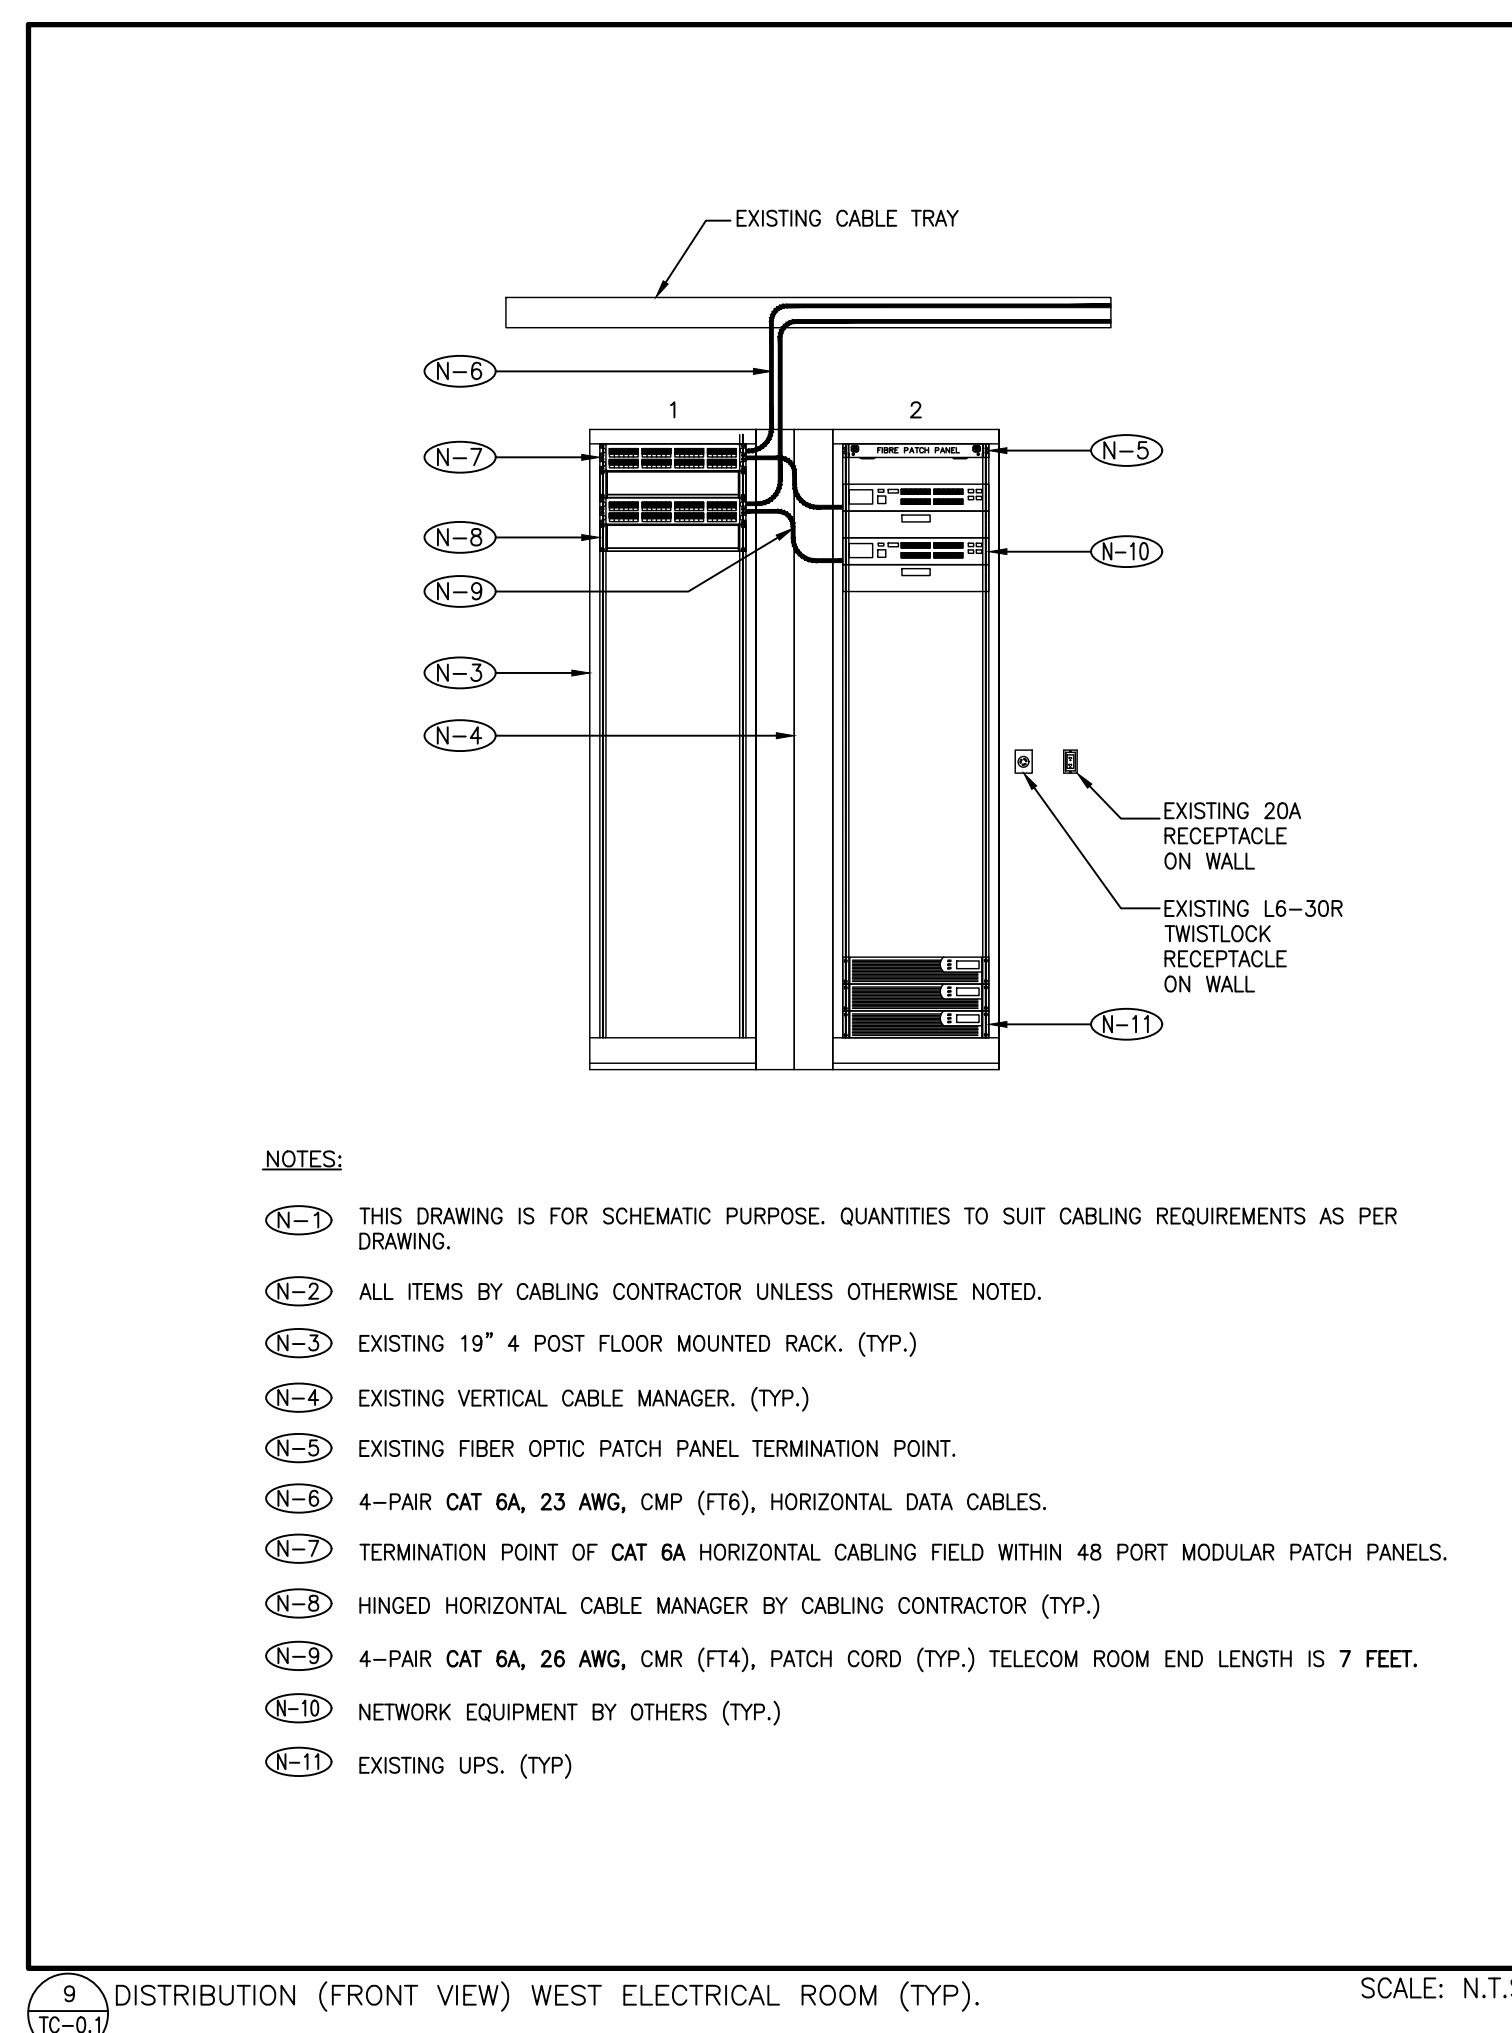
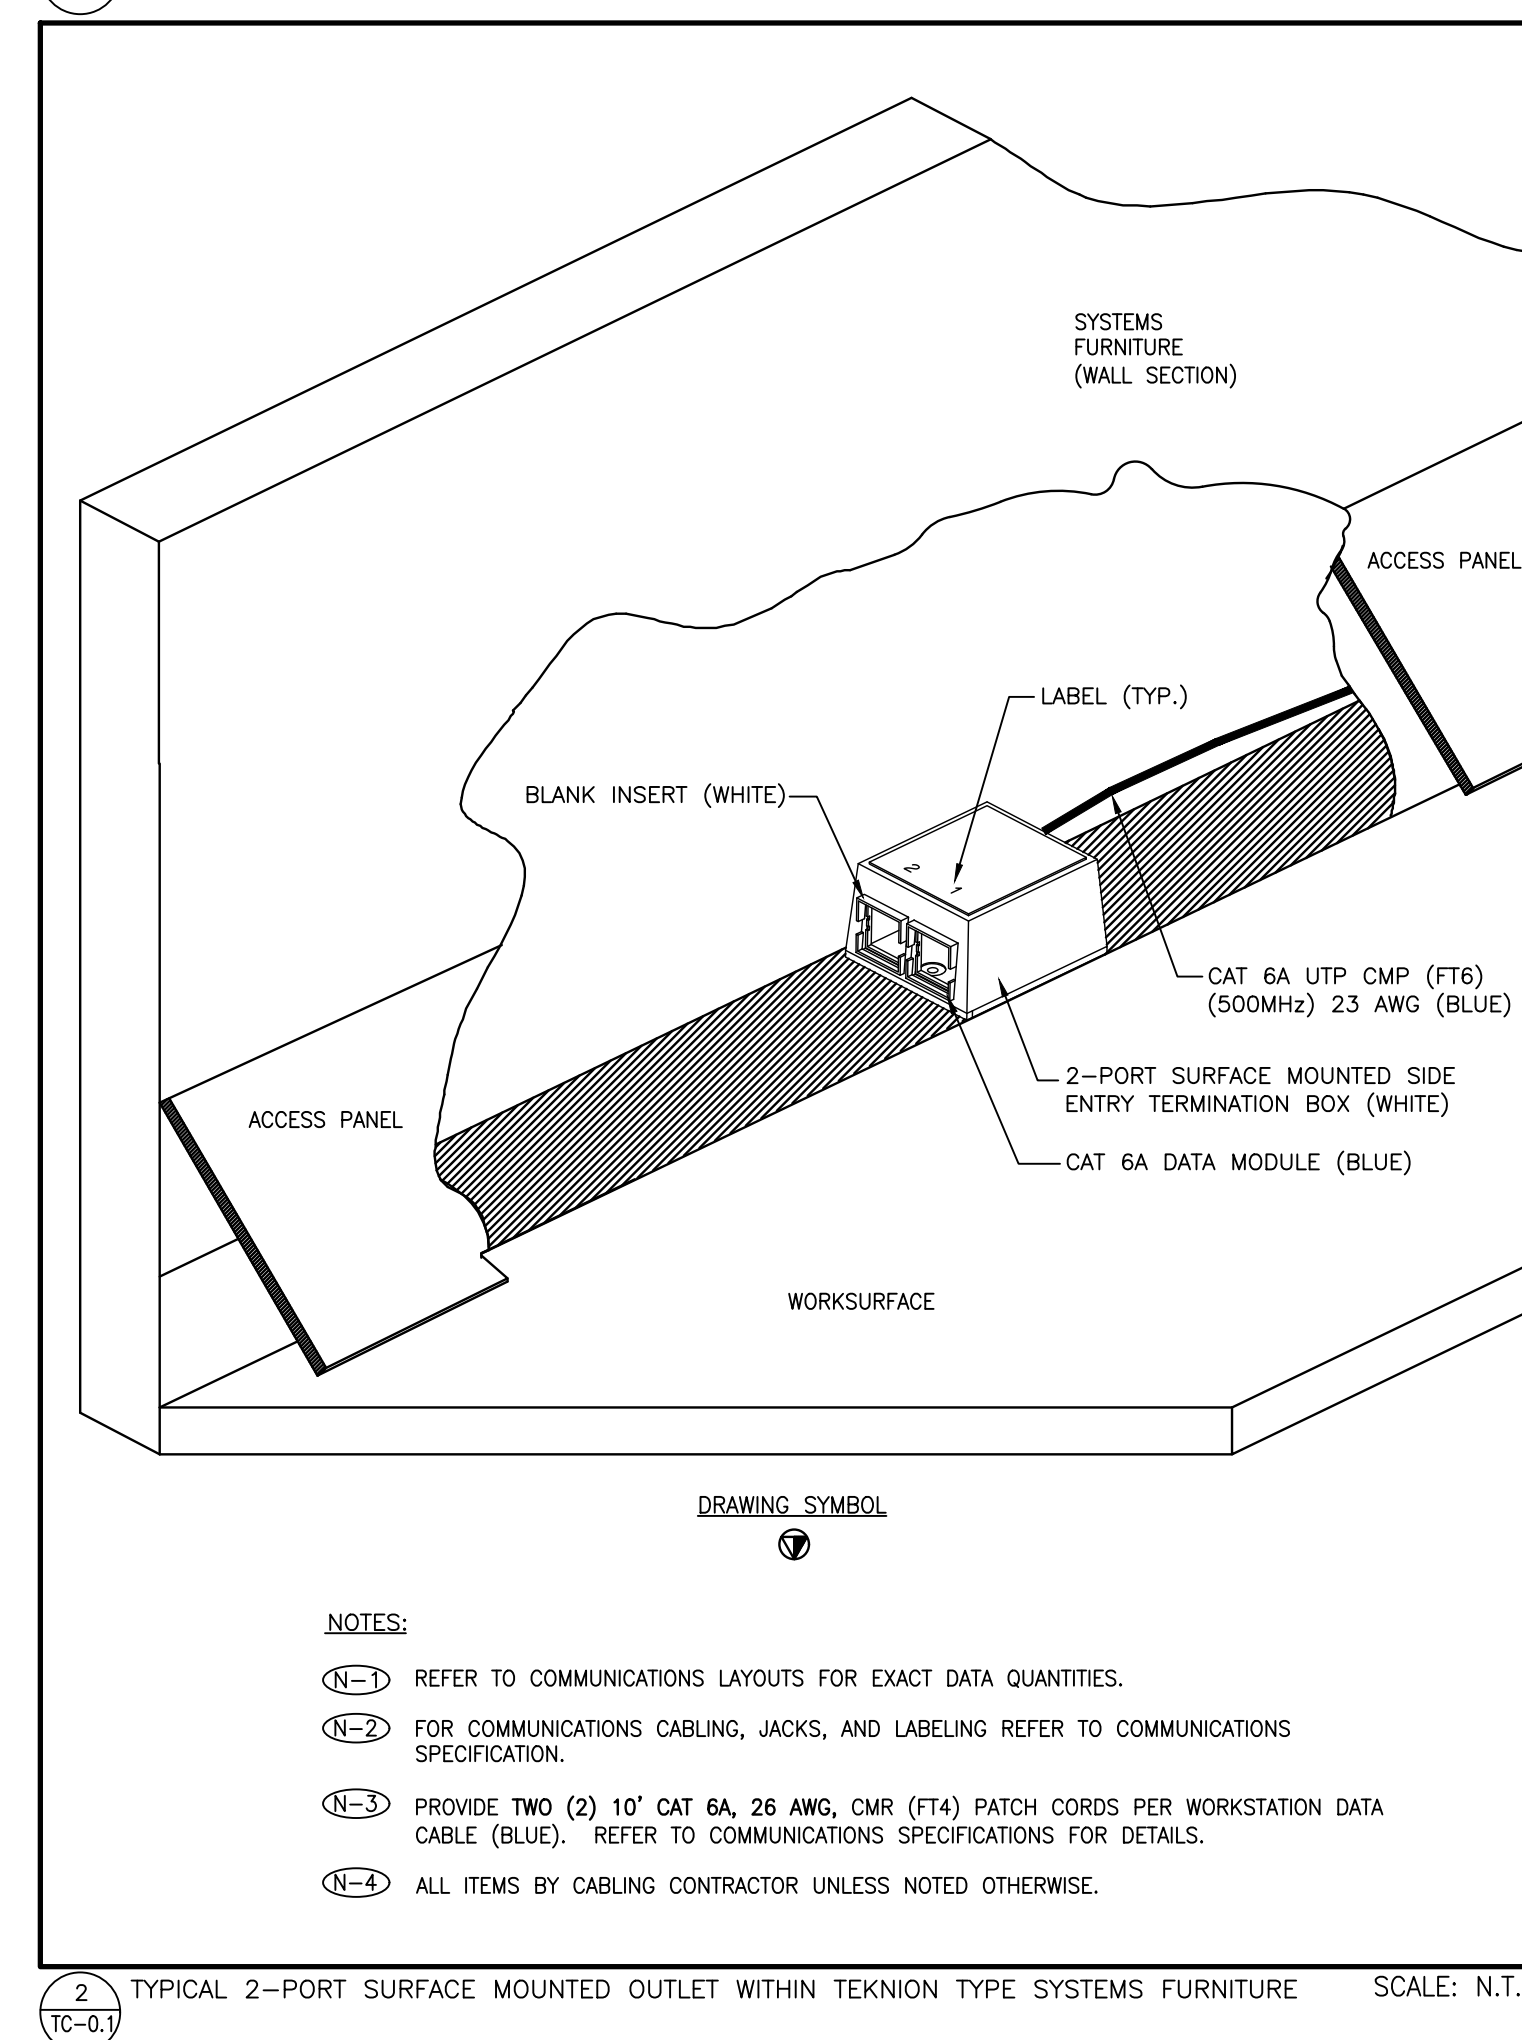
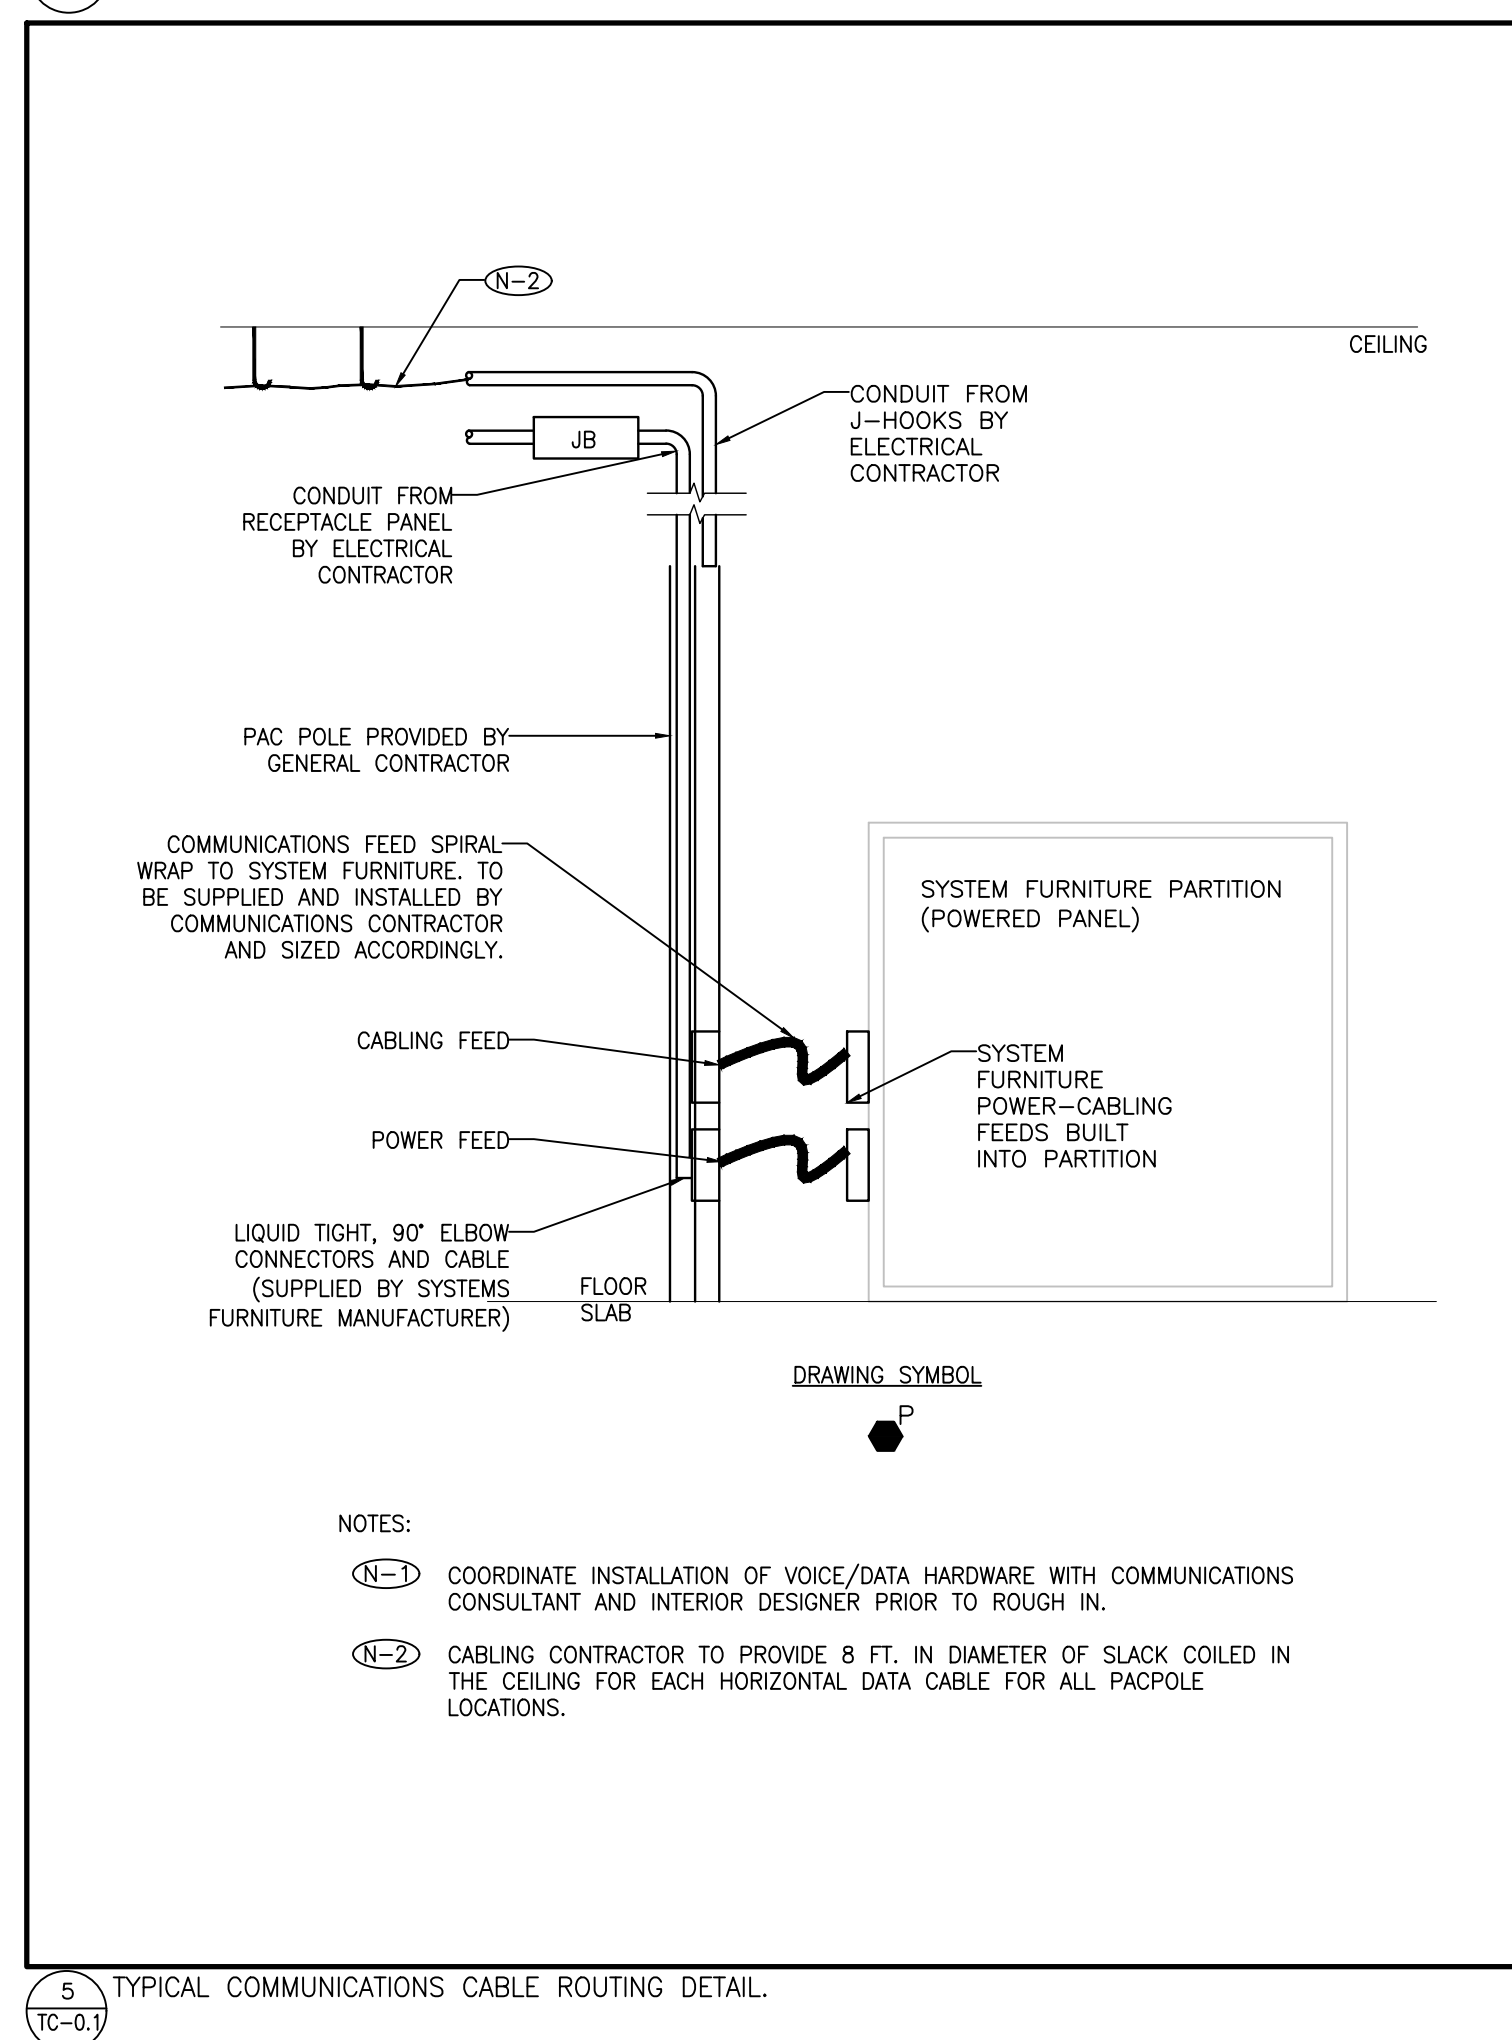
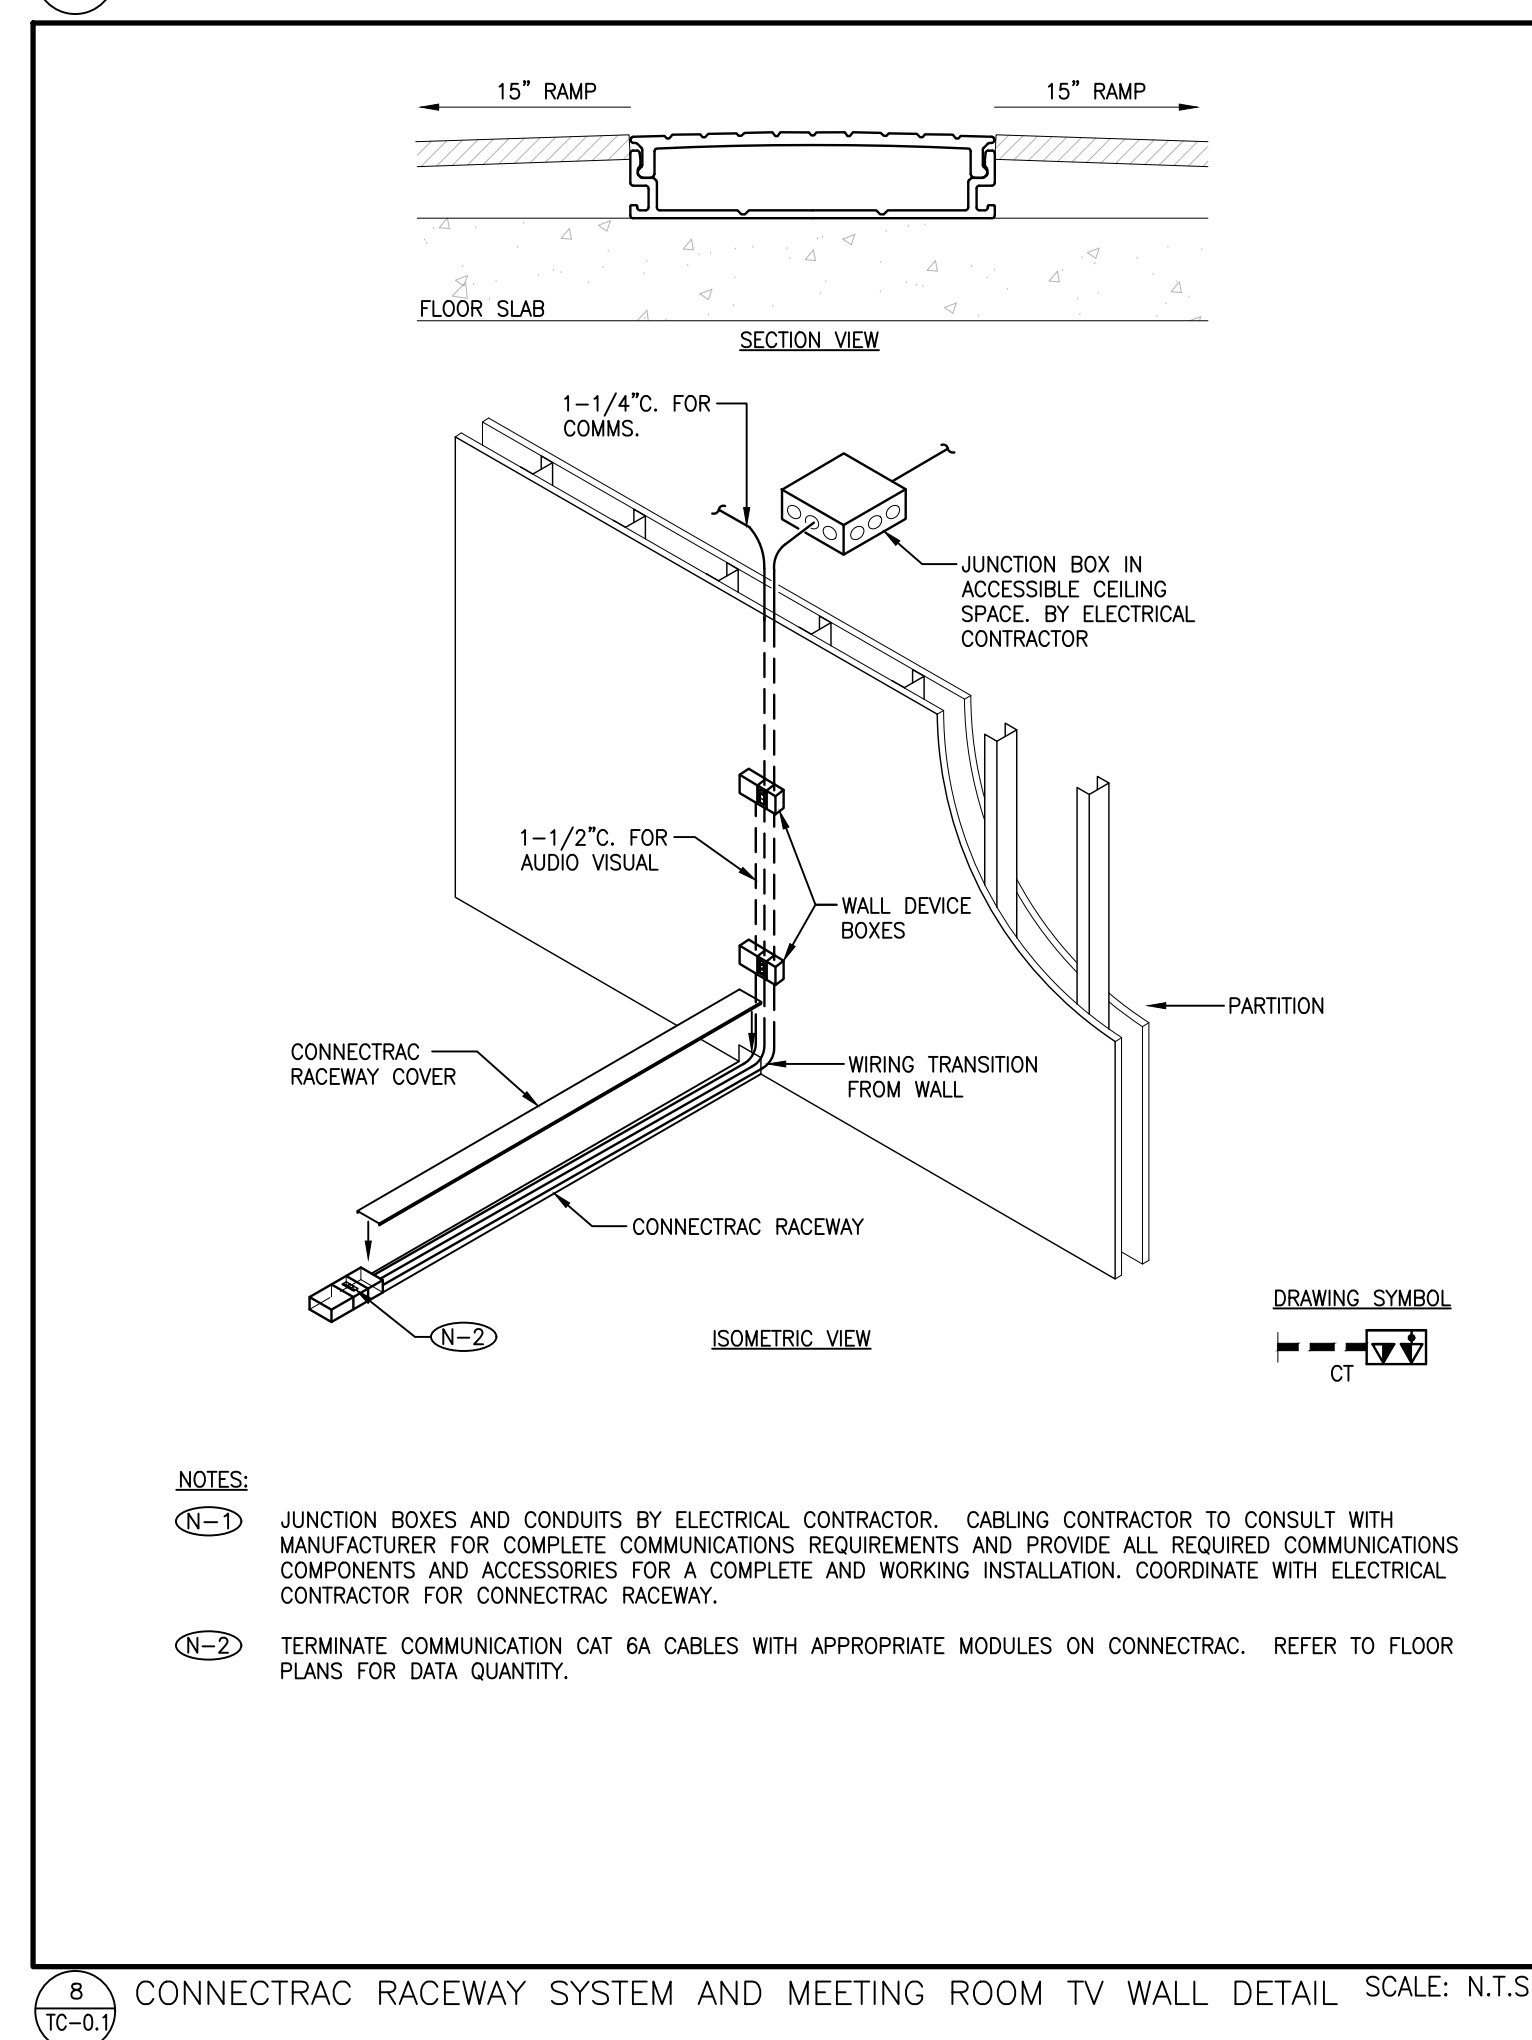


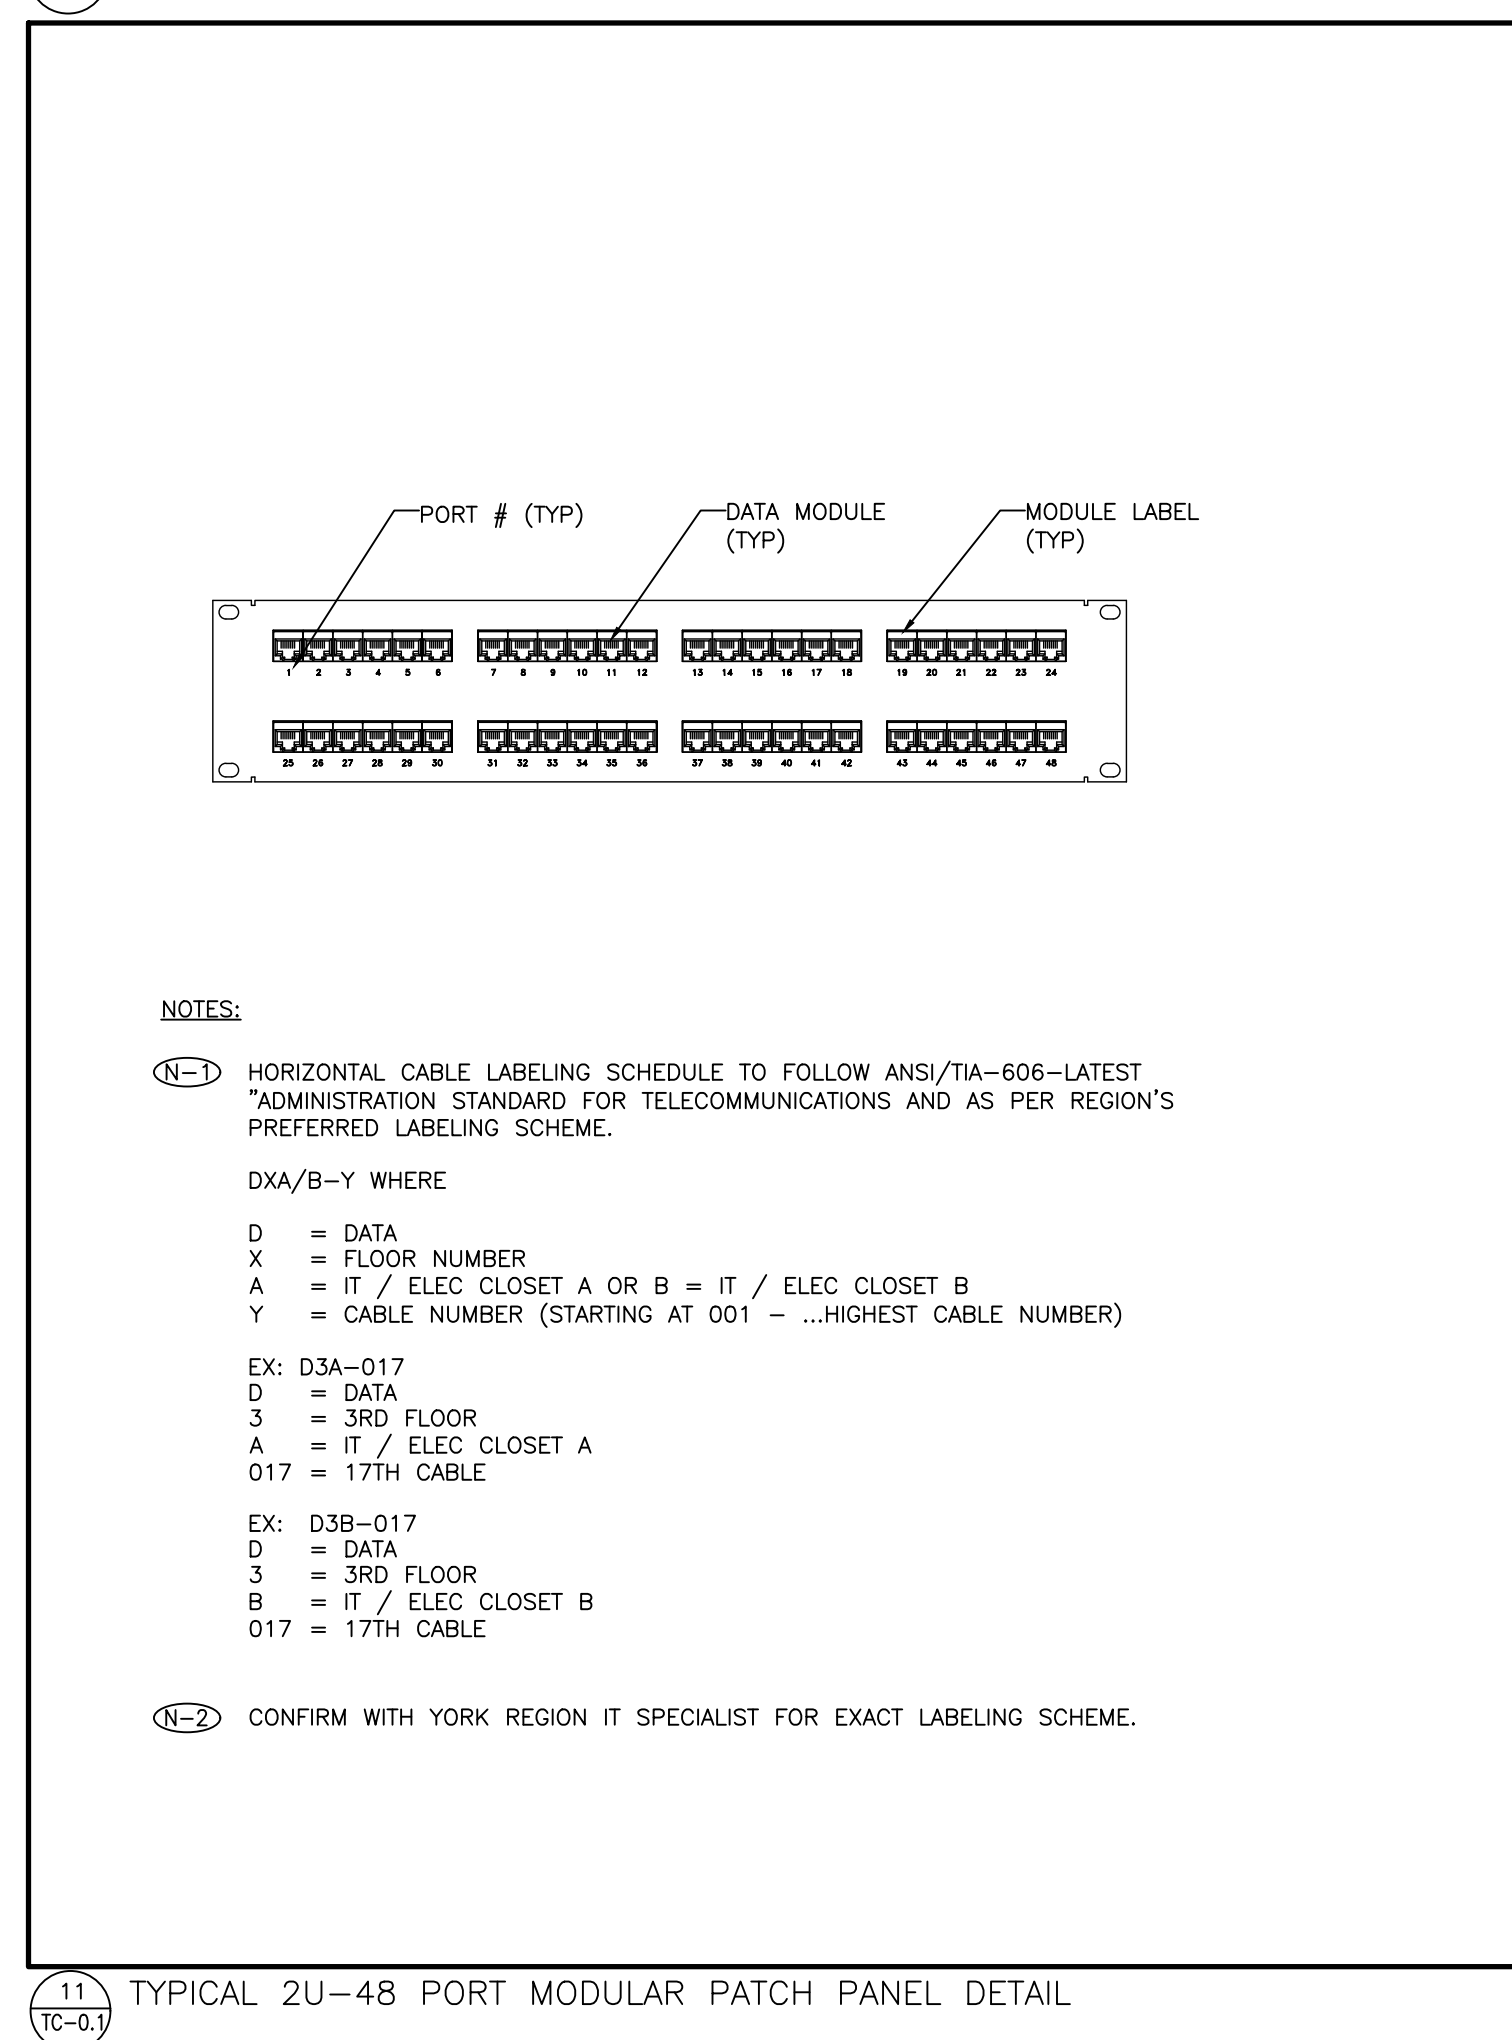

D-XXX	ONE DATA CABLE	BAS	BUILDING AUTOMATION SYSTEM
D-XXX D-XXX	TWO DATA CABLES	CT	CONTRACTAC
D-XXX D-XXX D-XXX	FOUR DATA CABLES	R/R	REMOVE AND REINSTALL
D-XXX D-XXX		WAP	WIRELESS ACCESS POINT

COMMUNICATIONS LEGEND	
	WALL MOUNTED VOICE AND/OR DATA OUTLET(S). CABLE TYPE AS PER SPECIFICATION.
	WALL MOUNTED AUDIO VISUAL CONNECTIONS. BY AUDIO VISUAL CONTRACTOR.
	FLOOR MOUNTED VOICE AND/OR DATA OUTLET(S). CABLE TYPE AS PER SPECIFICATION.
	FLOOR MOUNTED AUDIO VISUAL CONNECTIONS. BY AUDIO VISUAL CONTRACTOR.
	FURNITURE MOUNTED VOICE AND/OR DATA OUTLET(S). CABLE TYPE AS PER SPECIFICATION.
	CEILING MOUNTED VOICE AND/OR DATA OUTLET(S). CABLE TYPE AS PER SPECIFICATION.
	WIRED/POLE MOUNTED VOICE AND/OR DATA OUTLET(S). CABLE TYPE AS PER SPECIFICATION.
	PAC POLE MOUNTED VOICE AND/OR DATA OUTLET(S). CABLE TYPE AS PER SPECIFICATION.
	COAXIAL CATV OUTLET
	FEED POINT FOR COMMUNICATIONS CABLEING. LETTER DENOTES FEED LOCATION: W = WALL, F = FLOOR, P = PAC POLE, M = M/WISDMO
	LADDER TRAY FOR COMMUNICATIONS CABLEING. SIZE AS NOTED. BY ELECTRICAL CONTRACTOR UNLESS OTHERWISE NOTED.
	NOT IN CONTRACT

NOTE: NOT ALL SYMBOLS APPLY. CONTRACTOR TO REFER TO FLOOR PLANS.

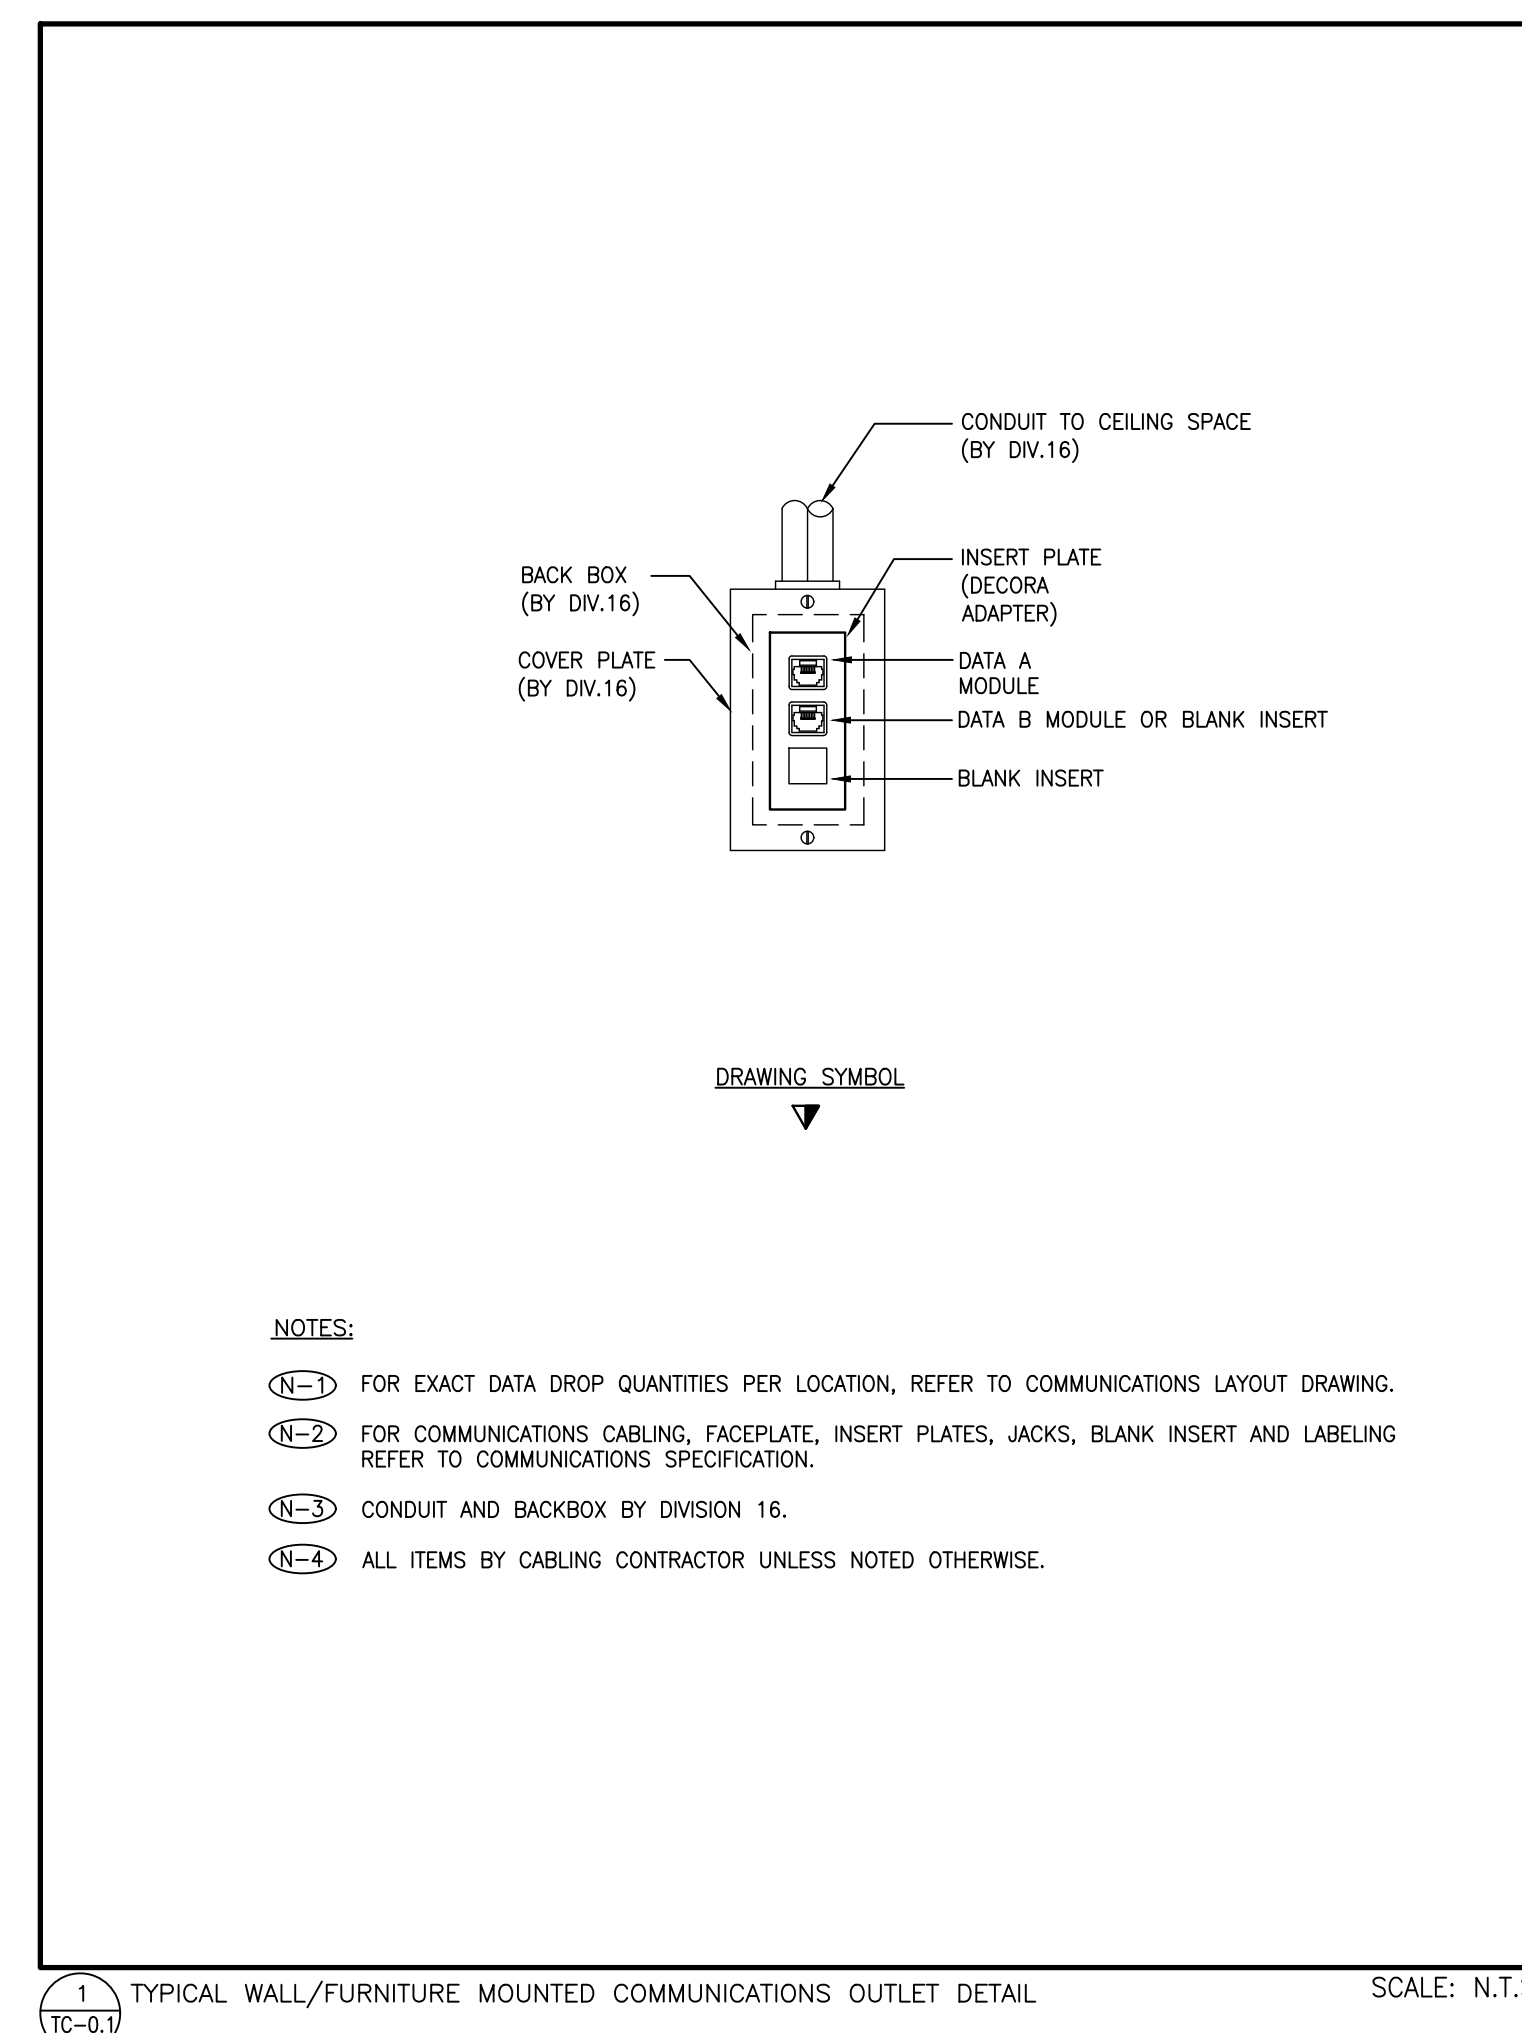

GENERAL NOTES:

1. CONTRACTOR MUST CHECK AND VERIFY ALL DIMENSIONS, DETAILS AND SPECIFICATIONS ON SITE AND REPORT ANY DISCREPANCIES IN WRITING TO YORK REGION REPRESENTATIVE BEFORE PROCEEDING WITH THE WORK
2. DRAWINGS ARE NOT TO BE SCALED
3. BEFORE PROCEEDING WITH THE WORK, CONTRACTOR MUST SUBMIT ALL NECESSARY SAMPLES AND SHOP DRAWINGS TO YORK REGION REPRESENTATIVE FOR APPROVAL
4. ALL DRAWINGS AND SPECIFICATIONS ARE THE PROPERTY OF YORK REGION. AS SUCH, THEY ARE NOT INTENDED FOR USE ON OTHER PROJECTS OR EXTENSIONS OF THE PROJECT SPECIFIED

SUBMISSION	DATE	DESCRIPTION
5	2021-03-22	ISSUED FOR CONSTRUCTION
4	2020-11-05	ISSUED FOR TENDER
3	2020-05-25	ISSUED FOR TENDER
2	2020-05-18	ISSUED FOR 60% REVIEW
1	2020-03-18	ISSUED FOR 60% REVIEW

G.Bruce Stratton Architects

217 Richmond Street West, Suite 300
Toronto Ontario M5V 1W2
telephone: 416.351.8145
facsimile: 416.351.8146




1100 - 100 Sheppard Ave. East, Toronto On, M2N 6M5
416 487 8151 f 416 487 9104 smithandandersen.com

PROJECT CONTACT

NAME: JOSIE PENULIAR
TEL: 647-288-5467
EMAIL: josie.penuliar@smithandandersen.com

THIS DRAWING SHALL BE READ IN CONJUNCTION
WITH COMMUNICATIONS SPECIFICATION SUBMITTED
FOR THIS PROJECT.

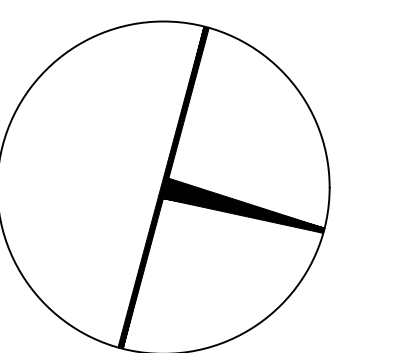

York Region

PROPERTY SERVICES

DEPARTMENT: BUILDING & FACILITIES

FLOOR:	003
--------	-----

BASE DATE:	03-01-2020
------------	------------

PROJECT:

PROJECT # 14008.009

YORK REGION

Administrative Centre
17250 Yonge Street
Newmarket, Ontario

SCALE: AS SHOWN

DRAWN BY: D.A.

SUBMITTED TO: MUNICIPALITY OF YORK

SHEET TITLE:

DRAWING LIST,
LEGEND,
ABBREVIATIONS AND
DETAILS

SHEET NUMBER:

TC-0.1



1. REFER TO ARCHITECTURAL PLANS FOR DIMENSIONS, HEIGHTS, PARTITION TYPES, CEILING TYPES, CONSTRUCTION DETAILING, MOUNTING DETAILS, FINISHES, AND COLOURS.
2. WHILE EVERY ATTEMPT HAS BEEN MADE TO ENSURE ALL INFORMATION IS CORRECT AT THE TIME OF PUBLICATION, THE PRODUCTS SPECIFIED ARE AVAILABLE AND THAT THE PART NUMBER IDENTIFIED ARE CORRECT, IT IS THE RESPONSIBILITY OF THE COMMUNICATIONS CONTRACTOR TO VERIFY ALL PART NUMBERS AND TO REPORT ANY ERRORS AND/OR OMISSIONS IN THE DRAWINGS AND SPECIFICATIONS WITH THEIR BID SUBMISSION.
3. ALL ITEMS BY COMMUNICATIONS CONTRACTOR UNLESS OTHERWISE NOTED,

④-1 CONNECTRAC BY ELECTRICAL CONTRACTOR.

④-2 EXISTING WIRELESS ACCESS POINT TO REMAIN, (EXISTING WAP LOCATIONS ON DRAWINGS ARE APPROXIMATE). ELECTRICAL CONTRACTOR TO LABEL AND MAP EACH WAP EXACT LOCATION PRIOR TO REMOVAL THEN REMOVE AND REINSTALL WIRELESS ACCESS POINT AT THE SAME LOCATION AS REQUIRED.

④-3 DATA CABLES/OUTLET FOR B/S (BUILDING AUTOMATION SYSTEM). COORDINATE INSTALLATION LOCATION ON SITE.

1. CONTRACTOR MUST CHECK AND VERIFY ALL DIMENSIONS, DETAILS AND SPECIFICATIONS ON SITE AND REPORT ANY DISCREPANCIES IN WRITING TO YORK REGION REPRESENTATIVE BEFORE PROCEEDING WITH THE WORK
2. DRAWINGS ARE NOT TO BE SCALED
3. BEFORE PROCEEDING WITH THE WORK, CONTRACTOR MUST SUBMIT ALL NECESSARY SAMPLES AND SHOP DRAWINGS TO YORK REGION REPRESENTATIVE FOR APPROVAL
4. ALL DRAWINGS AND SPECIFICATIONS ARE THE PROPERTY OF YORK REGION. AS SUCH, THEY ARE NOT INTENDED FOR USE ON OTHER PROJECTS OR EXTENSIONS OF THE PROJECT SPECIFIED

G.Bruce Stratton Architects

1100 - 100 Sheppard Ave. East, Toronto On, M2N 6N5
416 487 8151 f 416 487 2104 amithandanderaan.com

EMAIL: iosie.perulio@smithanddanielsen.com



PROJECT:

YORK REGION

Administrative Centre
17250 Yonge Street
Newmarket, Ontario

SHEET TITLE:

TC-3.0A




- GENERAL NOTES**
1. REFER TO ARCHITECTURAL PLANS FOR DIMENSIONS, HEIGHTS, PARTITION TYPES, CEILING TYPES, CONSTRUCTION DETAILING, MOUNTING DETAILS, FINISHES, AND COLOURS.
 2. WHILE EVERY ATTEMPT HAS BEEN MADE TO ENSURE ALL INFORMATION IS CORRECT AT THE TIME OF PUBLICATION, THE PRODUCTS SPECIFIED ARE AVAILABLE AND THAT THE PART NUMBER IDENTIFIED ARE CORRECT, IT IS THE RESPONSIBILITY OF THE COMMUNICATIONS CONTRACTOR TO VERIFY ALL PART NUMBERS AND TO REPORT ANY ERRORS AND/OR OMISSIONS IN THE DRAWINGS AND SPECIFICATIONS WITH THEIR BID SUBMISSION.
 3. ALL ITEMS BY COMMUNICATIONS CONTRACTOR UNLESS OTHERWISE NOTED.
- DRAWING NOTES**
- (C) CONNECTRAC BY ELECTRICAL CONTRACTOR.
 - (E) EXISTING WIRELESS ACCESS POINT TO REMAIN. (EXISTING WAP LOCATIONS ON DRAWINGS ARE APPROXIMATES). ELECTRICAL CONTRACTOR TO LABEL AND MAP OUT EACH WAP EXACT LOCATION PRIOR TO REMOVAL THEN REMOVE AND REINSTALL (RR) WIRELESS ACCESS POINT AT THE SAME LOCATION AS REQUIRED.
 - (D) DATA CABLES/OUTLET FOR BAS (BUILDING AUTOMATION SYSTEM). COORDINATE INSTALLATION LOCATION ON SITE.

- GENERAL NOTES:**
1. CONTRACTOR MUST CHECK AND VERIFY ALL DIMENSIONS, DETAILS AND SPECIFICATIONS ON SITE AND REPORT ANY DISCREPANCIES IN WRITING TO YORK REGION REPRESENTATIVE BEFORE PROCEEDING WITH THE WORK
 2. DRAWINGS ARE NOT TO BE SCALED
 3. BEFORE PROCEEDING WITH THE WORK, CONTRACTOR MUST SUBMIT ALL NECESSARY SAMPLES AND SHOP DRAWINGS TO YORK REGION REPRESENTATIVE FOR APPROVAL
 4. ALL DRAWINGS AND SPECIFICATIONS ARE THE PROPERTY OF YORK REGION. AS SUCH, THEY ARE NOT INTENDED FOR USE ON OTHER PROJECTS OR EXTENSIONS OF THE PROJECT SPECIFIED

SUBMISSION	DATE	DESCRIPTION
5	2021-03-22	ISSUED FOR CONSTRUCTION
4	2020-11-05	ISSUED FOR TENDER
3	2020-06-25	ISSUED FOR TENDER
2	2020-05-18	ISSUED FOR 90% REVIEW
1	2020-03-18	ISSUED FOR 60% REVIEW


G.Bruce Stratton Architects
217 Richmond Street West, Suite 300
Toronto Ontario M5V 1W2
telephone: 416.351.8145
facsimile: 416.351.8146

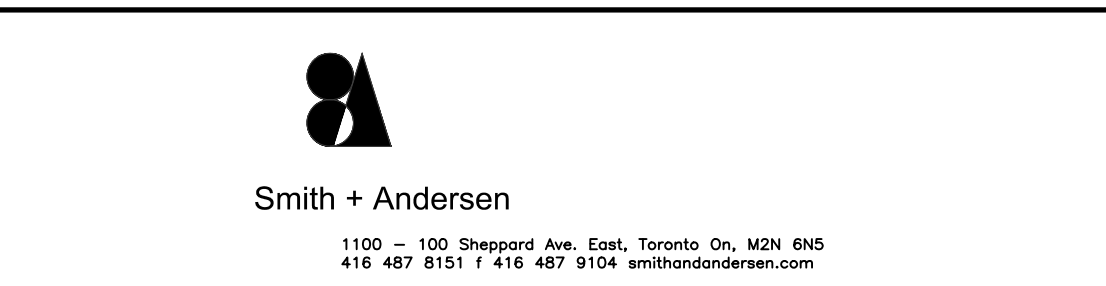

PROJECT CONTACT

NAME:	JOSIE PENULAR
TEL:	647-298-5467
EMAIL:	jodie.penular@smithandandersen.com

THIS DRAWING SHALL BE READ IN CONJUNCTION WITH COMMUNICATIONS SPECIFICATION SUBMITTED FOR THIS PROJECT.

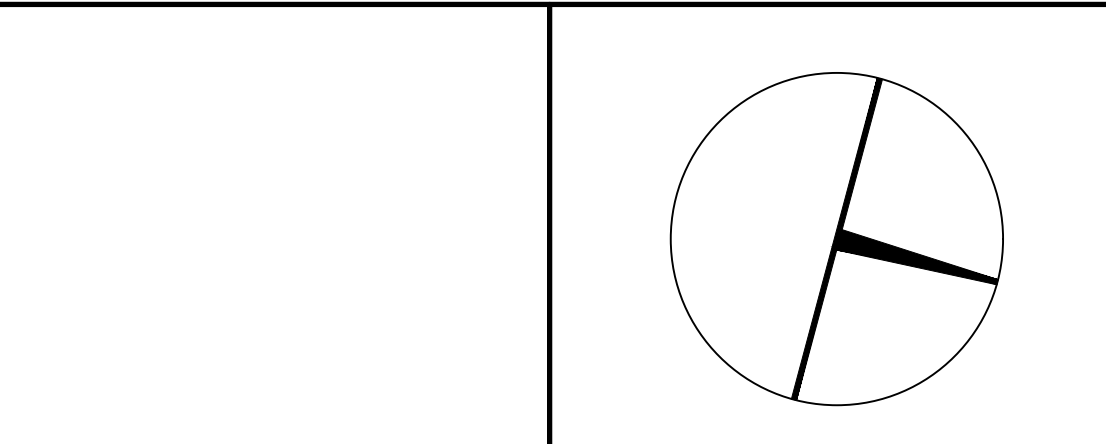

York Region
PROPERTY SERVICES

DEPARTMENT: BUILDING & FACILITIES
FLOOR: 003
BASE DATE: 03-01-2020

PROJECT:
PROJECT # 14008.009
YORK REGION
Administrative Centre
17250 Yonge Street
Newmarket, Ontario

SCALE: 1:100
DRAWN BY: D.A.
SUBMITTED TO: MUNICIPALITY OF YORK
SHEET TITLE:

LEVEL 3 –
COMMUNICATIONS
LAYOUT (PART B)
SHEET NUMBER:

TC-3.0B