

MECHANICAL DRAWING LIST	
Sheet Number	Sheet Name
M0001	MECHANICAL DRAWING LIST
M0201	MECHANICAL EQUIPMENT SCHEDULE
M1101	DEMOLITION PLAN - GROUND FLOOR
M2101	PLUMBING - BASEMENT
M2102	PLUMBING - GROUND FLOOR
M3101	DRAINAGE - BASEMENT
M3102	DRAINAGE - GROUND FLOOR
M5101	HVAC - GROUND FLOOR

CLIENT

CITY OF TORONTO



CITY OF TORONTO

Corporate Real Estate Management

Project Management Office

Metro Hall Toronto, ON

MSV 3C6

**COPYRIGHT**  
This drawing has been prepared solely for the intended use. Thus any reproduction or distribution for any purpose other than authorized by IBI Group is forbidden. Written dimensions shall have precedence over scaled dimensions. Contractors shall verify and be responsible for all dimensions and conditions on the job, and IBI Group shall be informed of any variations from the dimensions and conditions shown on the drawing. Shop drawings shall be submitted to IBI Group for general conformance before proceeding with fabrication.

**IBI Group Professional Services (Canada) Inc.**  
is a member of the IBI Group of companies

ISSUES		
No.	DESCRIPTION	DATE
00	ISSUED FOR CONSTRUCTION	2021-10-19

CONSULTANTS

SEAL



PRIME CONSULTANT



IBI GROUP

175 Galaxy Blvd, Unit 100

Toronto, ON M9W 0C9, Canada

tel 416 679 1930 fax 416 675 4620

ibigroup.com

PROJECT TITLE  
CITY OF TORONTO  
ACCESSIBILITY UPGRADES

PROJECT ADDRESS  
FIRE HALL NO. 143  
1009 SHEPPARD AVE  
WEST

PROJECT NO:  
91119- 19- 0162 / IBI 122260

DRAWN BY: K.DURUKAN	CHECKED BY: B.LIAO
------------------------	-----------------------

PROJECT MGR: F. BOLOURIAN	APPROVED BY: S.LIU
------------------------------	-----------------------

SHEET TITLE  
MECHANICAL DRAWING  
LIST

SHEET NUMBER	ISSUE
G08-008-M0001	00

EXHAUST FAN SCHEDULE									
TAG NO.	SERVICE	MANUFACTURER/ MODEL NO.	CAPACITY (LPS)	S.P. (Pa)	FAN	MOTOR			NOTES
					TYPE	HP	RPM	V/Ph/Hz	
EF-01	BARRIER FREE W/R 110	GREENHECK MODEL SP-A190	56	93	CEILING EXHAUST FAN, DIRECT DRIVE	1/50	1400	115/1/60	CONTROLLED BY LIGHTING SWITCH, C/W EXHAUST GRILLE, DISCONNECT SWITCH, BACKDRAFT DAMPER, ROUND DUCT CONNECTOR AND DISCHARGE WEATHER CAP

ELECTRICAL HEATER SCHEDULE								
TAG NO.	SERVICE	MANUFACTURER/ MODEL NO.	CAPACITY OUTPUT (KW)	V/Ph/Hz	WEIGHT (KG)	FAN		NOTES
						POWER (KW)	FLOW (LPS)	
FAH-01	BARRIER FREE W/R 110	OUELLET OACP2000	2	208/1/60	10.9	-	75	PROVIDE DISCONNECT SWITCH AND COMPATIBLE REMOTE LOW VOLTAGE THERMOSTAT

CLIENT

CITY OF TORONTO



Corporate Real Estate Management  
Project Management Office  
Metro Hall Toronto, ON  
MSV 3C6

**COPYRIGHT**  
This drawing has been prepared solely for the intended use. Thus any reproduction or distribution for any purpose other than authorized by IBI Group is forbidden. Written dimensions shall have precedence over scaled dimensions. Contractors shall verify and be responsible for all dimensions and conditions on the job, and IBI Group shall be informed of any variations from the dimensions and conditions shown on the drawing. Shop drawings shall be submitted to IBI Group for general conformance before proceeding with fabrication.

**IBI Group Professional Services (Canada) Inc.**  
is a member of the IBI Group of companies

ISSUES		
No.	DESCRIPTION	DATE
00	ISSUED FOR CONSTRUCTION	2021-10-19

CONSULTANTS

SEAL



PRIME CONSULTANT



**IBI GROUP**  
175 Galaxy Blvd, Unit 100  
Toronto, ON M9W 0C9, Canada  
tel 416 679 1930 fax 416 675 4620  
ibigroup.com

PROJECT TITLE  
CITY OF TORONTO  
ACCESSIBILITY UPGRADES


PROJECT ADDRESS  
FIRE HALL NO. 143  
1009 SHEPPARD AVE  
WEST

PROJECT NO: 9119- 19- 0162 / IBI 122260	
DRAWN BY: <b>K.DURUKAN</b>	CHECKED BY: <b>B.LIAO</b>
PROJECT MGR: <b>F. BOLOURIAN</b>	APPROVED BY: <b>S.LIU</b>


SHEET TITLE  
MECHANICAL  
EQUIPMENT SCHEDULE

SHEET NUMBER <b>G08-008-M0201</b>	ISSUE <b>00</b>
--------------------------------------	--------------------

2021-10-19 9:16:24 AM

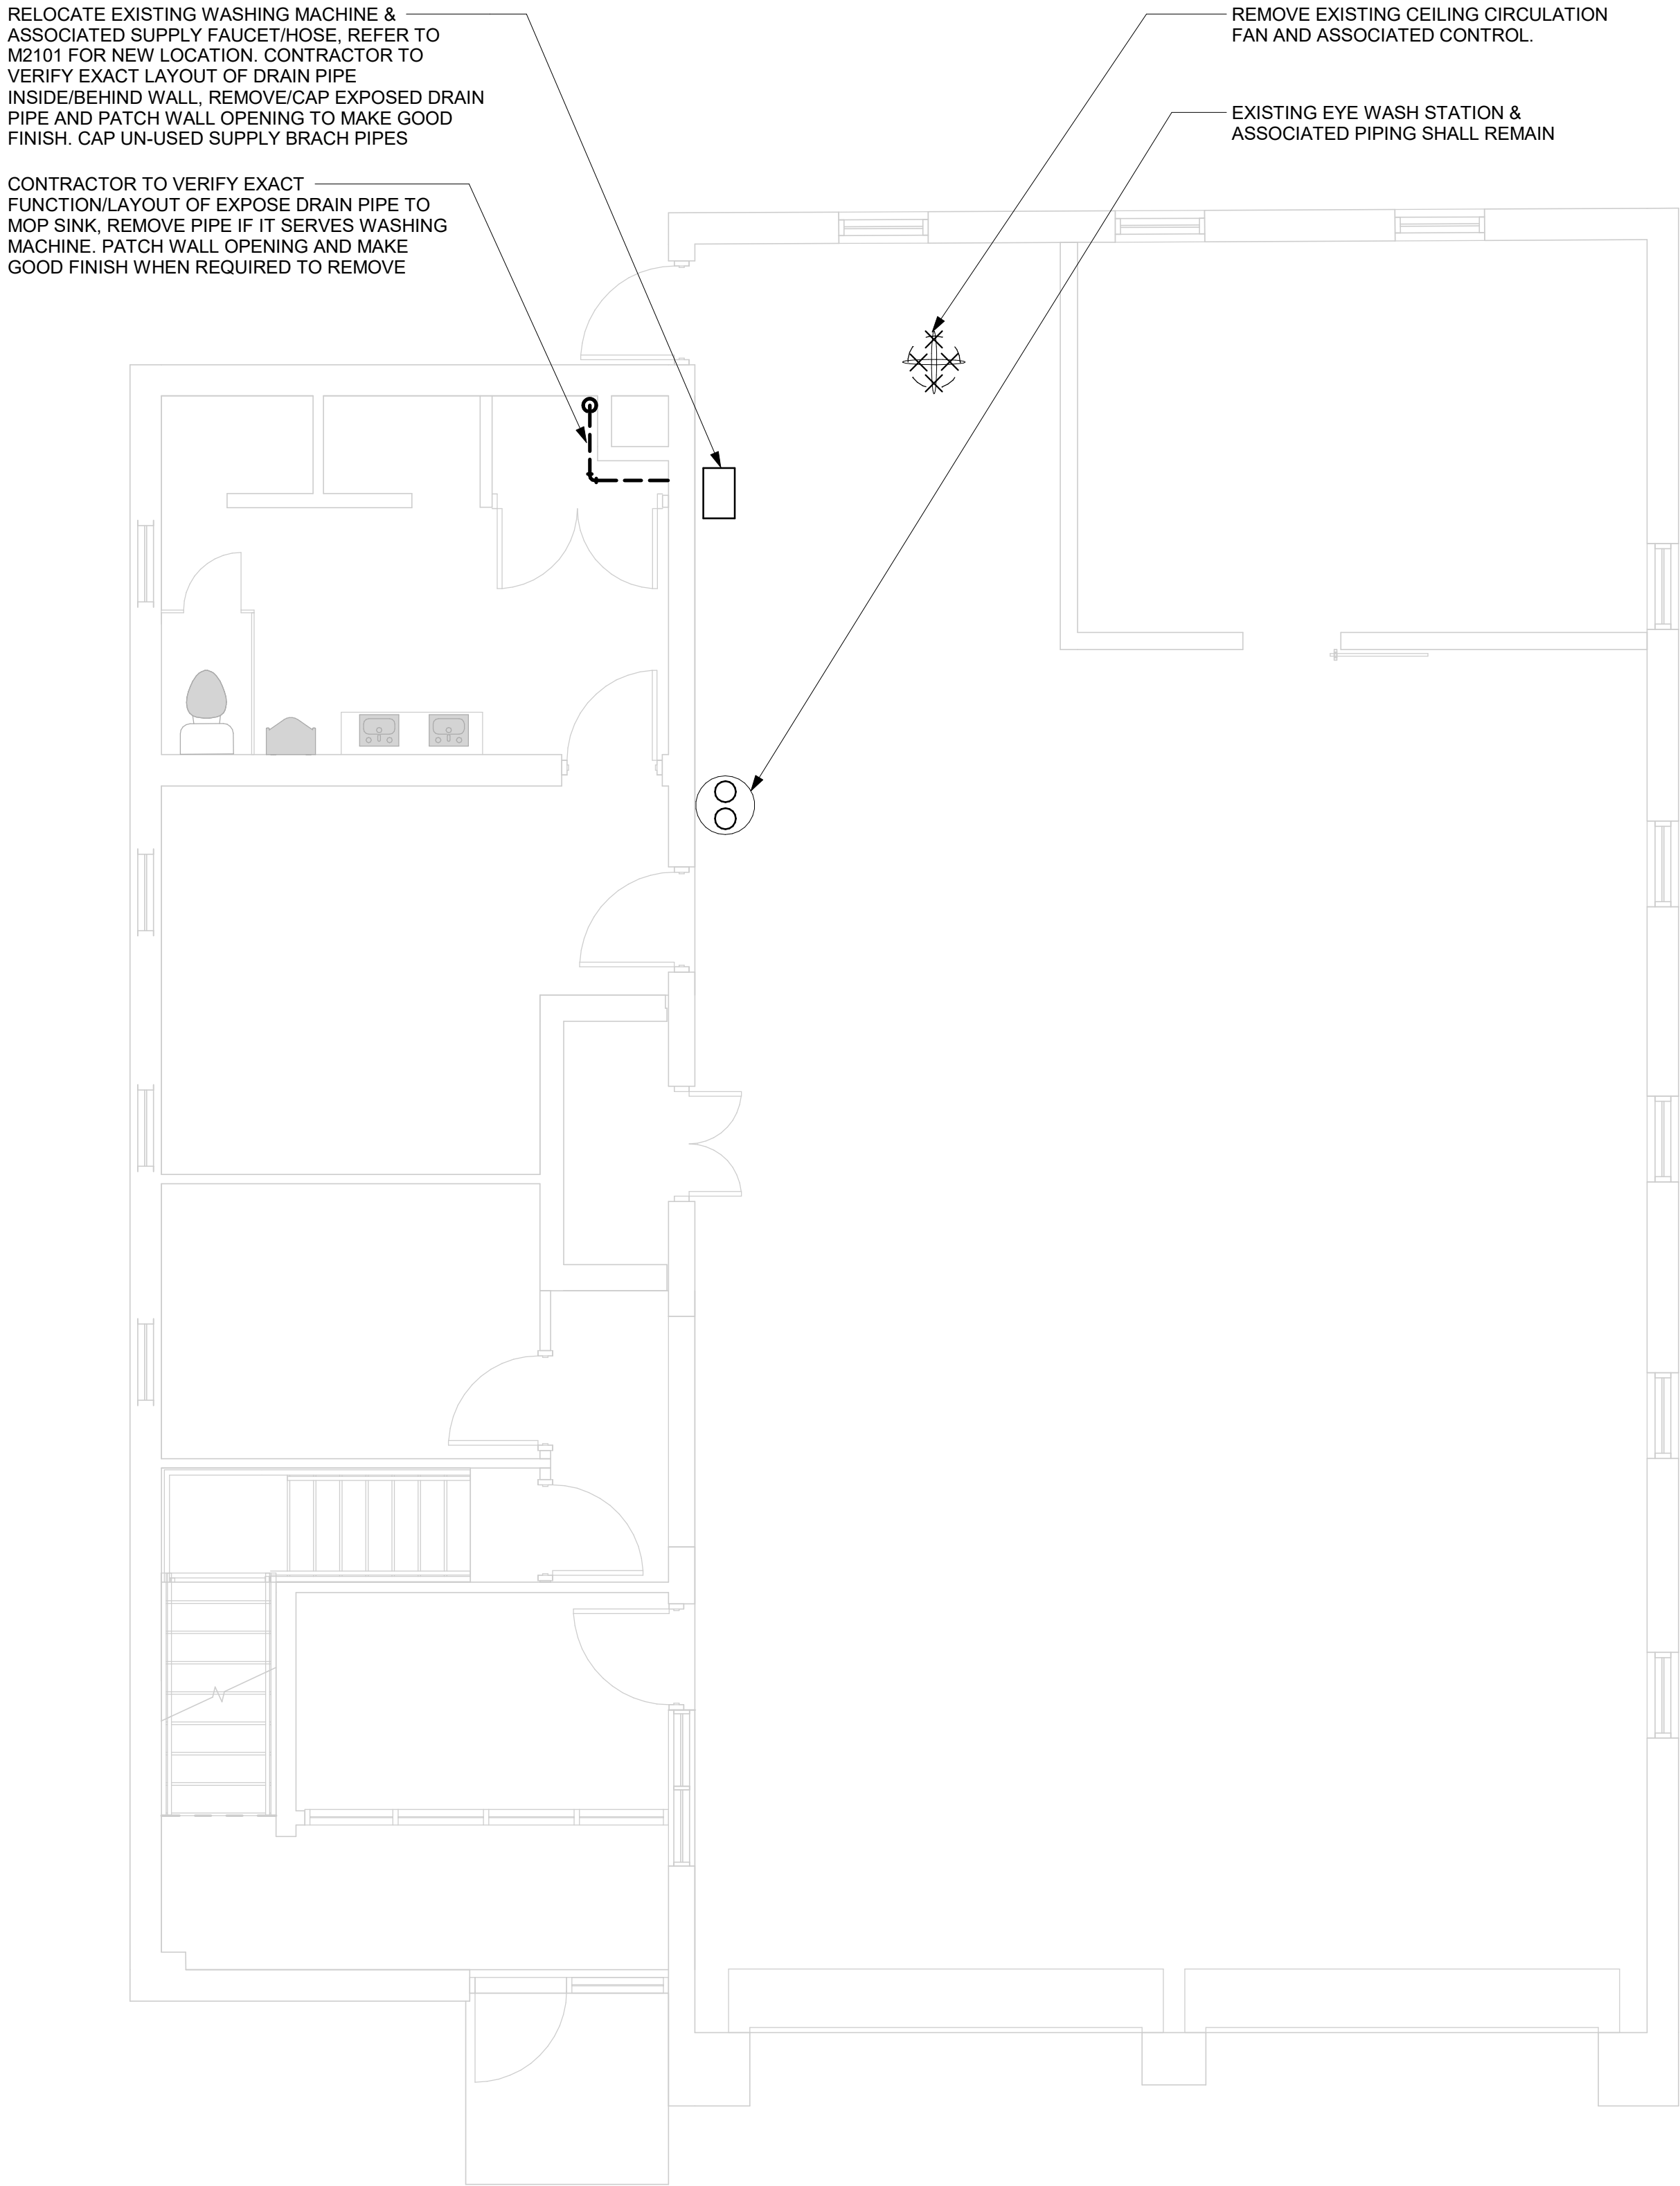

- GENERAL NOTES:  
1. CONTRACTOR TO VERIFY SITE CONDITION.  
2. REMOVE AND CAP EXISTING SERVICES AS SHOWN ON THE DRAWING

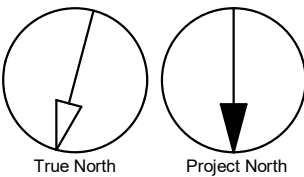

CLIENT

**CITY OF TORONTO**

Corporate Real Estate Management  
Project Management Office  
Metro Hall Toronto, ON  
MSV 3C6

**COPYRIGHT**  
This drawing has been prepared solely for the intended use, thus any reproduction or distribution for any purpose other than authorized by IBI Group is forbidden. Written dimensions shall have precedence over scaled dimensions. Contractors shall verify and be responsible for all dimensions and conditions on the job, and IBI Group shall be informed of any variations from the dimensions and conditions shown on the drawing. Shop drawings shall be submitted to IBI Group for general conformance before proceeding with fabrication.

**IBI Group Professional Services (Canada) Inc.**  
is a member of the IBI Group of companies

ISSUES		
No.	DESCRIPTION	DATE
00	ISSUED FOR CONSTRUCTION	2021-10-19

CONSULTANTS

SEAL



PRIME CONSULTANT

**IBI GROUP**  
175 Galaxy Blvd, Unit 100  
Toronto, ON M9W 0C9, Canada  
tel 416 679 1930 fax 416 675 4620  
ibigroup.com

PROJECT TITLE  
**CITY OF TORONTO  
ACCESSIBILITY UPGRADES**

PROJECT ADDRESS  
**FIRE HALL NO. 143  
1009 SHEPPARD AVE  
WEST**

PROJECT NO:  
9119- 19- 0162 / IBI 122260

DRAWN BY: <b>K.DURUKAN</b>	CHECKED BY: <b>B.LIAO</b>
PROJECT MGR: <b>F. BOLOURIAN</b>	APPROVED BY: <b>S.LIU</b>

SHEET TITLE  
**DEMOLITION PLAN -  
GROUND FLOOR**


SHEET NUMBER <b>G08-008-M1101</b>	ISSUE <b>00</b>
--------------------------------------	--------------------

C:\Users\bingxi.liao\Documents\REV\T2020\122260-TAU-S-S-1008SHPRD-M-R20\_bingxi.liao.rvt


10mm

SCALE CHECK  
1 m

2021-10-19 9:16:25 AM

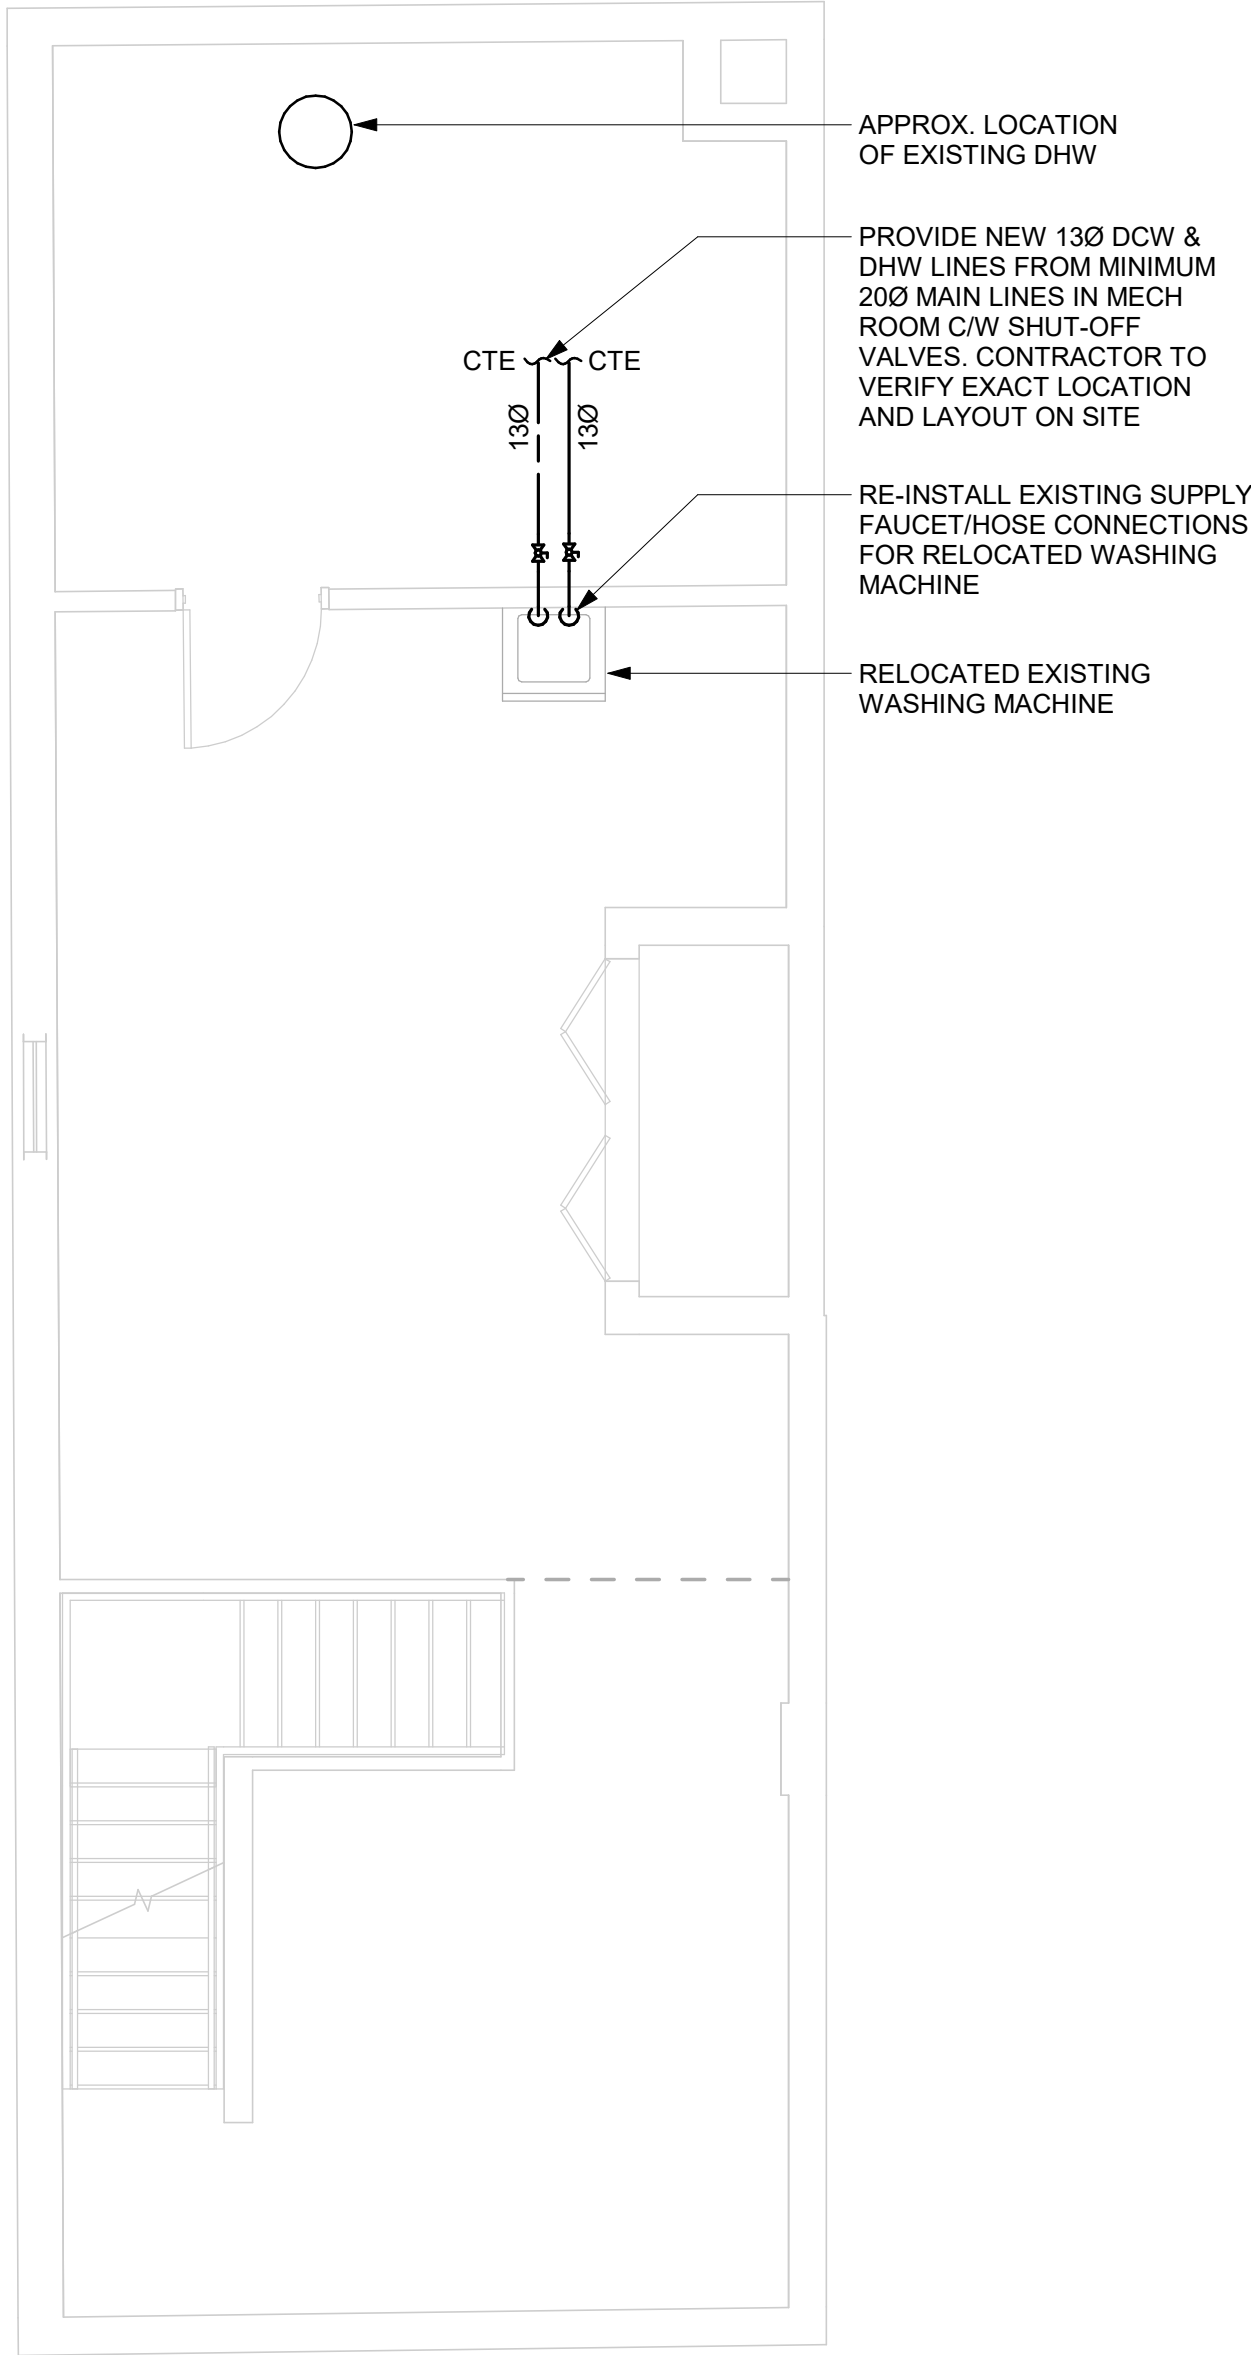

GENERAL NOTES:  
1. REFER TO SPECIFICATIONS FOR PLUMBING FIXTURE UNIT TYPES.  
2. ALL NEW FIXTURES TO BE FITTED WITH ISOLATION VALVES.

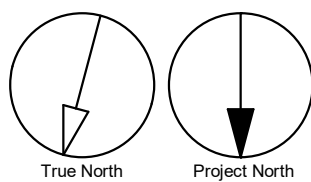

CLIENT

**CITY OF TORONTO**

  
Corporate Real Estate Management  
Project Management Office  
Metro Hall Toronto, ON  
MSV 3C6

**COPYRIGHT**  
This drawing has been prepared solely for the intended use, thus any reproduction or distribution for any purpose other than authorized by IBI Group is forbidden. Written dimensions shall have precedence over scaled dimensions. Contractors shall verify and be responsible for all dimensions and conditions on the job, and IBI Group shall be informed of any variations from the dimensions and conditions shown on the drawing. Shop drawings shall be submitted to IBI Group for general conformance before proceeding with fabrication.

**IBI Group Professional Services (Canada) Inc.**  
is a member of the IBI Group of companies

ISSUES		
No.	DESCRIPTION	DATE
00	ISSUED FOR CONSTRUCTION	2021-10-19

CONSULTANTS

SEAL



PRIME CONSULTANT



PROJECT TITLE  
**CITY OF TORONTO  
ACCESSIBILITY UPGRADES**

PROJECT ADDRESS  
**FIRE HALL NO. 143  
1009 SHEPPARD AVE  
WEST**

PROJECT NO:  
9119- 19- 0162 / IBI 122260

DRAWN BY:  
**K.DURUKAN**

CHECKED BY:  
**B.LIAO**

PROJECT MGR:  
**F. BOLOURIAN**

APPROVED BY:  
**S.LIU**

SHEET TITLE  
**PLUMBING - BASEMENT**

SHEET NUMBER  
**G08-008-M2101**


ISSUE  
**00**

C:\Users\bingxi.liao\Documents\REV\T2020\122260-TAU-S-S-1009SHPRD-M-R20\_bingxi.liao.rvt


10mm

SCALE CHECK  
1 m

2021-10-19 9:16:25 AM

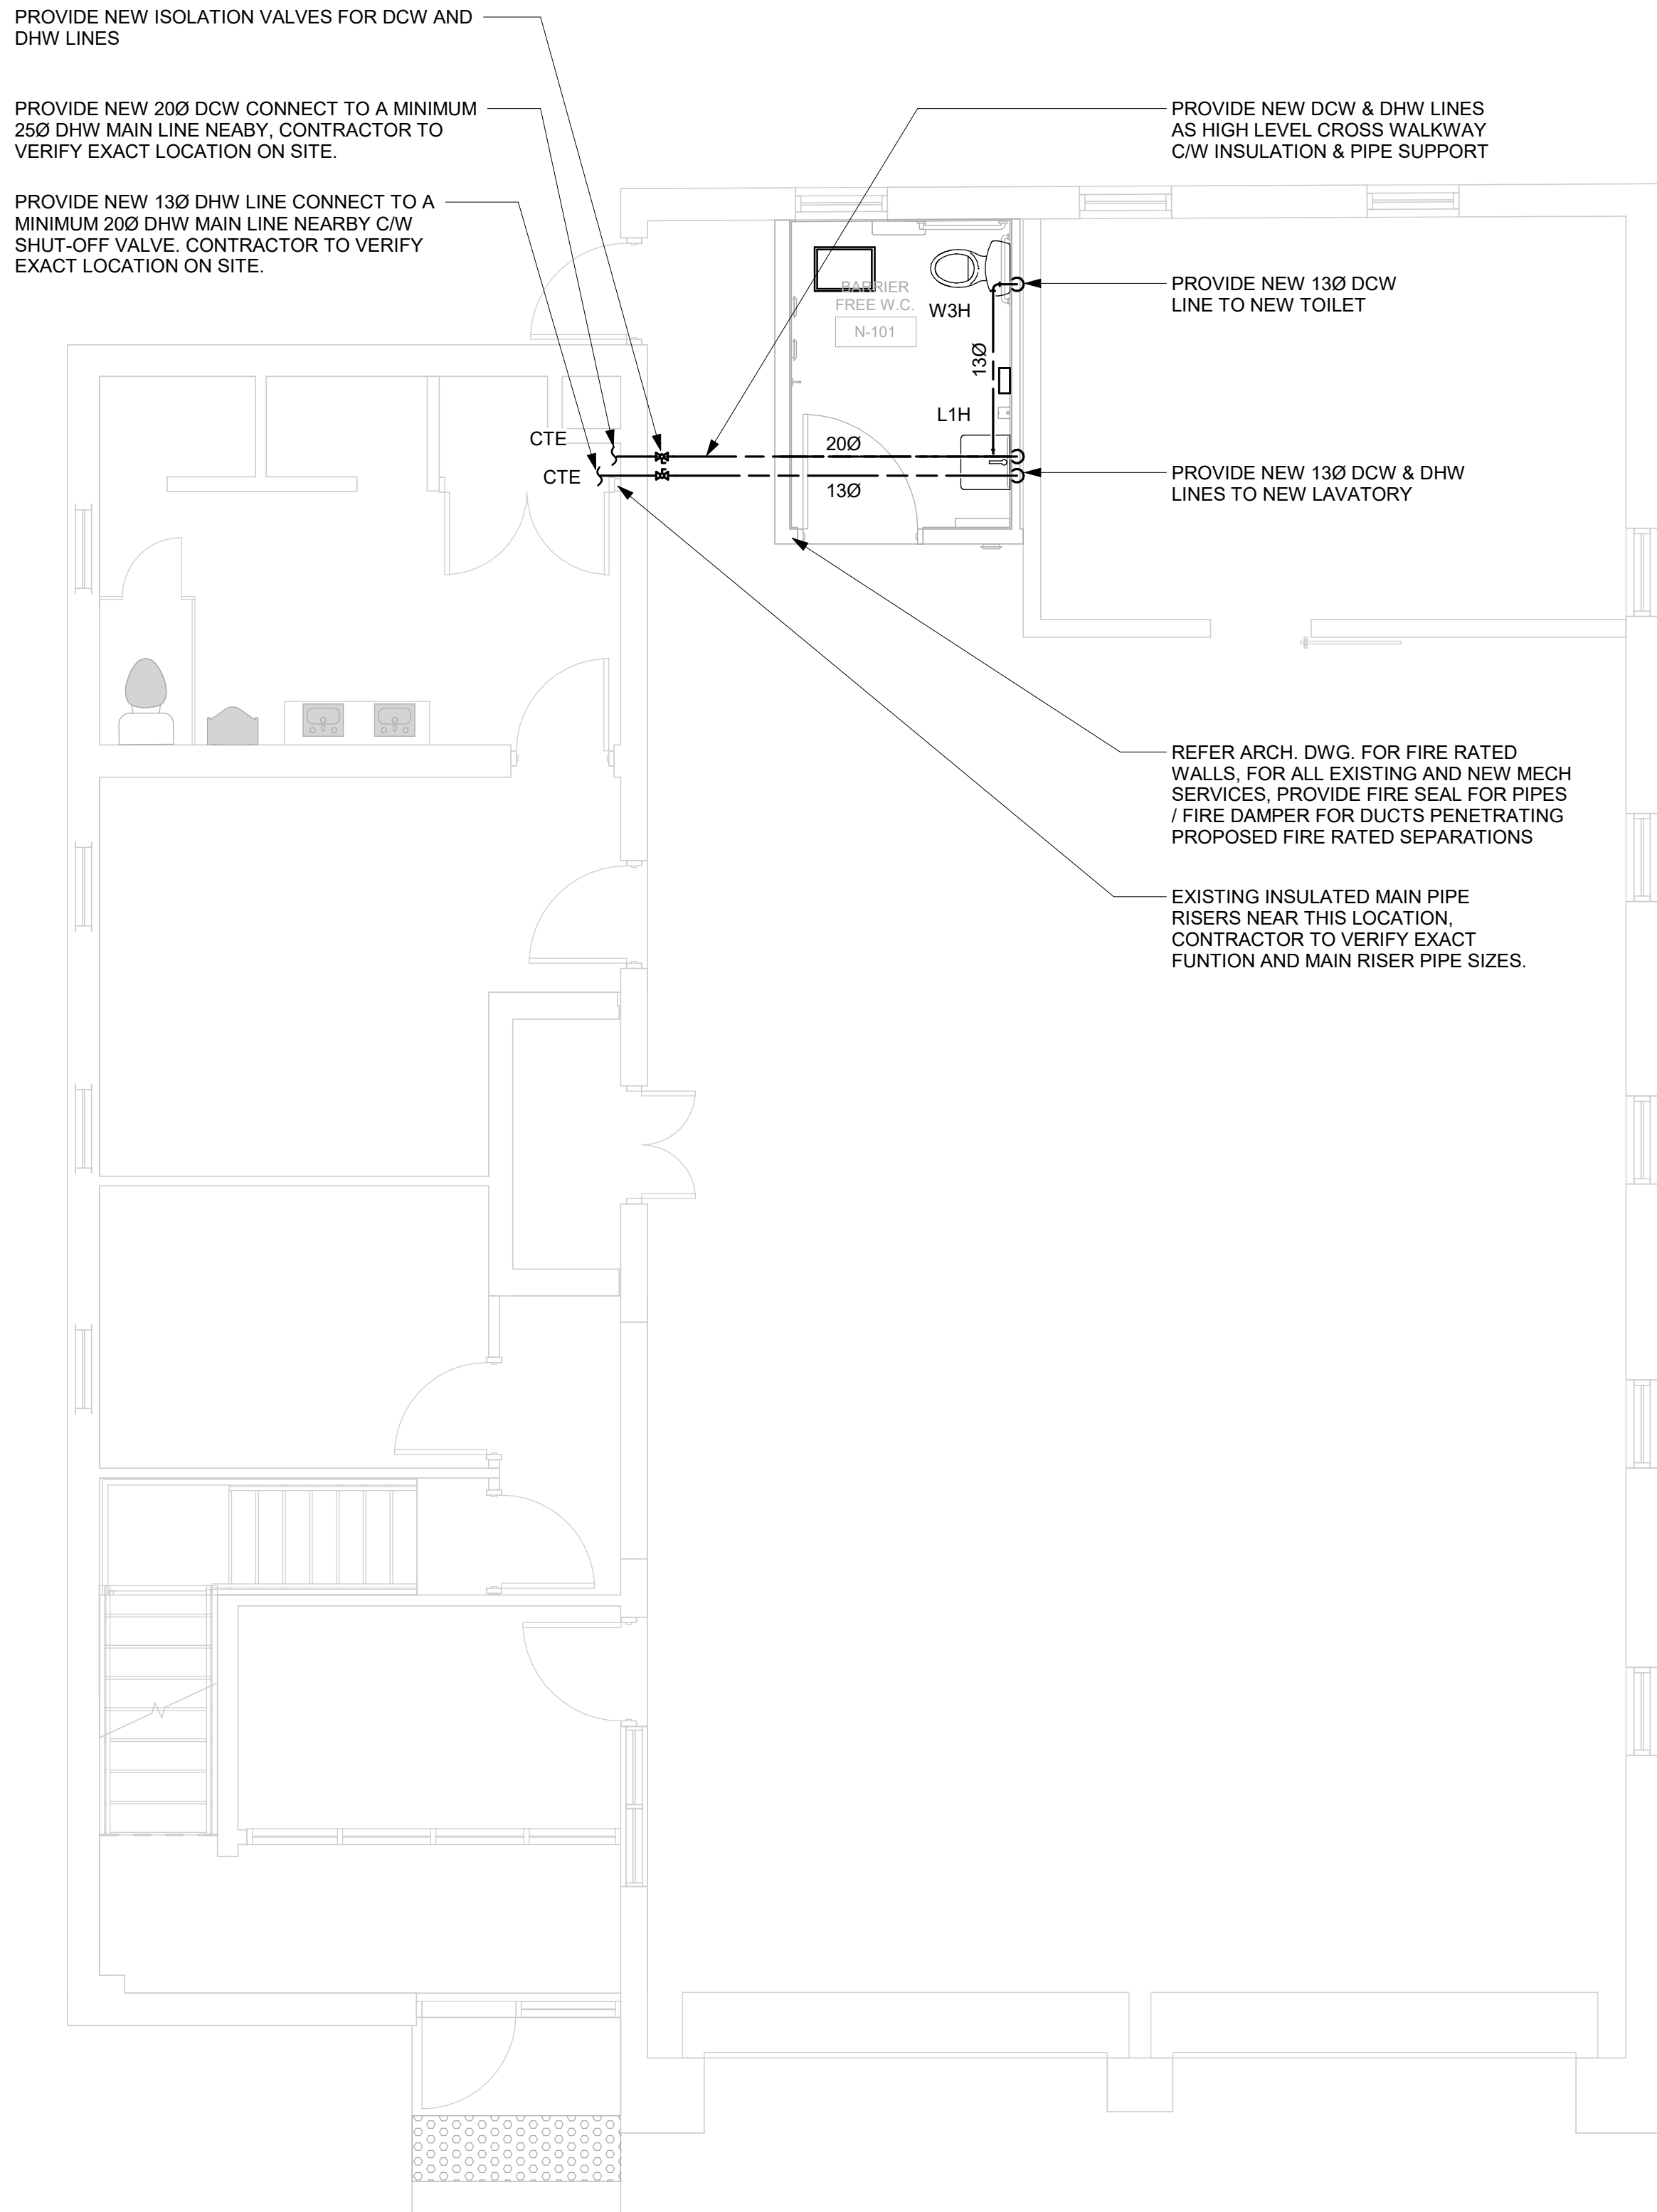


GENERAL NOTES:  
1. REFER TO SPECIFICATIONS FOR PLUMBING FIXTURE UNIT TYPES.  
2. ALL NEW FIXTURES TO BE FITTED WITH ISOLATION VALVES.

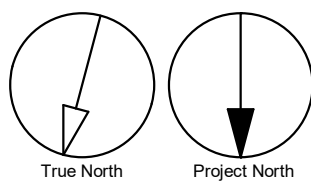

CLIENT

CITY OF TORONTO



Corporate Real Estate Management  
Project Management Office  
Metro Hall Toronto, ON  
MSV 3C6

COPYRIGHT

This drawing has been prepared solely for the intended use, thus any reproduction or distribution for any purpose other than authorized by IBI Group is forbidden. Written dimensions shall have precedence over scaled dimensions. Contractors shall verify and be responsible for all dimensions and conditions on the job, and IBI Group shall be informed of any variations from the dimensions and conditions shown on the drawing. Shop drawings shall be submitted to IBI Group for general conformance before proceeding with fabrication.


**IBI Group Professional Services (Canada) Inc.**  
is a member of the IBI Group of companies

ISSUES


No.	DESCRIPTION	DATE
00	ISSUED FOR CONSTRUCTION	2021-10-19

CONSULTANTS

SEAL



PRIME CONSULTANT



**IBI GROUP**  
175 Galaxy Blvd, Unit 100  
Toronto, ON M9W 0C9, Canada  
tel 416 679 1930 fax 416 675 4620  
ibigroup.com

PROJECT TITLE

CITY OF TORONTO  
ACCESSIBILITY UPGRADES

PROJECT ADDRESS

FIRE HALL NO. 143  
1009 SHEPPARD AVE  
WEST

PROJECT NO:  
91119- 19- 0162 / IBI 122260

DRAWN BY:  
**B.LIAO**

CHECKED BY:  
**S.LIU**

PROJECT MGR:  
**F. BOLOURIAN**

APPROVED BY:  
**B.LIAO**

SHEET TITLE

PLUMBING - GROUND  
FLOOR

SHEET NUMBER

ISSUE

G08-008-M2102

00

C:\Users\bingxi.liao\Documents\REV\T2020\122260-TAU-S-B-1008SHPRD-M-R20\_bingxi.liao.rvt

10mm

SCALE CHECK  
1 in



**CITY OF TORONTO**  
 **Toronto**  
Corporate Real Estate Management  
Project Management Office  
Metro Hall Toronto, ON  
M5V 3C6

**IBI Group Professional Services (Canada) Inc.**  
is a member of the IBI Group of companies

ISSUES		
No.	DESCRIPTION	DATE
00	ISSUED FOR CONSTRUCTION	2021-10-

IBI

**IBI GROUP**  
175 Galaxy Blvd, Unit 100  
Toronto, ON M9W 0C9, Canada  
tel 416 679 1930 fax 416 675 4620  
[ibigroup.com](http://ibigroup.com)


PROJECT ADDRESS  
FIRE HALL NO. 143  
1009 SHEPPARD AVE  
WEST

PROJECT NO:  
9119- 19- 0162 / IBI 122260


DRAWN BY: <b>K.DURUKAN</b>	CHECKED BY: <b>B.LIAO</b>
PROJECT MGR: <b>F. BOLOURIAN</b>	APPROVED BY: <b>S.LIU</b>

SHEET TITLE  
DRAINAGE - BASEMENT

SHEET NUMBER	ISSUE
G08-008-M3101	00

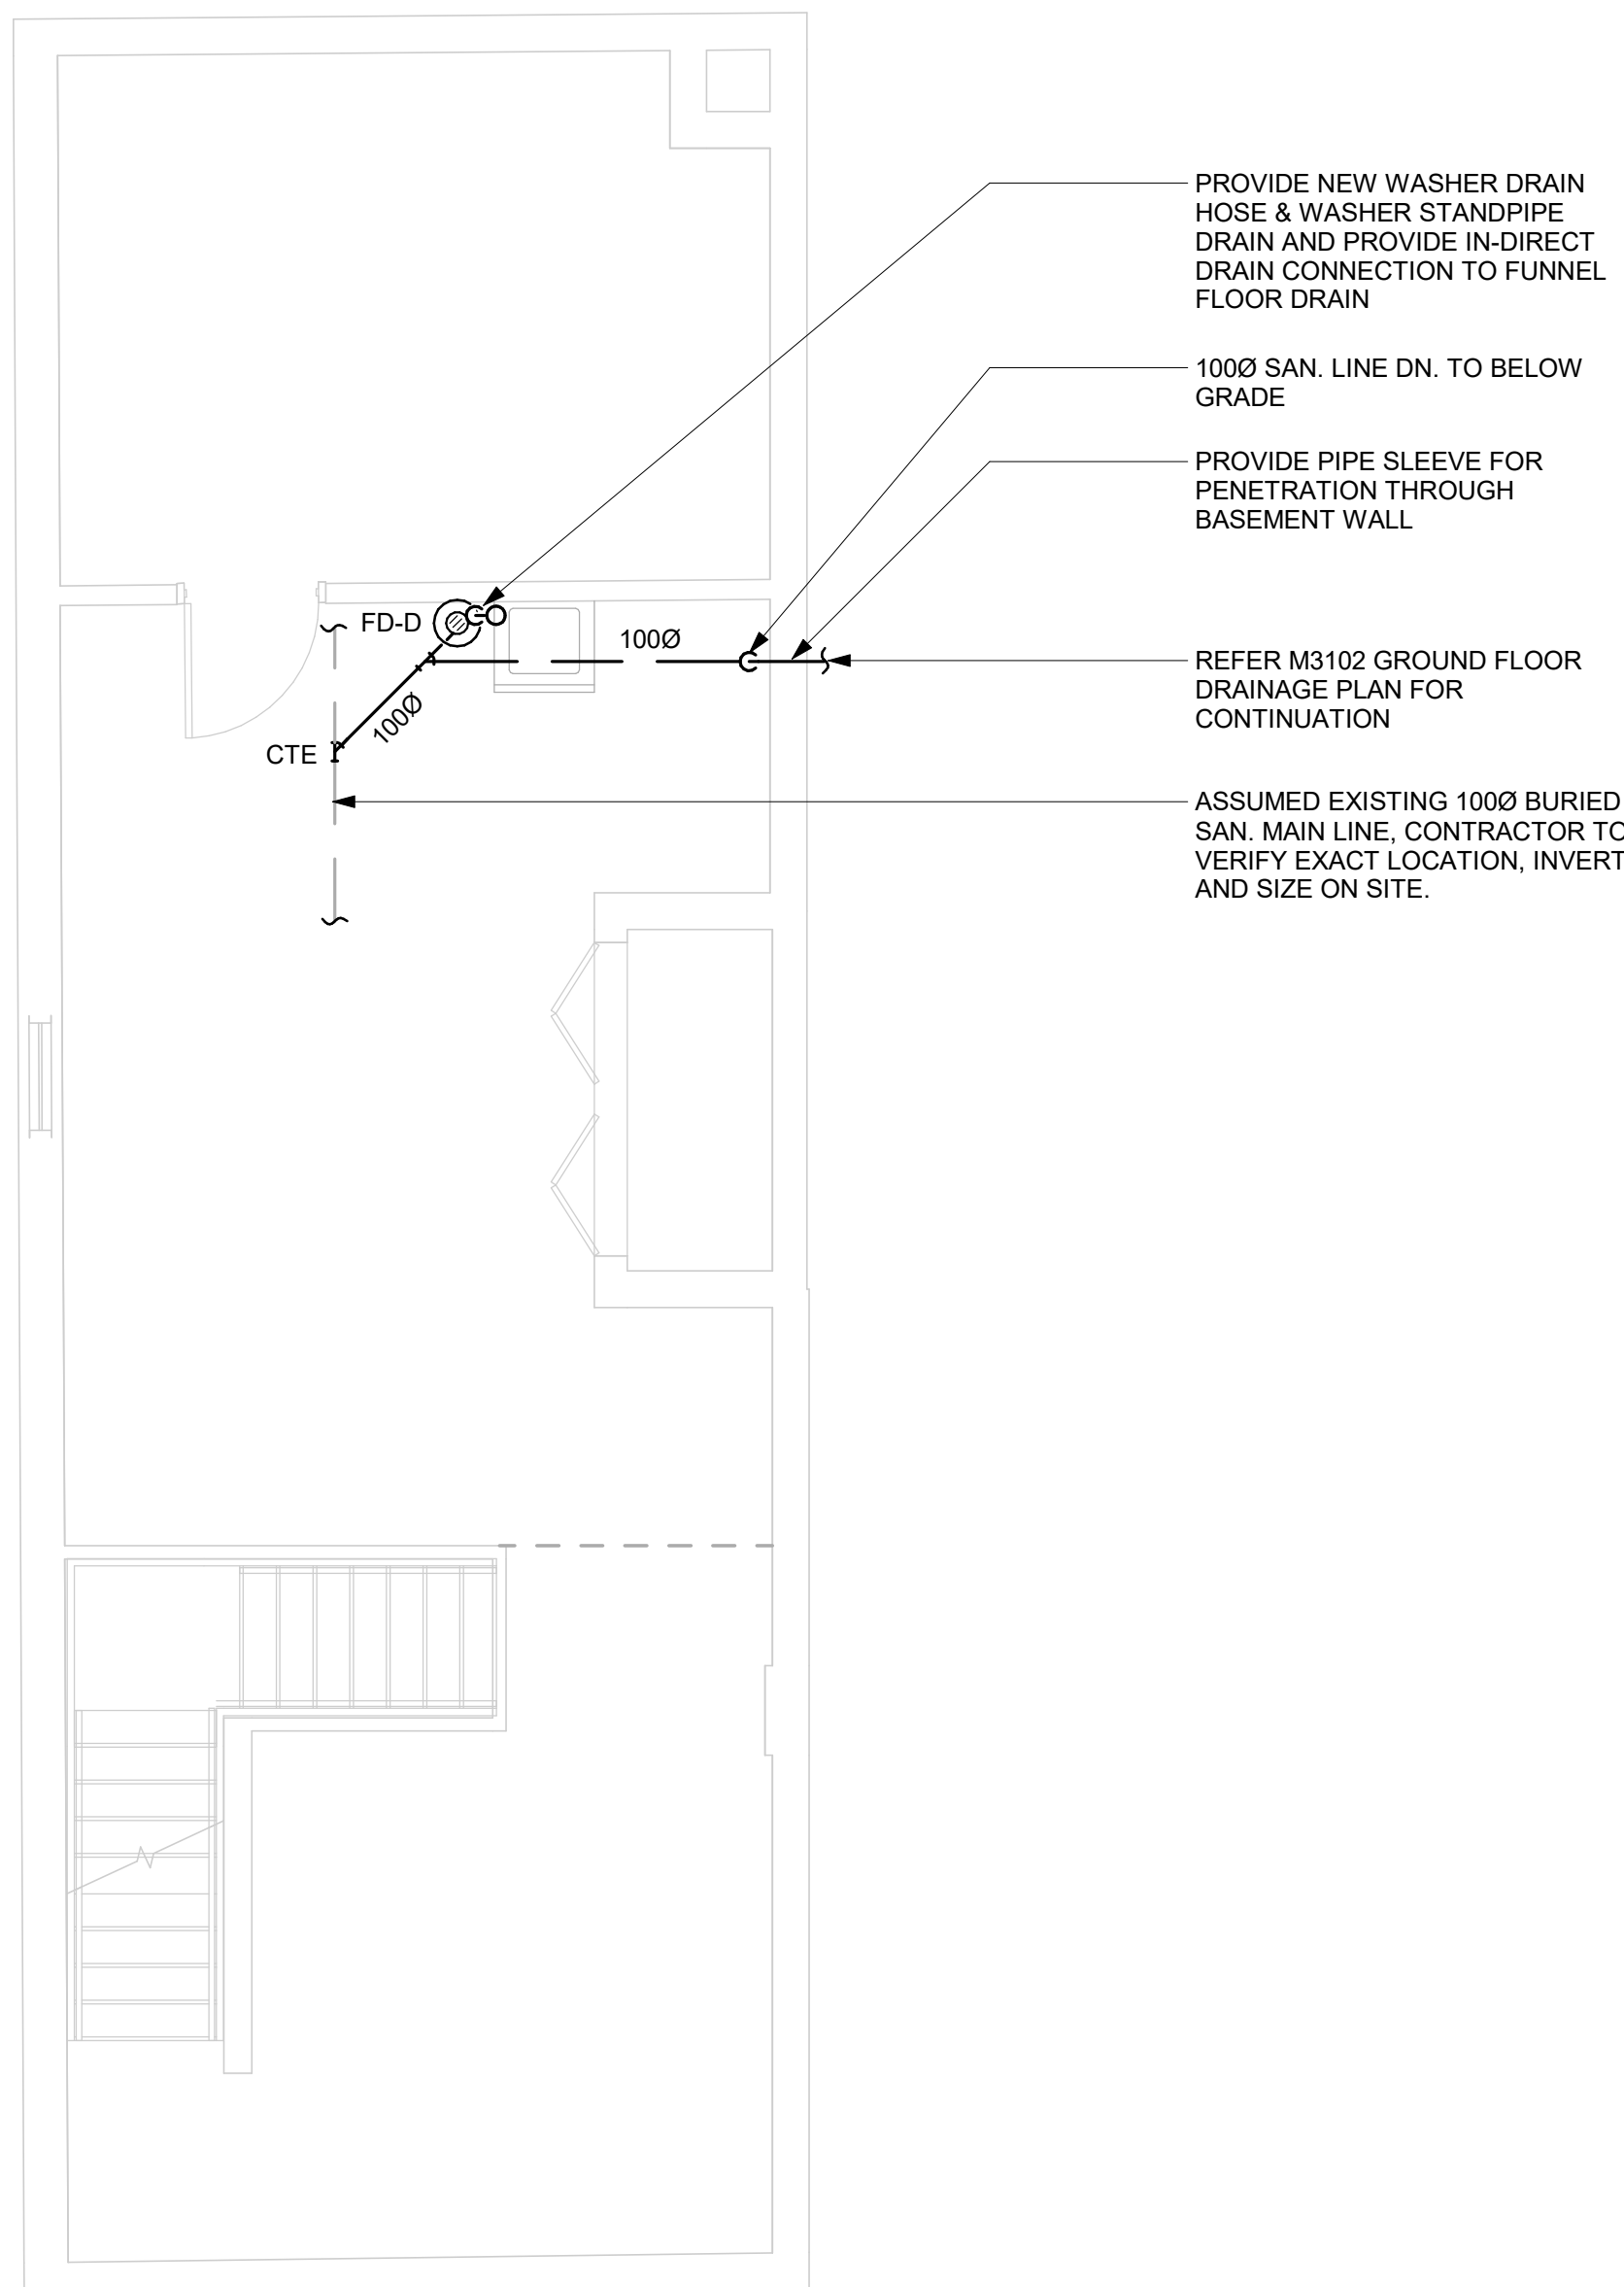

GENERAL NOTES:  
1. REFER TO SPECIFICATIONS FOR PLUMBING FIXTURE UNIT TYPES.  
2. PROVIDE SANITARY VENT FOR EACH NEW PLUMBING FIXTURE AND CONNECT TO EXISTING SANITARY VENT MAIN.  
3. PROVIDE P-TRAP FOR EACH PLUMBING FIXTURE AND FLOOR DRAIN AS PER OBC.  
4. PROVIDE FIRE STOP FOR ALL PIPE PENETRATIONS THROUGH FIRE SEPARATIONS.

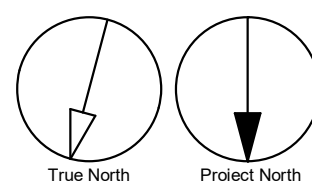

2021-10-19 9:16:25 AM

Scale 1:50


 


C:\Users\bingxi.liao\Documents\REVIT2020\122260-TAU-8-8-1009SHPRD-M-R20 bingxi.liao.rvt


10

SCALE CHECK

2021-10-19 9:16:25 AM

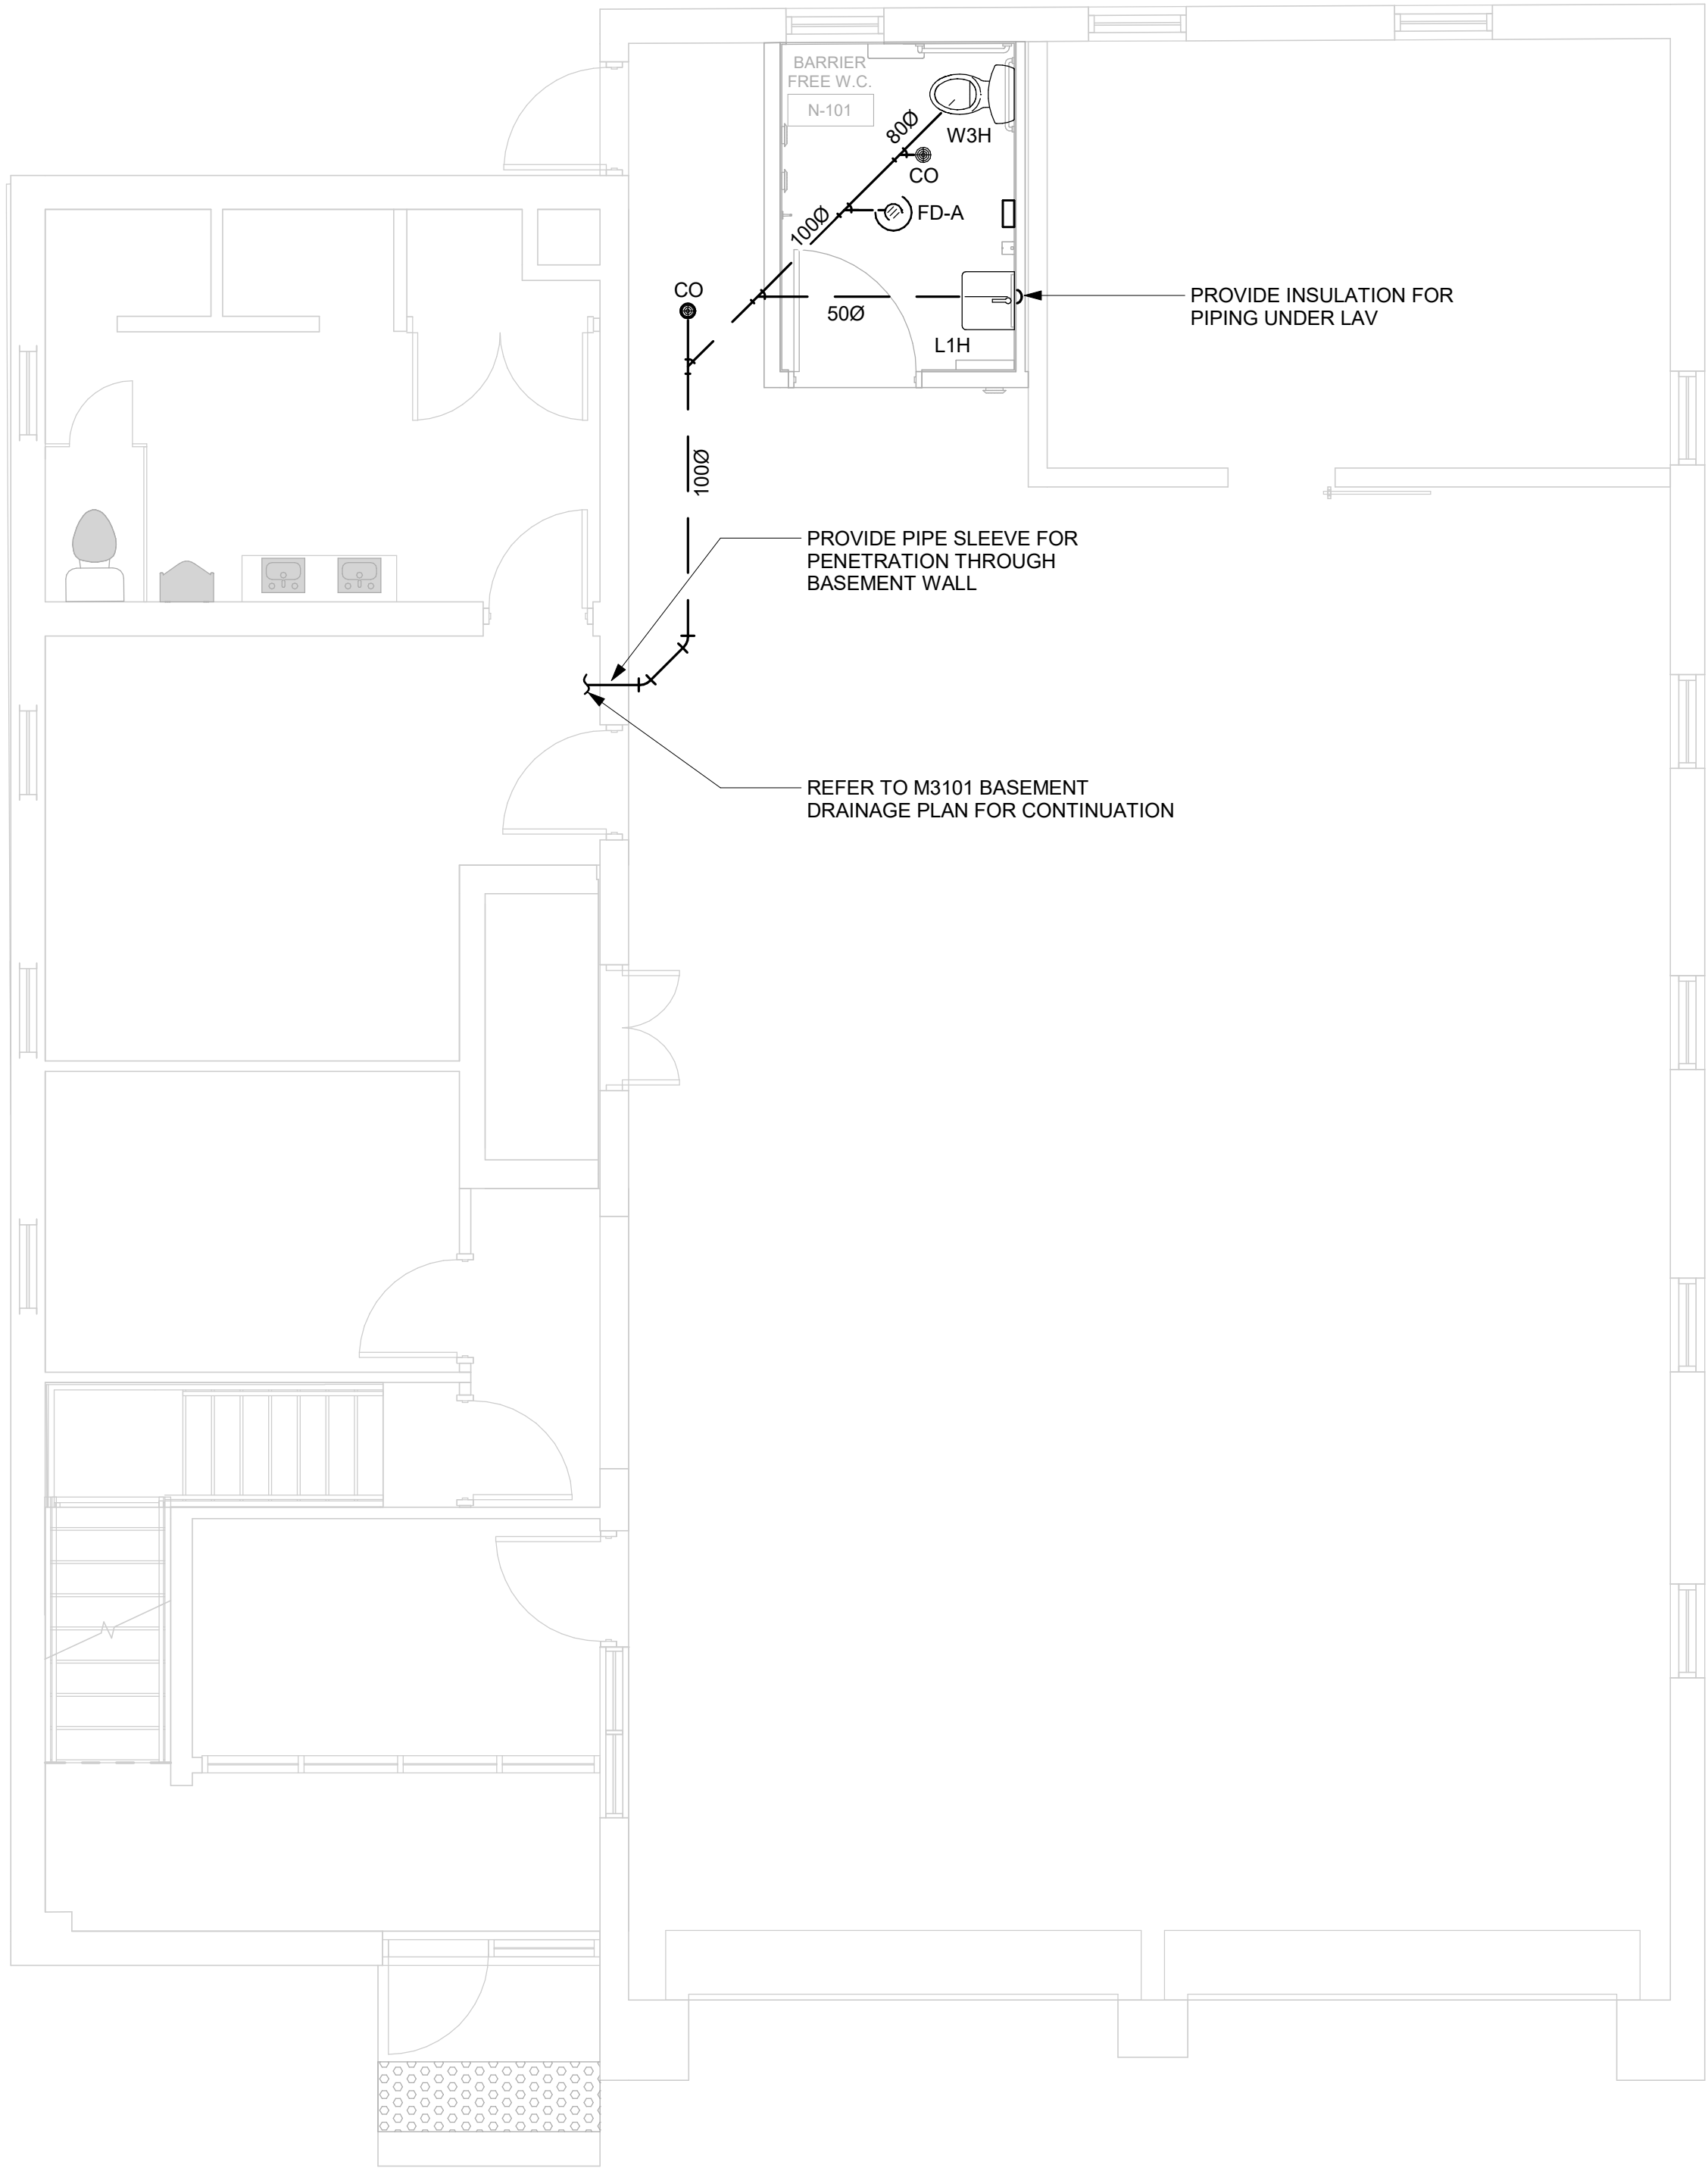

- GENERAL NOTES:
1. REFER TO SPECIFICATIONS FOR PLUMBING FIXTURE UNIT TYPES.
  2. PROVIDE SANITARY VENT FOR EACH NEW PLUMBING FIXTURE AND CONNECT TO EXISTING SANITARY VENT MAIN.
  3. PROVIDE P-TRAP FOR EACH PLUMBING FIXTURE AND FLOOR DRAIN AS PER OBC.
  4. PROVIDE FIRE STOP FOR ALL PIPE PENETRATIONS THROUGH FIRE SEPERATIONS.

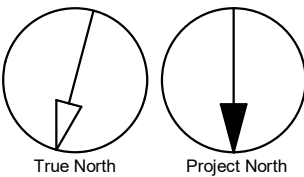

CLIENT

**CITY OF TORONTO**

  
Corporate Real Estate Management  
Project Management Office  
Metro Hall Toronto, ON  
MSV 3C6

**COPYRIGHT**  
This drawing has been prepared solely for the intended use, thus any reproduction or distribution for any purpose other than authorized by IBI Group is forbidden. Written dimensions shall have precedence over scaled dimensions. Contractors shall verify and be responsible for all dimensions and conditions on the job, and IBI Group shall be informed of any variations from the dimensions and conditions shown on the drawing. Shop drawings shall be submitted to IBI Group for general conformance before proceeding with fabrication.

**IBI Group Professional Services (Canada) Inc.**  
is a member of the IBI Group of companies

ISSUES		
No.	DESCRIPTION	DATE
00	ISSUED FOR CONSTRUCTION	2021-10-19

CONSULTANTS

SEAL



PRIME CONSULTANT

 **IBI GROUP**  
175 Galaxy Blvd, Unit 100  
Toronto, ON M9W 0C9, Canada  
tel 416 679 1930 fax 416 675 4620  
ibigroup.com

PROJECT TITLE  
**CITY OF TORONTO  
ACCESSIBILITY UPGRADES**

PROJECT ADDRESS  
**FIRE HALL NO. 143  
1009 SHEPPARD AVE  
WEST**

PROJECT NO:  
9119- 19- 0162 / IBI 122260

DRAWN BY: <b>B.LIAO</b>	CHECKED BY: <b>S.LIU</b>
----------------------------	-----------------------------

PROJECT MGR: <b>F. BOLOURIAN</b>	APPROVED BY: <b>B.LIAO</b>
-------------------------------------	-------------------------------

SHEET TITLE  
**DRAINAGE - GROUND  
FLOOR**


 
SHEET NUMBER <b>G08-008-M3102</b>	ISSUE <b>00</b>
--------------------------------------	--------------------

C:\Users\bingxi.liao\Documents\REV\T2020\122260-TAU-S-S-1008SHPRD-M-R20\_bingxi.liao.rvt


10mm

SCALE CHECK  
1 m

2021-10-19 9:16:25 AM

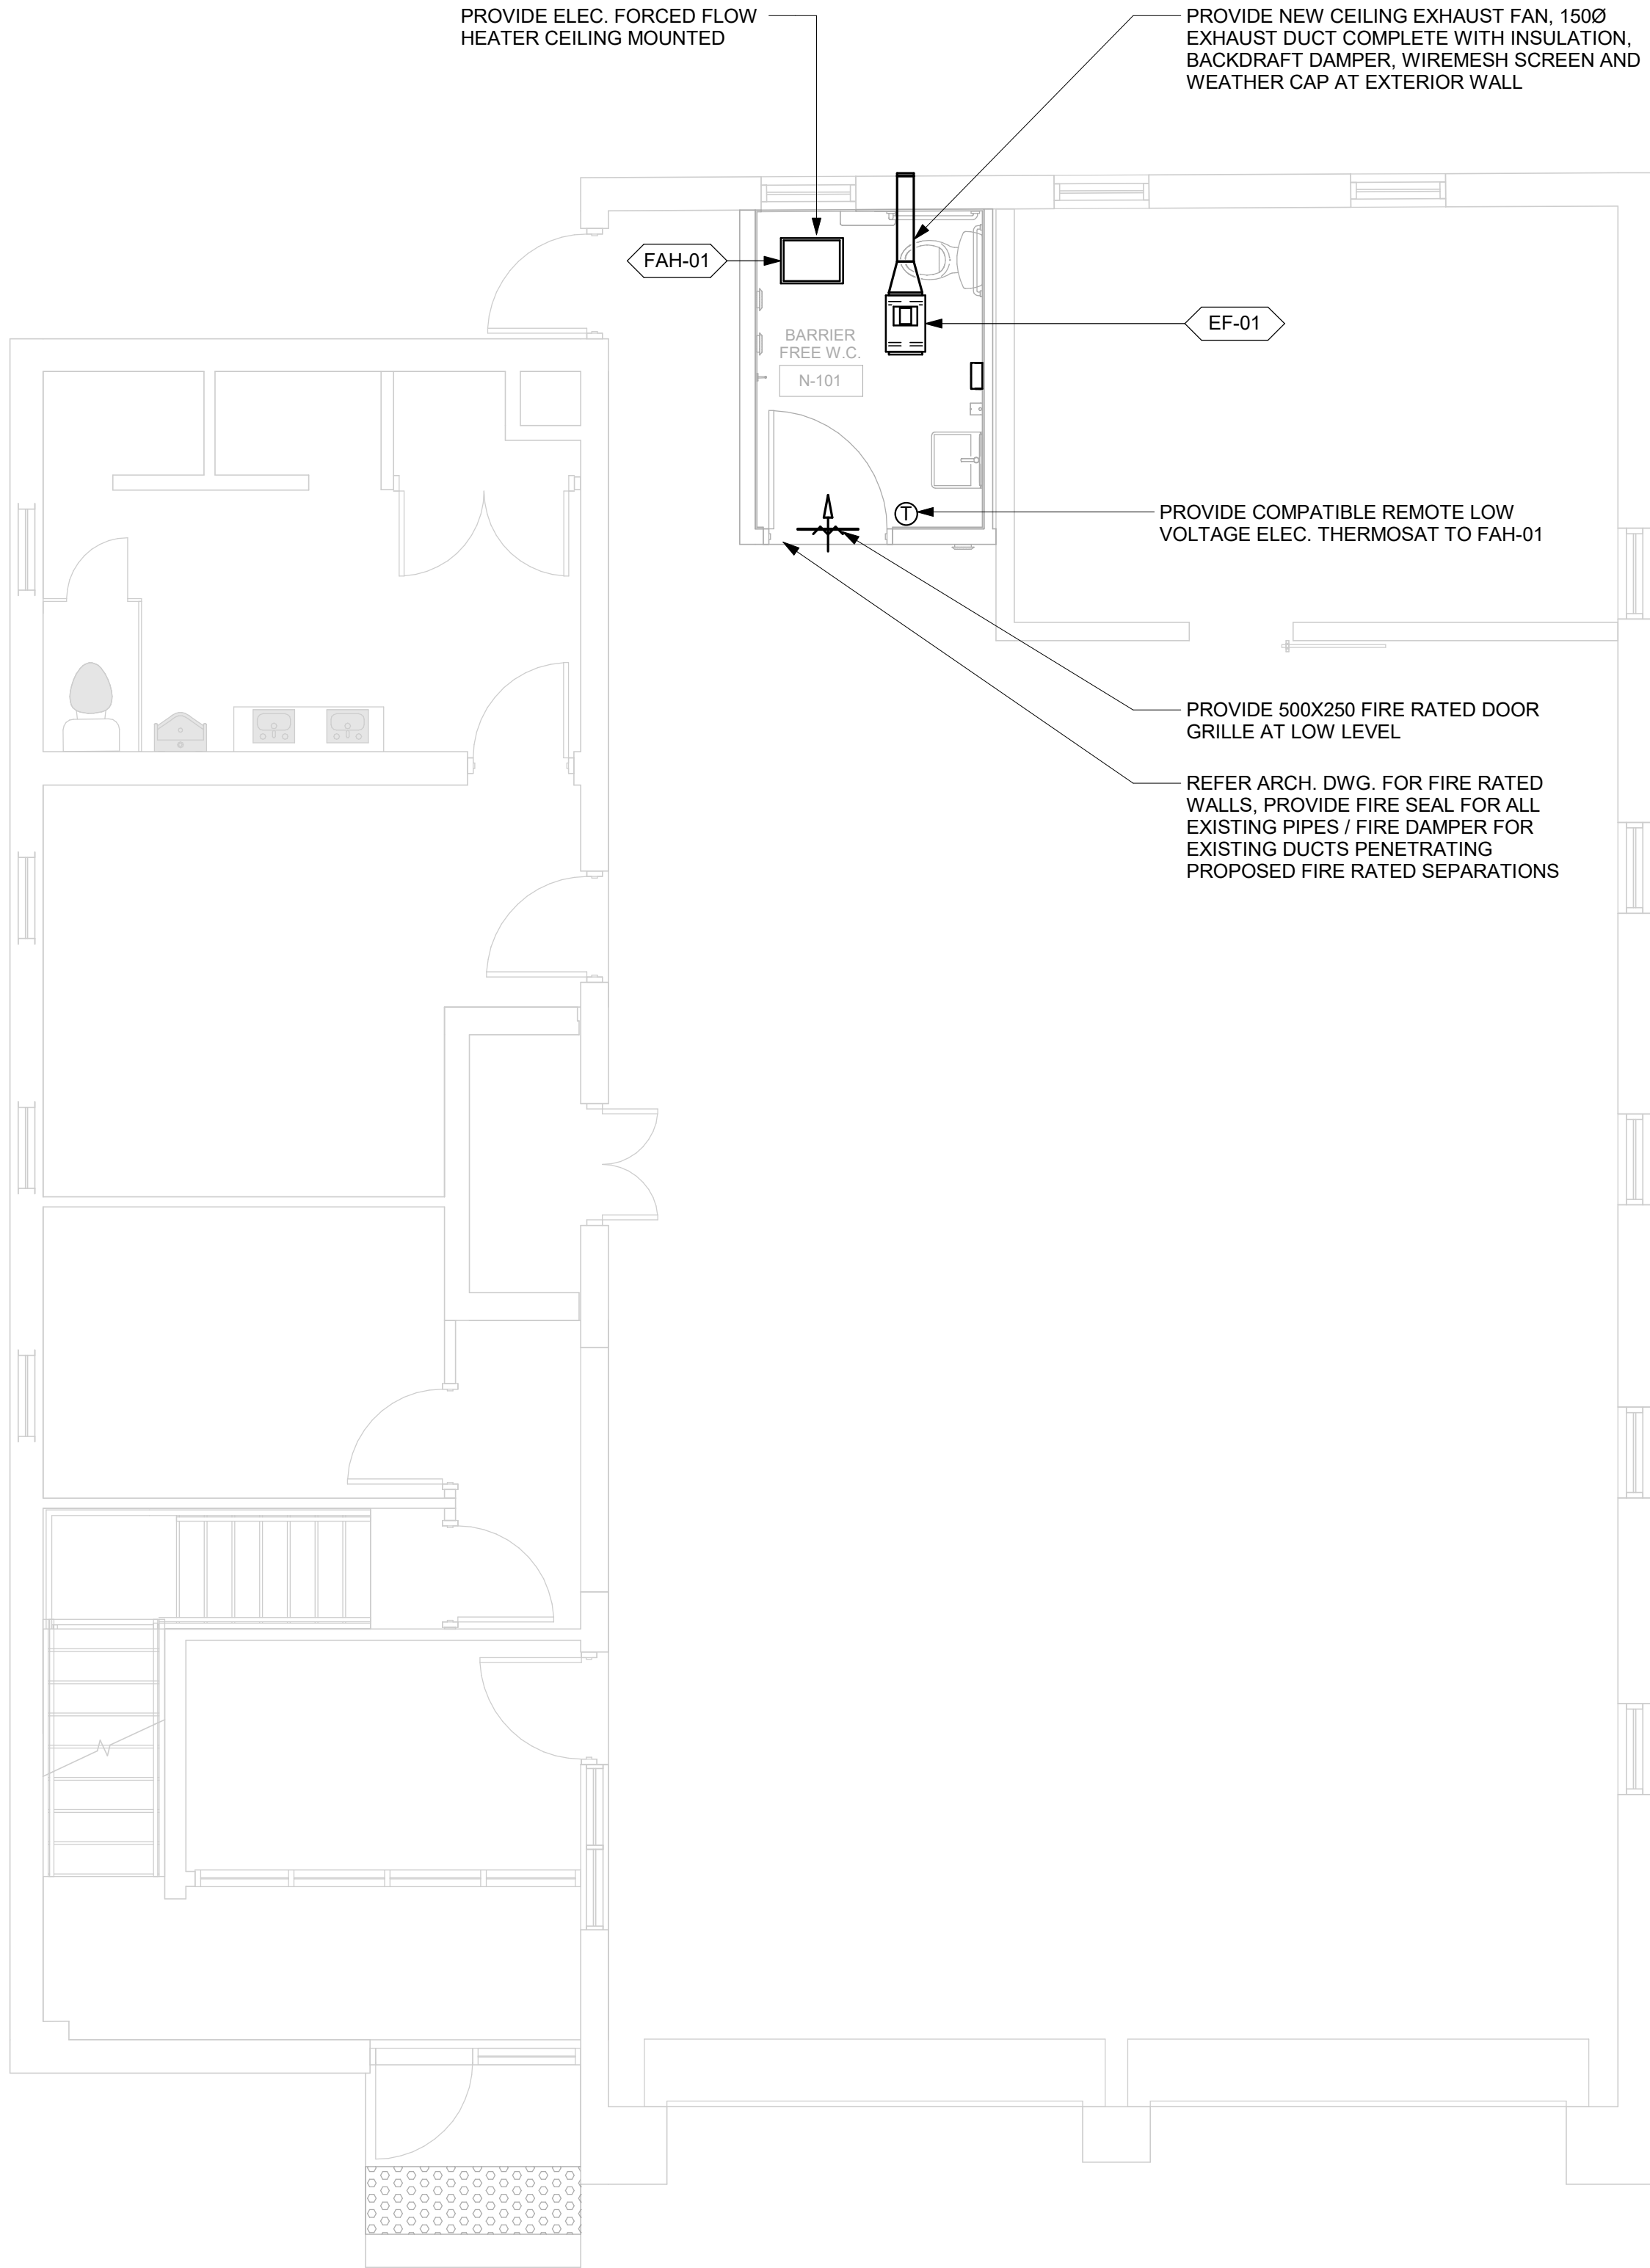

- GENERAL NOTES:
1. ADD AND ADJUST DUCTS TO FIT NEW DIFFUSERS/GRILLES.
  2. THERMOSTATS TO BE MOUNTED AT 1200mm A.F.F.

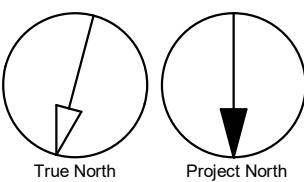

CLIENT

**CITY OF TORONTO**


Corporate Real Estate Management  
Project Management Office  
Metro Hall Toronto, ON  
MSV 3C6

**COPYRIGHT**  
This drawing has been prepared solely for the intended use, thus any reproduction or distribution for any purpose other than authorized by IBI Group is forbidden. Written dimensions shall have precedence over scaled dimensions. Contractors shall verify and be responsible for all dimensions and conditions on the job, and IBI Group shall be informed of any variations from the dimensions and conditions shown on the drawing. Shop drawings shall be submitted to IBI Group for general conformance before proceeding with fabrication.

**IBI Group Professional Services (Canada) Inc.**  
is a member of the IBI Group of companies

ISSUES		
No.	DESCRIPTION	DATE
00	ISSUED FOR CONSTRUCTION	2021-10-19

CONSULTANTS

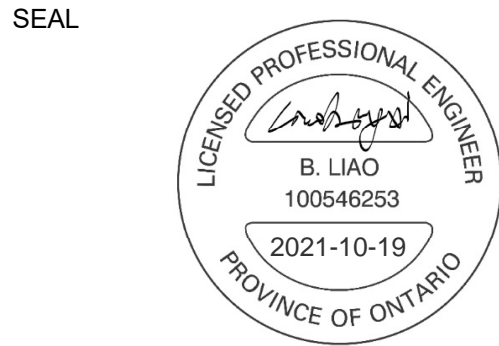

PRIME CONSULTANT

**IBI GROUP**  
175 Galaxy Blvd, Unit 100  
Toronto, ON M9W 0C9, Canada  
tel 416 679 1930 fax 416 675 4620  
ibigroup.com

PROJECT TITLE

**CITY OF TORONTO  
ACCESSIBILITY UPGRADES**

PROJECT ADDRESS

**FIRE HALL NO. 143  
1009 SHEPPARD AVE  
WEST**

PROJECT NO: 9119- 19- 0162 / IBI 122260	
DRAWN BY: <b>K.DURUKAN</b>	CHECKED BY: <b>B.LIAO</b>
PROJECT MGR: <b>F. BOLOURIAN</b>	APPROVED BY: <b>S.LIU</b>

SHEET TITLE

**HVAC - GROUND FLOOR**

SHEET NUMBER	ISSUE
<b>G08-008-M5101</b>	<b>00</b>

C:\Users\bingxi.liao\Documents\REV\T2020\122260-TAU-S-5-1008SHPRD-M-R20\_bingxi.liao.rvt

10mm

SCALE CHECK  
1 in