

DRAWING NOTES:

- 1 UV LIGHTS ARE TO BE TURNED OFF UPON DOOR OPENING AND OCCUPANCY SENSOR SIGNAL. PROVIDE WIRING AND RELAYS REQUIRED. REFER TO DETAIL #2 ON SHEET FOR UV LIGHTING WIRING DETAILS. OCCUPANCY SENSOR TO COME INTEGRATED WITH UV LIGHT. TYPICAL FOR ALL ROOMS.
- 2 PROVIDE NEW 15A-1P BREAKER WITHIN EACH EN-SUITE ELECTRICAL PANEL. EXISTING PANEL IS CEB LIMITED NO. NHP 8-635-2. PROVIDE BX CONDUIT AND WIRING TO SUIT. TYPICAL ALL ROOMS.
- 3 REMOVE EXISTING LIGHT FIXTURES AND WIRING WITHIN THE EXISTING ROOM (LEVEL 6 ONLY). CUT BACK ALL WIRING TO EXISTING FUSE OR MINI BREAKER WITHIN THE ENSUITE PANEL. SALVAGE LIGHT FIXTURES IF REQUESTED BY OWNER.
- 4 PROVIDE NEW 15-1P BREAKER WITHIN PANEL A LOCATED ONE LEVEL DIRECTLY ABOVE THIS LEVEL. COORDINATE WITH MECHANICAL CONTRACTOR ON LOCATION OF DUCT MOUNTED UV LIGHT WITHIN THE AHU. PROVIDE CONDUIT AND WIRING TO SUIT.

1 LEVEL 5/6 - ELECTRICAL LAYOUT  
E10 1:200

ELECTRICAL LEGEND

| LIGHTING |                                            |
|----------|--------------------------------------------|
|          | CEILING MOUNTED LED DOWNLIGHT. TYPE NOTED. |
|          | 4" WALL MOUNTED UV-C LIGHT. TYPE AS NOTED. |
|          | 2" LED VANITY LIGHT. TYPE AS NOTED.        |
| POWER    |                                            |
|          | EXISTING RECESSED ENSUITE PANEL.           |
|          | 15/20A GFCI RECEPTACLE                     |


DRAWING LIST

| DWG NO. | DRAWING TITLE                                          |
|---------|--------------------------------------------------------|
| E10     | ELECTRICAL LEGEND, DRAWING LIST, DETAIL AND NEW LAYOUT |


GENERAL NOTES:

- IT IS THE CONTRACTOR'S RESPONSIBILITY TO COORDINATE WORK WITH OTHER TRADES PRIOR TO THE ROUGH IN OF ANY DEVICE INCLUDING COORDINATION WITH FURNITURE AND EQUIPMENT. CLAIMS FOR EXTRAS WILL NOT BE ACCEPTED FOR ITEMS OF INSTALLED WORK (NEW OR EXISTING) THAT CONFLICT WITH THE WORK OF OTHER TRADES DUE TO LACK OF COORDINATION.
- PROVIDE WIRING AND CONDUIT TO ALL DOOR HARDWARE DEVICES SHOWN ON DRAWINGS AND AS PER SPECIFICATIONS. COORDINATE WITH DOOR HARDWARE SUPPLIER FOR INSTALLATION REQUIREMENTS.
- CONTRACTOR IS TO FOLLOW ALL CONSTRUCTION PROCEDURES AS SET OUT BY THE FACILITY.
- ALL CONTRACT DRAWINGS SHALL BE READ IN CONJUNCTION WITH ALL OTHER DRAWINGS AND SPECIFICATIONS. ANY DISCREPANCY BETWEEN ANY ONE OR MORE OF THE DOCUMENTS SHALL BE IMMEDIATELY BROUGHT TO THE ATTENTION FOR CLARIFICATION. THE CONTRACTOR SHALL PROCEED WITH WORK KNOWINGLY INCORRECT AT HIS OWN RISK.
- IT IS THE INTENT OF THE CONTRACT DOCUMENTS, INCLUDING THE SPECIFICATIONS AND DRAWINGS, TO PROVIDE FINISHED WORK, TESTED AND READY FOR OPERATION AND COMPLETE IN EVERY REGARD. PROVIDE WORK NOT SHOWN OR SPECIFIED AND ACCESSORIES NECESSARY TO MAKE THE WORK COMPLETE AND READY FOR OPERATION. SHOULD THERE APPEAR TO BE DISCREPANCIES OR QUESTIONS OF INTENT IN THE CONTRACT DOCUMENTS, REFER THE MATTER TO THE CONSULTANT FOR REVIEW.
- IN THE EVENT OF AN EXPRESS CONFLICT BETWEEN ANY ITEM CONTAINED WITH-IN THE CONTRACT DOCUMENTS, THE MOST STRINGENT AND COSTLY ITEM TO THE CONTRACTOR SHALL APPLY AT NO EXTRA COST TO THE CONTRACT PROVIDED HOWEVER, THE CONSULTANT MAY, AT OWNER'S SOLE DISCRETION, ELECT A LESS STRINGENT OR COSTLY RESOLUTION OF THE CONFLICT. THE CONTRACTOR SHALL NOTIFY THE CONSULTANT IMMEDIATELY OF ANY SUCH CONFLICTS.
- ALL CONTRACT DRAWINGS SHALL BE READ IN CONJUNCTION WITH ALL OTHER DRAWINGS AND SPECIFICATIONS BY OTHER DIVISIONS. ANY DISCREPANCIES BETWEEN ANY ONE OR MORE OF THE DOCUMENTS SHALL BE IMMEDIATELY BROUGHT TO THE ATTENTION OF THE CONSULTANTS FOR CLARIFICATION. ELECTRICAL CONTRACTOR SHALL ENSURE THAT A COMPLETE SET OF DRAWINGS IS OBTAINED FROM THE GENERAL CONTRACTOR INCLUDING ALL SUBTRADES. THE ELECTRICAL CONTRACTOR IS RESPONSIBLE FOR REVIEWING THE COMPLETE BID PACKAGE TO UNDERSTAND THEIR RESPECTIVE SCOPE OF WORK AND ALL RELATED SCOPES OF WORK.
- COORDINATE WITH ARCHITECTURAL DRAWINGS AND SPECIFICATIONS FOR PHASING PLANS AND REQUIREMENTS INCLUDING SCHEDULE AND ORDER OF WORK.
- ALL CORE DRILLING IS TO BE PERFORMED OFF HOURS AT A TIME CONVENIENT TO THE OWNER.
- CONTRACTOR SHALL MAKE GOOD ANY CEILINGS OR WALLS THAT ARE DAMAGED DURING CONSTRUCTION AS A RESULT OF ELECTRICAL WORKS.
- CIRCUITING IS DIAGRAMMATIC ONLY. CONTRACTOR TO CIRCUIT TO NEXT AVAILABLE CIRCUIT. CONTRACTOR TO UPDATE PANEL SCHEDULES.

2 WIRING SCHEMATIC FOR UV LUMINAIRE  
E10 N.T.S.

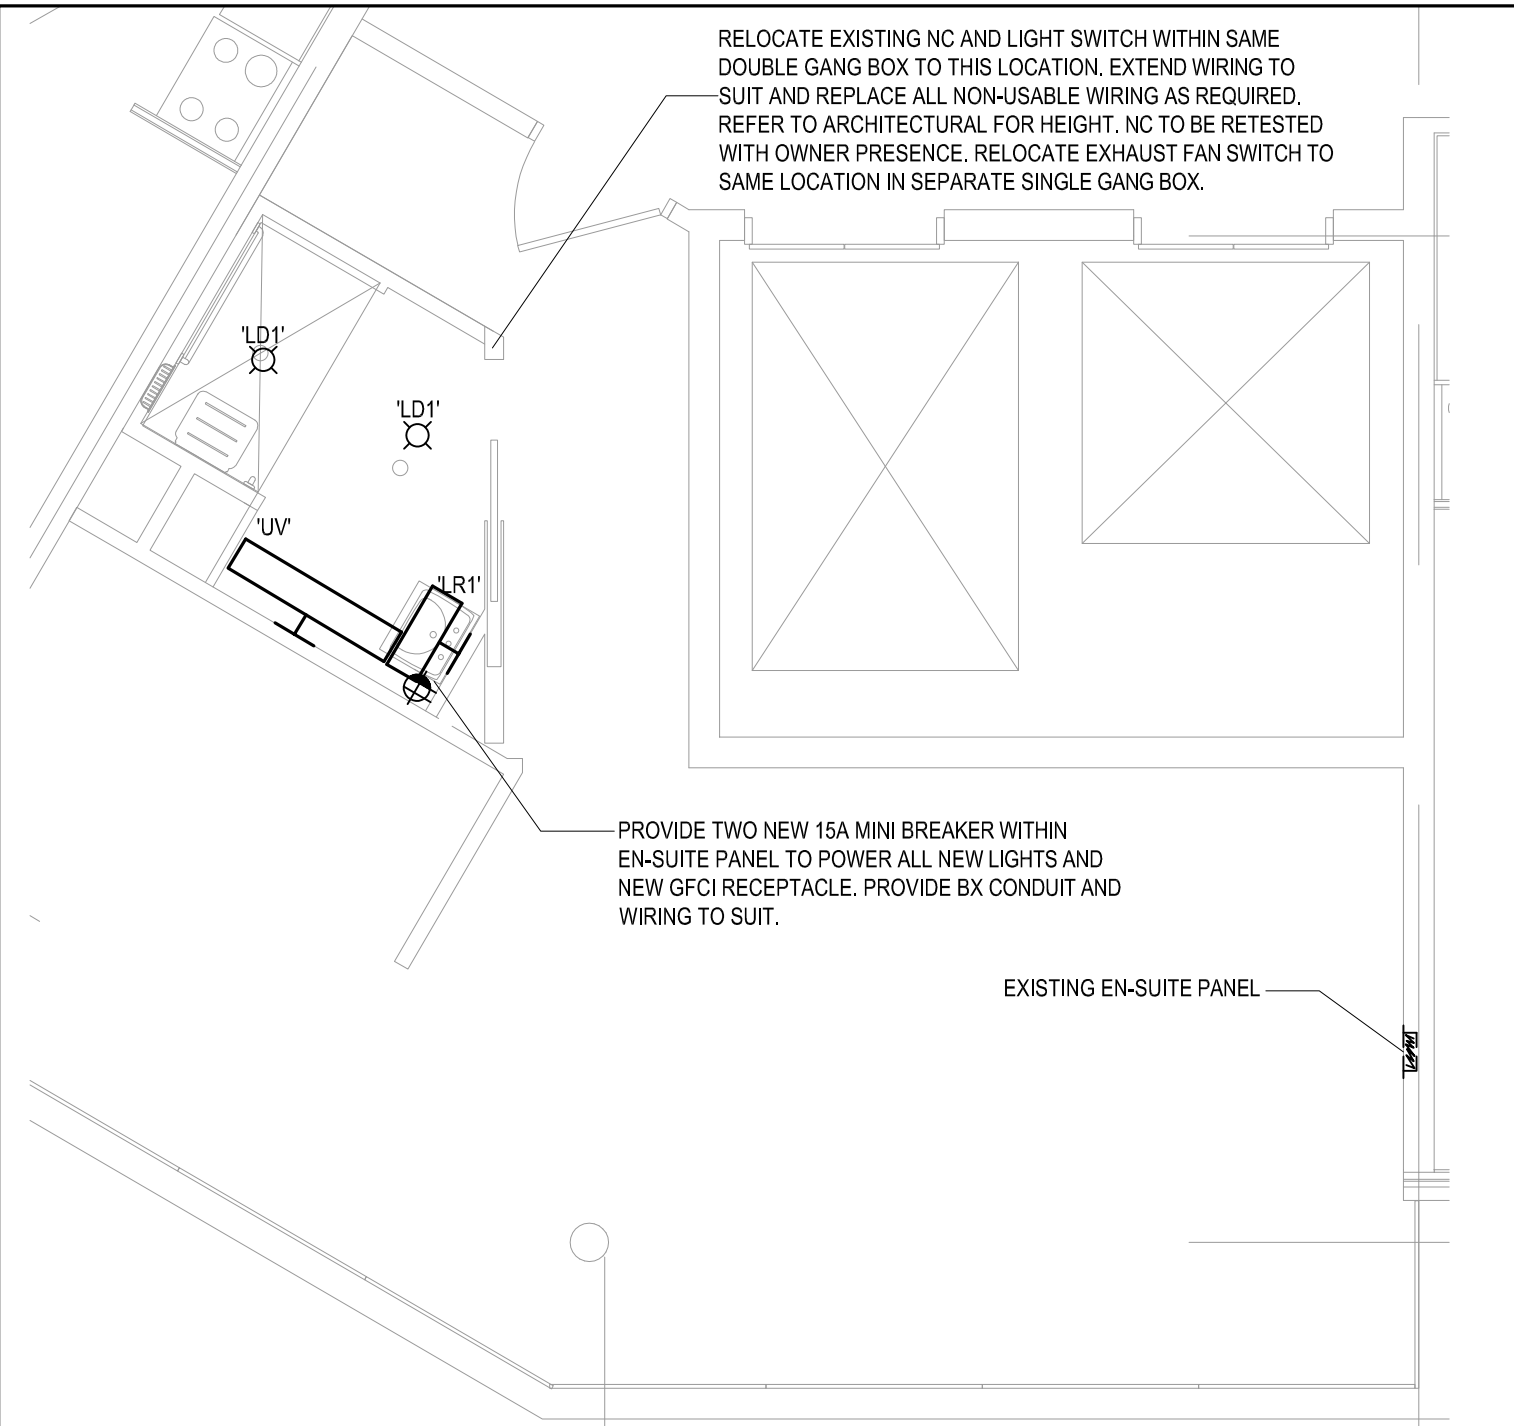

3 NEW LEVEL 6 SHOWER ROOM  
E10 1:50

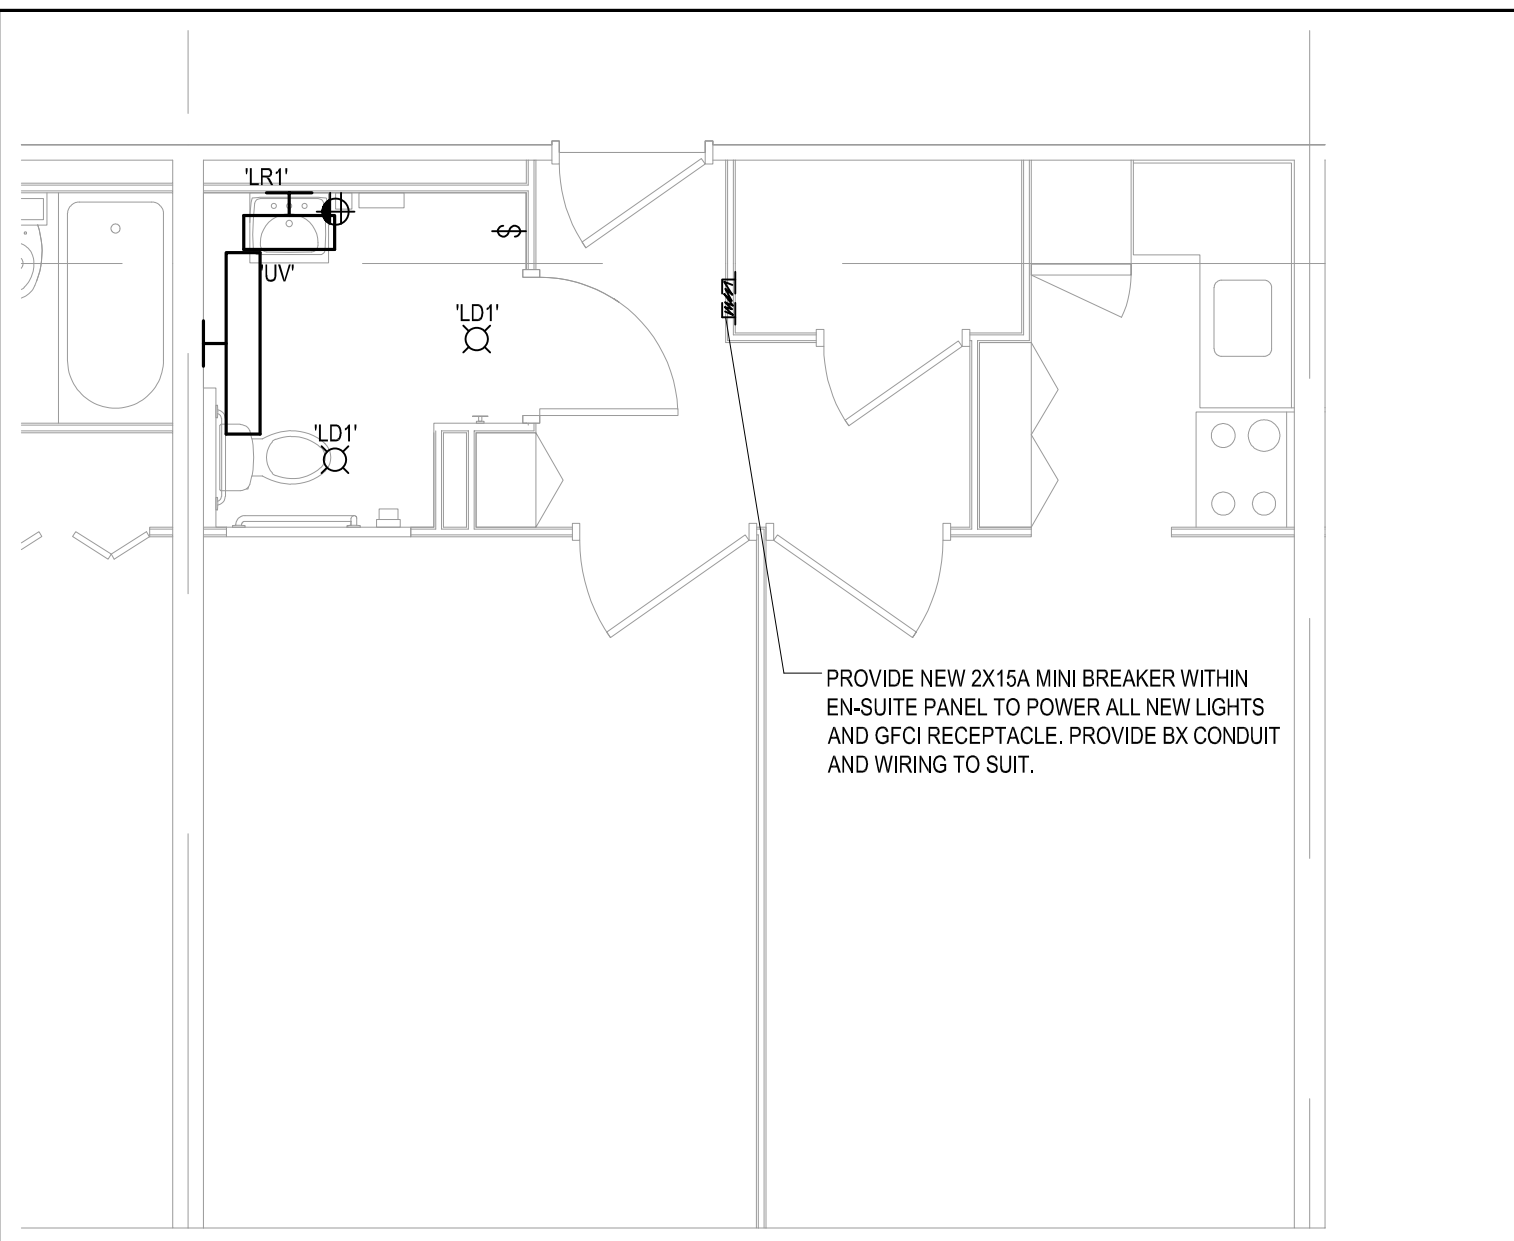

4 NEW LEVEL 6 BF WASHROOM  
E10 1:50

This drawing is the property of the Architect and unauthorized reproduction is prohibited under the copyright act.  
Electronic files, when provided, are instruments of service and the sole property of Hanson + Jung Architects Inc.. No alteration or reproduction shall be made without written permission from Hanson + Jung Architects Inc.  
The Contractor shall check and verify all dimensions and report any discrepancies to the Architect prior to construction; do not scale this drawing.  
This drawing shall not be used for construction purposes unless properly signed and sealed by the Architect.

| 8  |                                             |            |
|----|---------------------------------------------|------------|
| 7  |                                             |            |
| 6  |                                             |            |
| 5  |                                             |            |
| 4  |                                             |            |
| 3  |                                             |            |
| 2  |                                             |            |
| 1  | ISSUED FOR TENDER & BLDG PERMIT APPLICATION | 2026-08-05 |
| NO | ACTION                                      | DATE       |

Client:

St. Joseph's Health Centre  
Unity Health Toronto

Project Title:

CEDARBROOK LODGE  
PROPOSED MODIFICATIONS  
5TH AND AND 6TH FLOOR

Sheet Title:

ELECTRICAL LEGEND, DRAWING LIST,  
DETAIL AND NEW LAYOUT

|                     |                       |
|---------------------|-----------------------|
| Project North       | Stamp                 |
|                     |                       |
| Date:<br>2026-06-22 | Project No.:<br>26-10 |
| Scale:<br>AS NOTED  | Drawn:<br>MDP         |
|                     | Checked:<br>JV        |
| Drawing Number:     |                       |

E10