 
 





5
TC-0.1

GENERAL NOTES


- REFER TO ARCHITECTURAL PLANS FOR DIMENSIONS, HEIGHTS, PARTITION TYPES, CEILING TYPES, CONSTRUCTION DETAILING, MOUNTING DETAILS, FINISHES, AND COLOURS.
- WHILE EVERY ATTEMPT HAS BEEN MADE TO ENSURE ALL INFORMATION IS CORRECT AT THE TIME OF PUBLICATION, THE PRODUCTS SPECIFIED ARE AVAILABLE AND THAT THE PART NUMBER IDENTIFIED ARE CORRECT, IT IS THE RESPONSIBILITY OF THE COMMUNICATIONS CONTRACTOR TO VERIFY ALL PART NUMBERS AND TO REPORT ANY ERRORS AND/OR OMISSIONS IN THE DRAWINGS AND SPECIFICATIONS WITH THEIR BID SUBMISSION.
- ALL ITEMS BY COMMUNICATIONS CONTRACTOR UNLESS OTHERWISE NOTED.
- REVIEW ALL PROJECT RELATED ARCHITECTURAL, MECHANICAL, ELECTRICAL, SECURITY AND AV DRAWINGS AND SPECIFICATIONS. DISCERN AND COORDINATE ALL OVERLAPPING WORK WITH COMMUNICATIONS SYSTEMS TO AVOID COLLISIONS AND CONFLICTS OF DEVICES.
- DEVICES SHALL NOT BE INSTALLED IN WALL AREAS THAT ARE DESIGNATED TO HAVE MARKER BOARD, FABRIC PANELS, OR ACCENT FINISHES/DETAIL UNLESS INDICATED SPECIFICALLY ON AN ELEVATED DRAWING.
- DEVICES SHALL NOT BE INSTALLED ABOVE ANY FURNITURE - AND SHALL BE LOCATED WHERE THERE IS ADEQUATE ACCESS FOR USE UNLESS INDICATED SPECIFICALLY ON AN ELEVATED DRAWING.
- INFORM THE ENGINEER'S REPRESENTATIVE AND GENERAL CONTRACTOR OF ALL DEVICE AND FURNITURE CONFLICTS PRIOR TO INSTALLATION. OBTAIN RESOLUTION TO DEVICE AND FURNITURE CONFLICTS FROM THE ENGINEER'S REPRESENTATIVE PRIOR TO INSTALLATION.



 
3
TC-0.1



4
TC-0.1

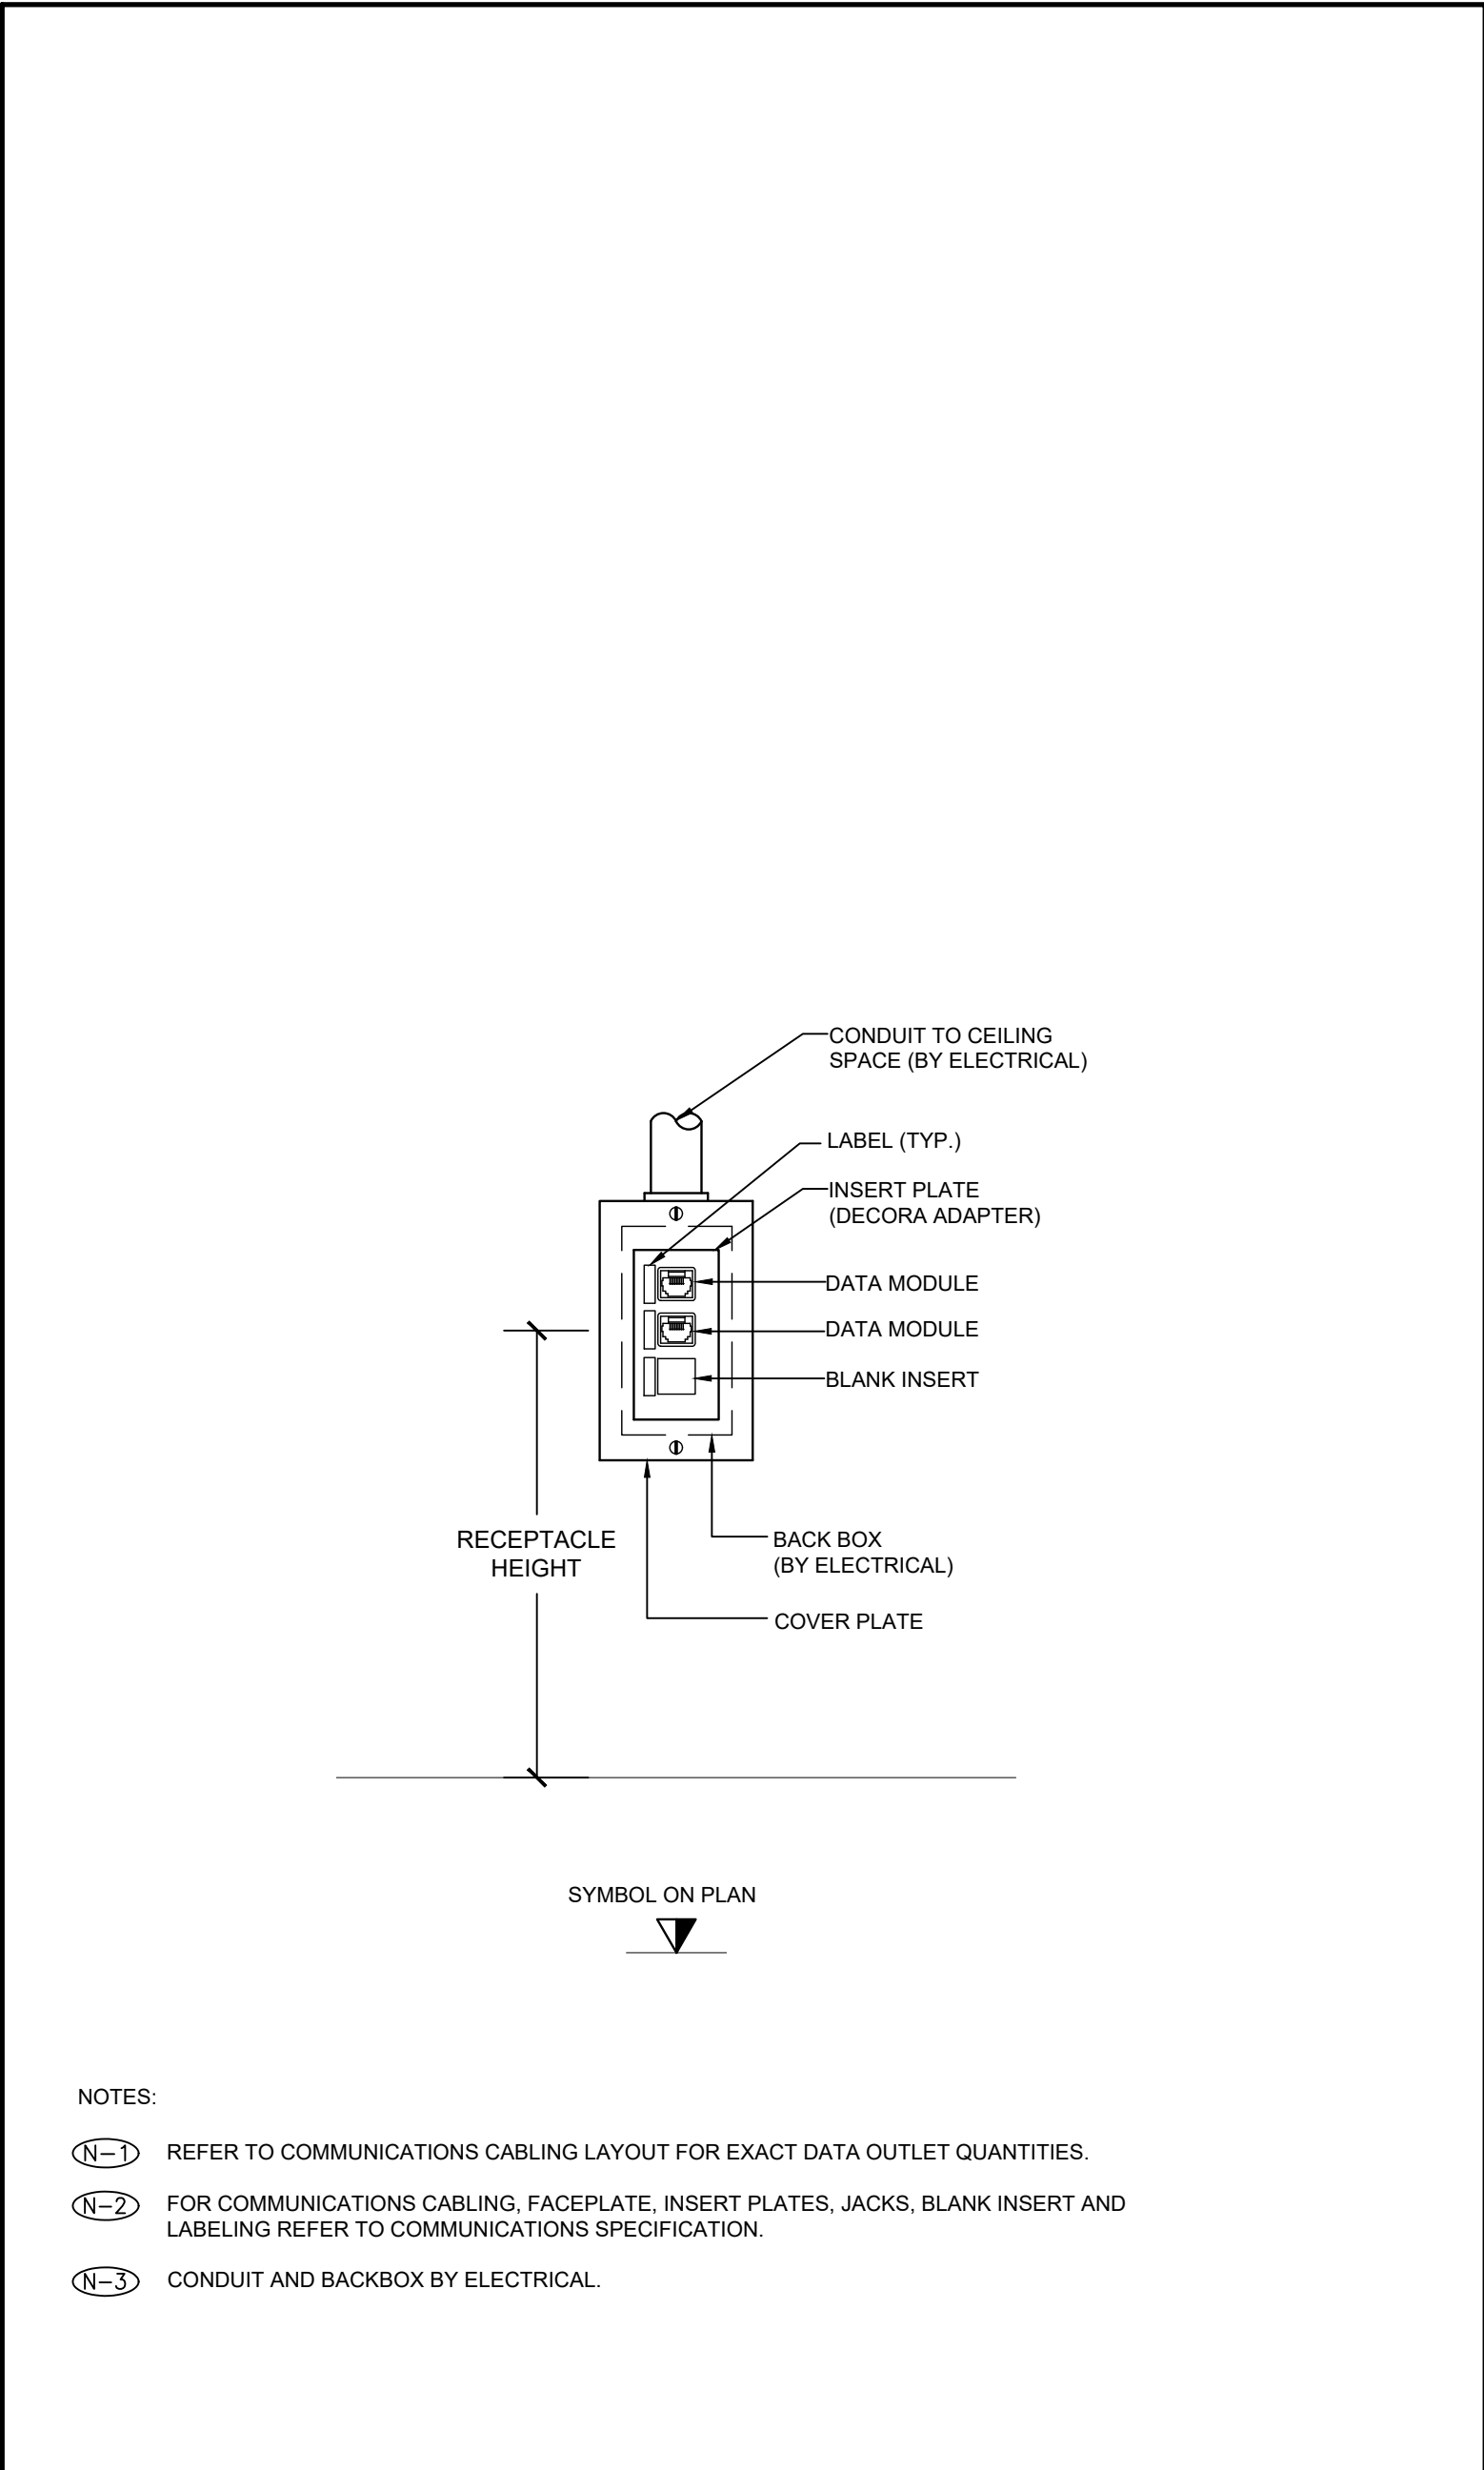

1
TC-0.1
TYPICAL WALL MOUNTED COMMUNICATIONS 3-PORT OUTLET DETAIL
SCALE: N.T.S.

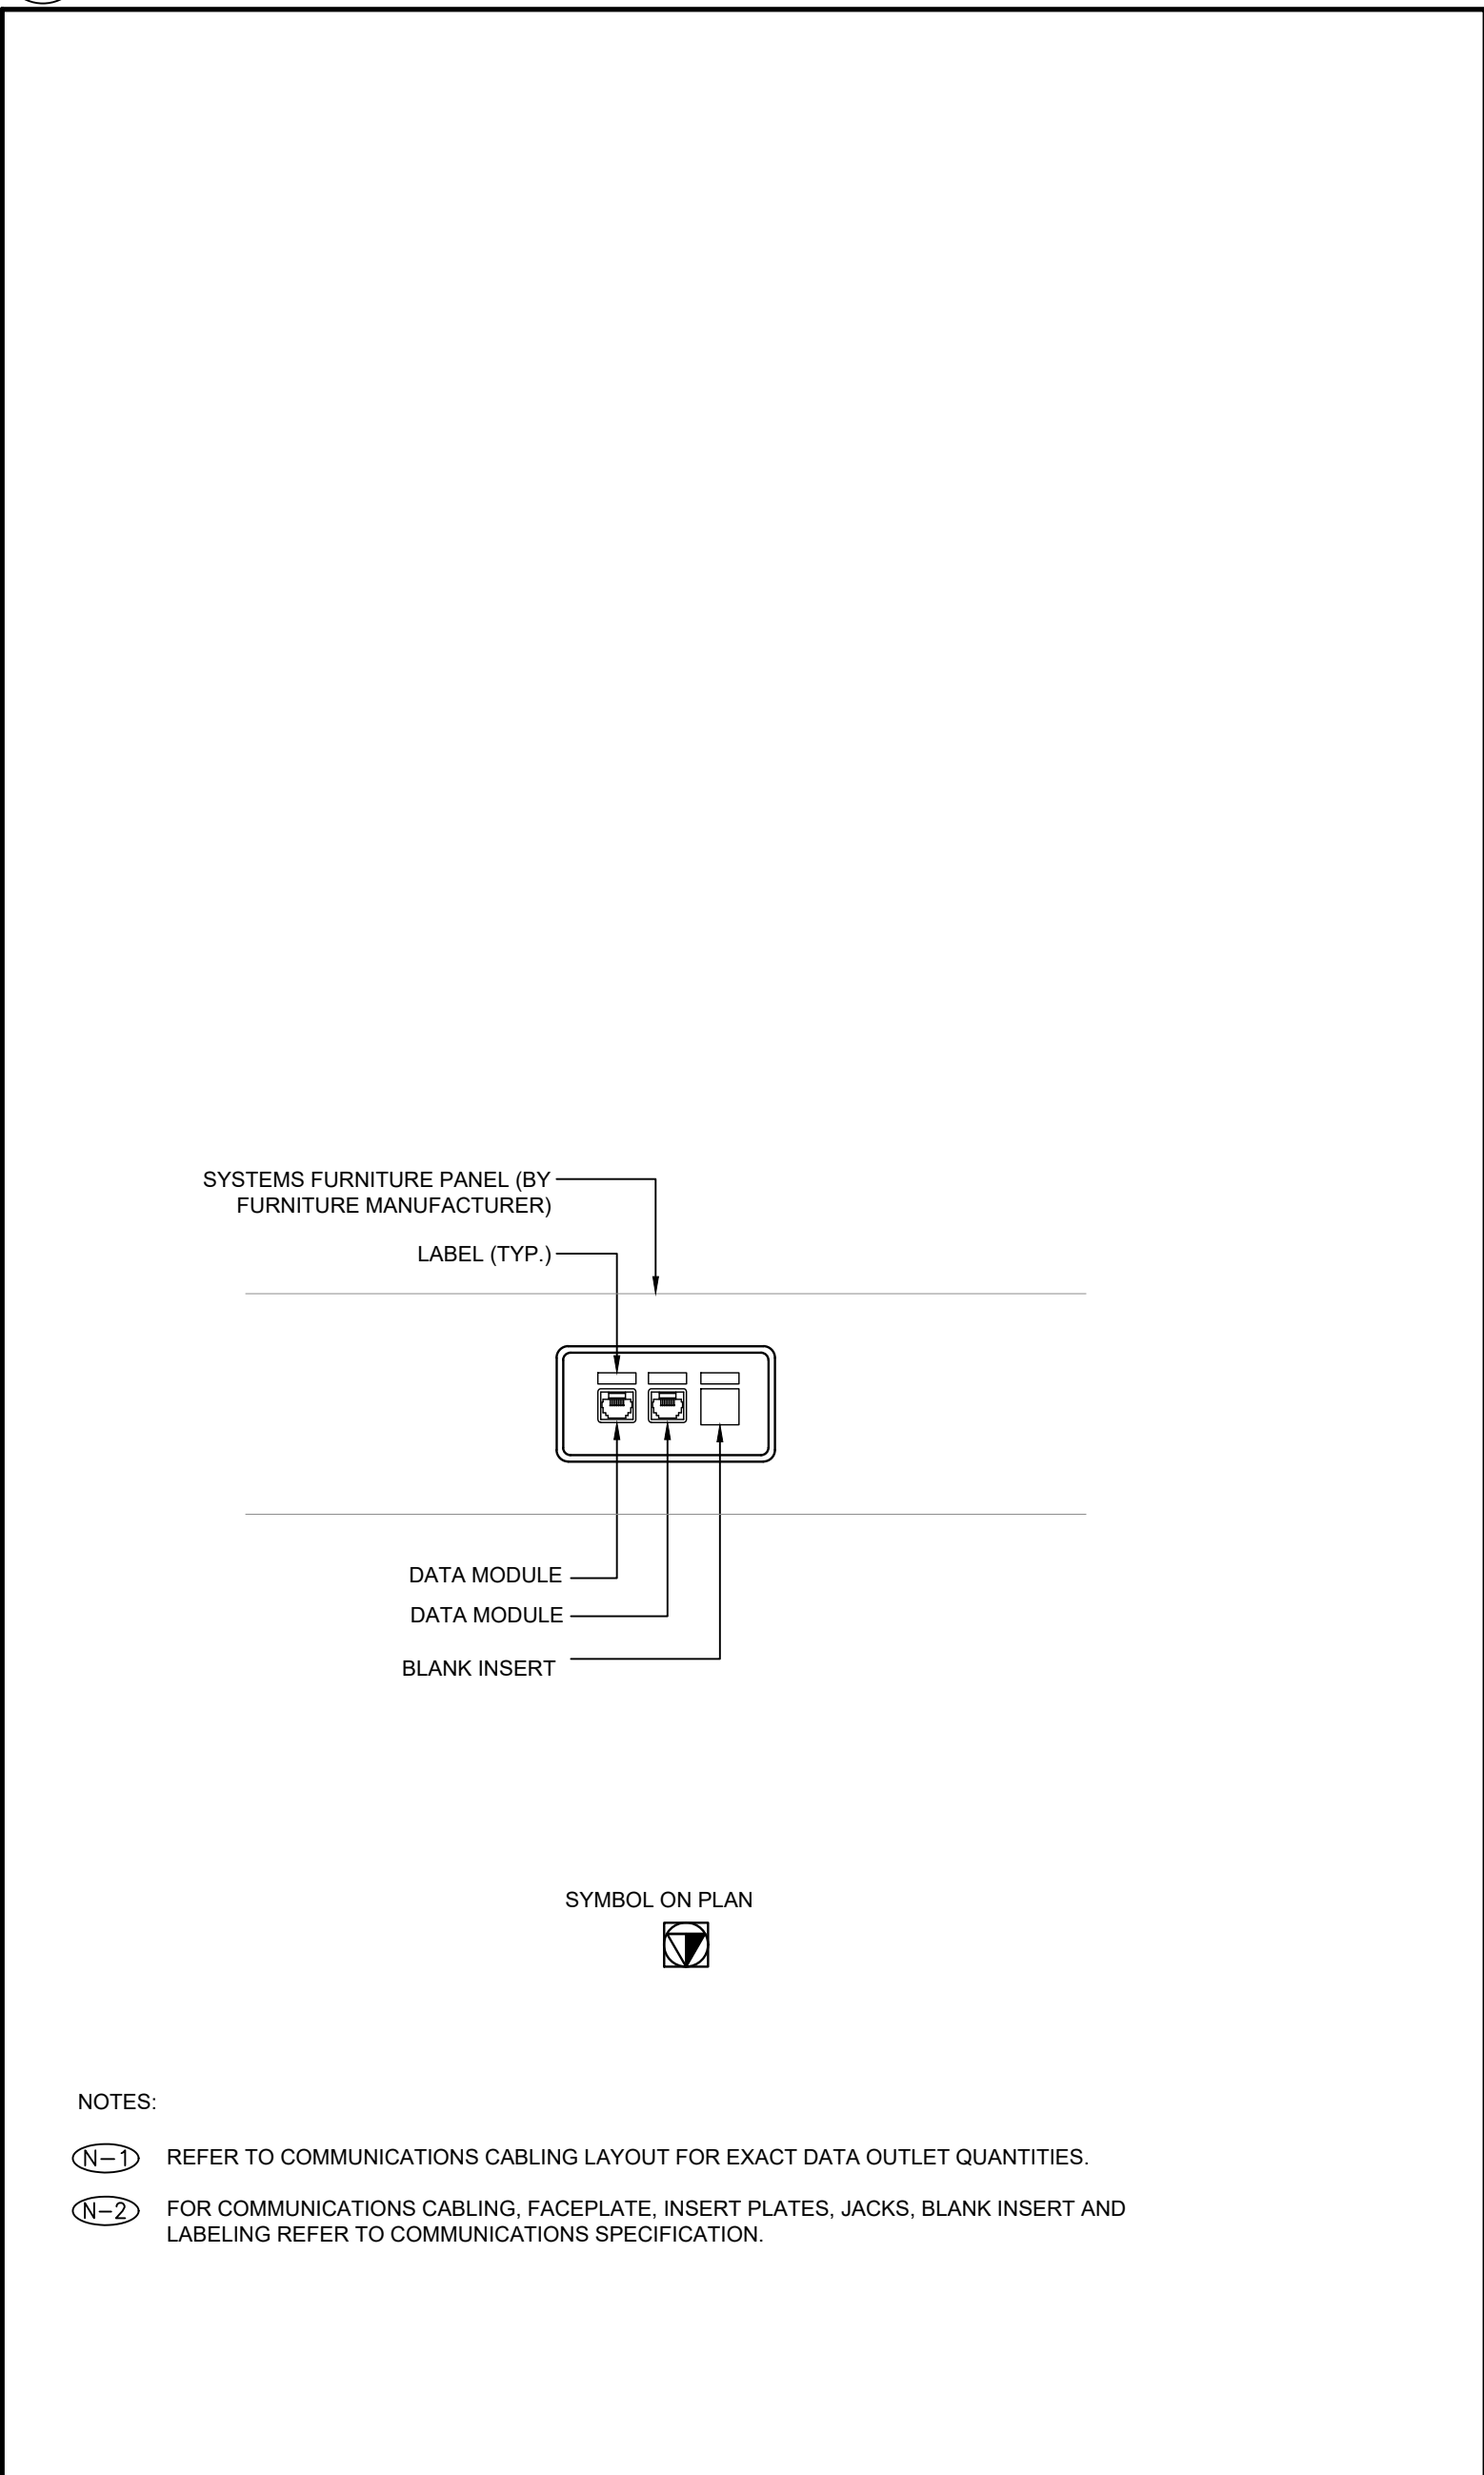

2
TC-0.1
TYPICAL FURNITURE MOUNTED COMMUNICATIONS OUTLET DETAIL
SCALE: N.T.S.

DRAWING LIST			
DRAWING No.	TITLE		
TC-0.1	DRAWING LIST, GENERAL NOTES, ABBREVIATIONS, LEGENDS AND DETAILS		
TC-0.2	COMMUNICATIONS PATHWAY DETAILS		
TC-0.3	COMMUNICATIONS TELECOM ROOM DETAILS		
TC-2.0	2ND FLOOR COMMUNICATIONS DEMOLITION LAYOUT		
TC-2.1	2ND FLOOR COMMUNICATIONS LAYOUT		
TC-3.0	3RD FLOOR COMMUNICATIONS DEMOLITION LAYOUT		
TC-3.1	3RD FLOOR COMMUNICATIONS LAYOUT		
ABBREVIATIONS			
AFF	ABOVE FINISHED FLOOR	BP	BLANK PLATE
DAS	DISTRIBUTED ANTENNA SYSTEM	E	EXISTING TO REMAIN
ER	EXISTING TO BE REMOVED	FTTD	FIBRE TO THE DESK
JB	JUNCTION BOX	KW	KILOWATTS
R	EXISTING TO BE RELOCATED	RR	REMOVE AND REINSTALL
RSD	ROOM SCHEDULING DEVICE	TYP	TYPICAL - TO BE INTERPRETED AS THE SAME AS COMPARABLE FEATURES.
V	VOLTS	WAP	WIRELESS ACCESS POINT
WP	EXTERIOR/WEATHERPROOF		
LEGEND			
	DETAIL NUMBER		SECTION NUMBER
	DRAWING NUMBER		DRAWING NUMBER
	REVISION BUBBLE		REVISION NUMBER
	WALL MOUNTED DATA AND/OR VOICE OUTLETS. COMMUNICATIONS CABLE TYPE AS PER SPECIFICATION.		
	WALL MOUNTED DATA OUTLET. COMMUNICATION CABLE TYPE AS PER SPECIFICATION.		
	WALL MOUNTED VOICE OUTLET. COMMUNICATION CABLE TYPE AS PER SPECIFICATION.		
	WALL MOUNTED AUDIO VISUAL CONNECTION. COMMUNICATION CABLE TYPE AS PER SPECIFICATION.		
	FLOOR MOUNTED DATA AND/OR VOICE OUTLETS. COMMUNICATIONS CABLE TYPE AS PER SPECIFICATION.		
	FLOOR MOUNTED DATA OUTLET. COMMUNICATION CABLE TYPE AS PER SPECIFICATION.		
	FLOOR MOUNTED VOICE OUTLET. COMMUNICATION CABLE TYPE AS PER SPECIFICATION.		
	FURNITURE MOUNTED DATA AND/OR VOICE OUTLETS. COMMUNICATIONS CABLE TYPE AS PER SPECIFICATION.		
	FURNITURE MOUNTED DATA OUTLET. COMMUNICATION CABLE TYPE AS PER SPECIFICATION.		
	FURNITURE MOUNTED VOICE OUTLET. COMMUNICATION CABLE TYPE AS PER SPECIFICATION.		
	WIREMOLD MOUNTED DATA AND/OR VOICE OUTLETS. COMMUNICATIONS CABLE TYPE AS PER SPECIFICATION.		
	CEILING MOUNTED DATA OUTLET(S). CABLE TYPE AS PER SPECIFICATION.		
	CEILING MOUNTED DATA OUTLET. COMMUNICATION CABLE TYPE AS PER SPECIFICATION.		
	CEILING MOUNTED VOICE OUTLET. COMMUNICATION CABLE TYPE AS PER SPECIFICATION.		
	CEILING MOUNTED AUDIO VISUAL CONNECTION. COMMUNICATION CABLE TYPE AS PER SPECIFICATION.		
	4-PAIR HORIZONTAL COPPER DATA CABLE FOR SECURITY CAMERA CABLING.		
Z-XXX	4-PAIR HORIZONTAL COPPER CABLE. LABELING SCHEME SHOWN IS GENERIC. VERIFY EXACT LABELING SCHEME PRIOR TO INSTALLATION. LETTER DENOTES CABLE TYPE: D = DATA, V = VOICE, W = WIRELESS ACCESS POINT, AV = AUDIO/VISUAL DATA, S = SECURITY		
	COAXIAL CATV OUTLET		
	FEED POINT FOR COMMUNICATIONS CABLING. LETTER DENOTES FEED LOCATION: W = WALL, F = FLOOR, P = PAC POLE, WM = WIREMOLD		
	CONDUIT FOR COMMUNICATIONS CABLING. SIZE AND QUANTITY AS NOTED. BY ELECTRICAL UNLESS OTHERWISE NOTED.		
	CABLE TRAY FOR COMMUNICATIONS CABLING. SIZE AS NOTED. BY ELECTRICAL CONTRACTOR UNLESS OTHERWISE NOTED.		
	GRID POINT BOUNDARY		
	NOT IN CONTRACT		

NOTE: NOT ALL SYMBOLS APPLY. CONTRACTOR TO REFER TO FLOOR PLANS.

ATHENA

41 DOVERCOURT ROAD | SUITE 505 | TORONTO | M6J 0G6

416 525 6810
WWW.STUDIOATHENA.CA

©2026 STUDIOATHENA INC. ALL DRAWINGS AND WRITTEN MATERIAL HEREIN CONSTITUTE THE ORIGINAL AND UNPUBLISHED WORK OF THE DESIGNER, AND THE SAME MAY NOT BE DUPLICATED, USED, OR DISCLOSED WITHOUT THE WRITTEN CONSENT OF THE DESIGNER.

NO.	ISSUE	DATE
01.	ISSUED FOR REVIEW	2026-05-26
02.	ISSUED FOR TENDER REVIEW	2026-06-12
03.	ISSUED FOR TENDER	2026-07-24

PROJECT CONTACT

NAME: JOSHUA BLIZZARD
TEL: 647 943 0261
EMAIL: joshua.blizzard@smithandandersen.com

THIS DRAWING SHALL BE READ IN CONJUNCTION WITH COMMUNICATIONS SPECIFICATION SUBMITTED FOR THIS PROJECT.



Smith + Andersen

1100 - 100 Sheppard Ave. East, Toronto On, M2N 6N5
416 487 8151 | 416 487 9104 smithandandersen.com

TORONTO EMERGENCY MANAGEMENT


703 DON MILLS ROAD, 02-03FL
TORONTO ON M3C 3N3

Drawing Title:


DRAWING LIST, GENERAL NOTES, ABBREVIATIONS, LEGENDS AND DETAILS

Drawn By: CV
Checked By: JB/TJS
Scale: 1/8" = 1'-0"
Project number: 91002.010.MED.001
Drawing Number:


TC-0.1

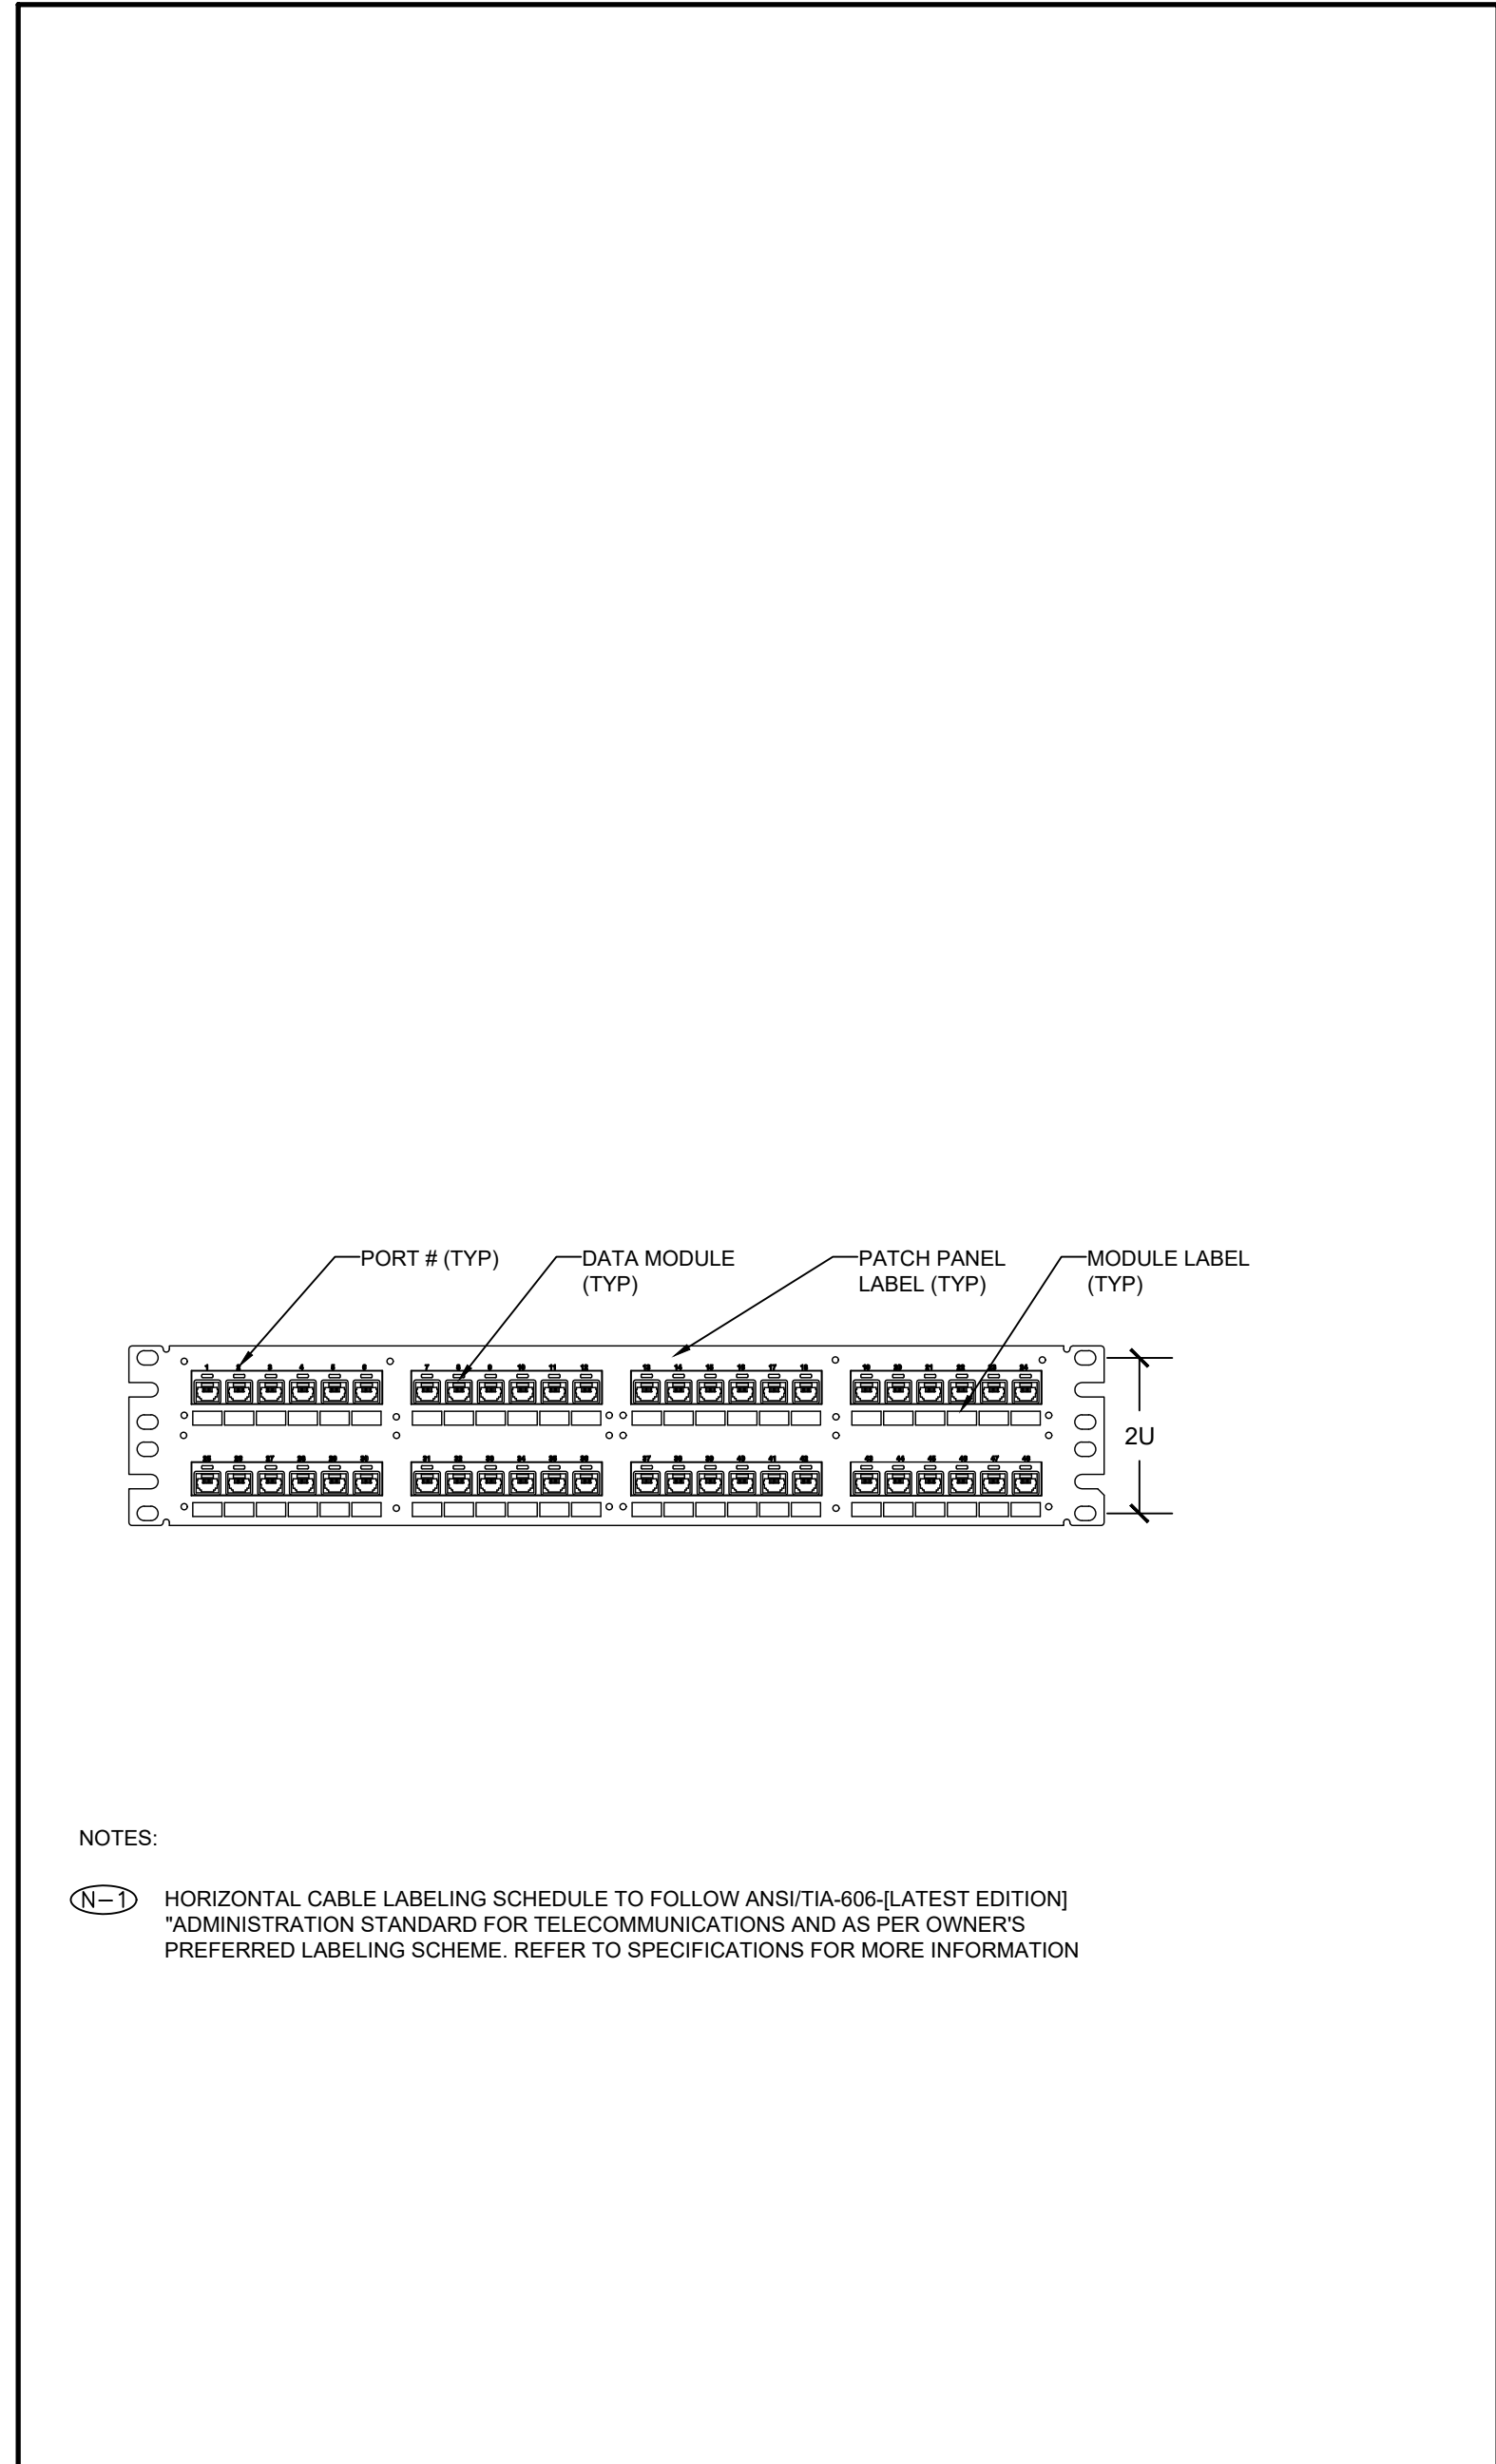


7 TYPICAL 2U-48 PORT MODULAR PATCH PANEL DETAIL
SCALE: N.T.S.

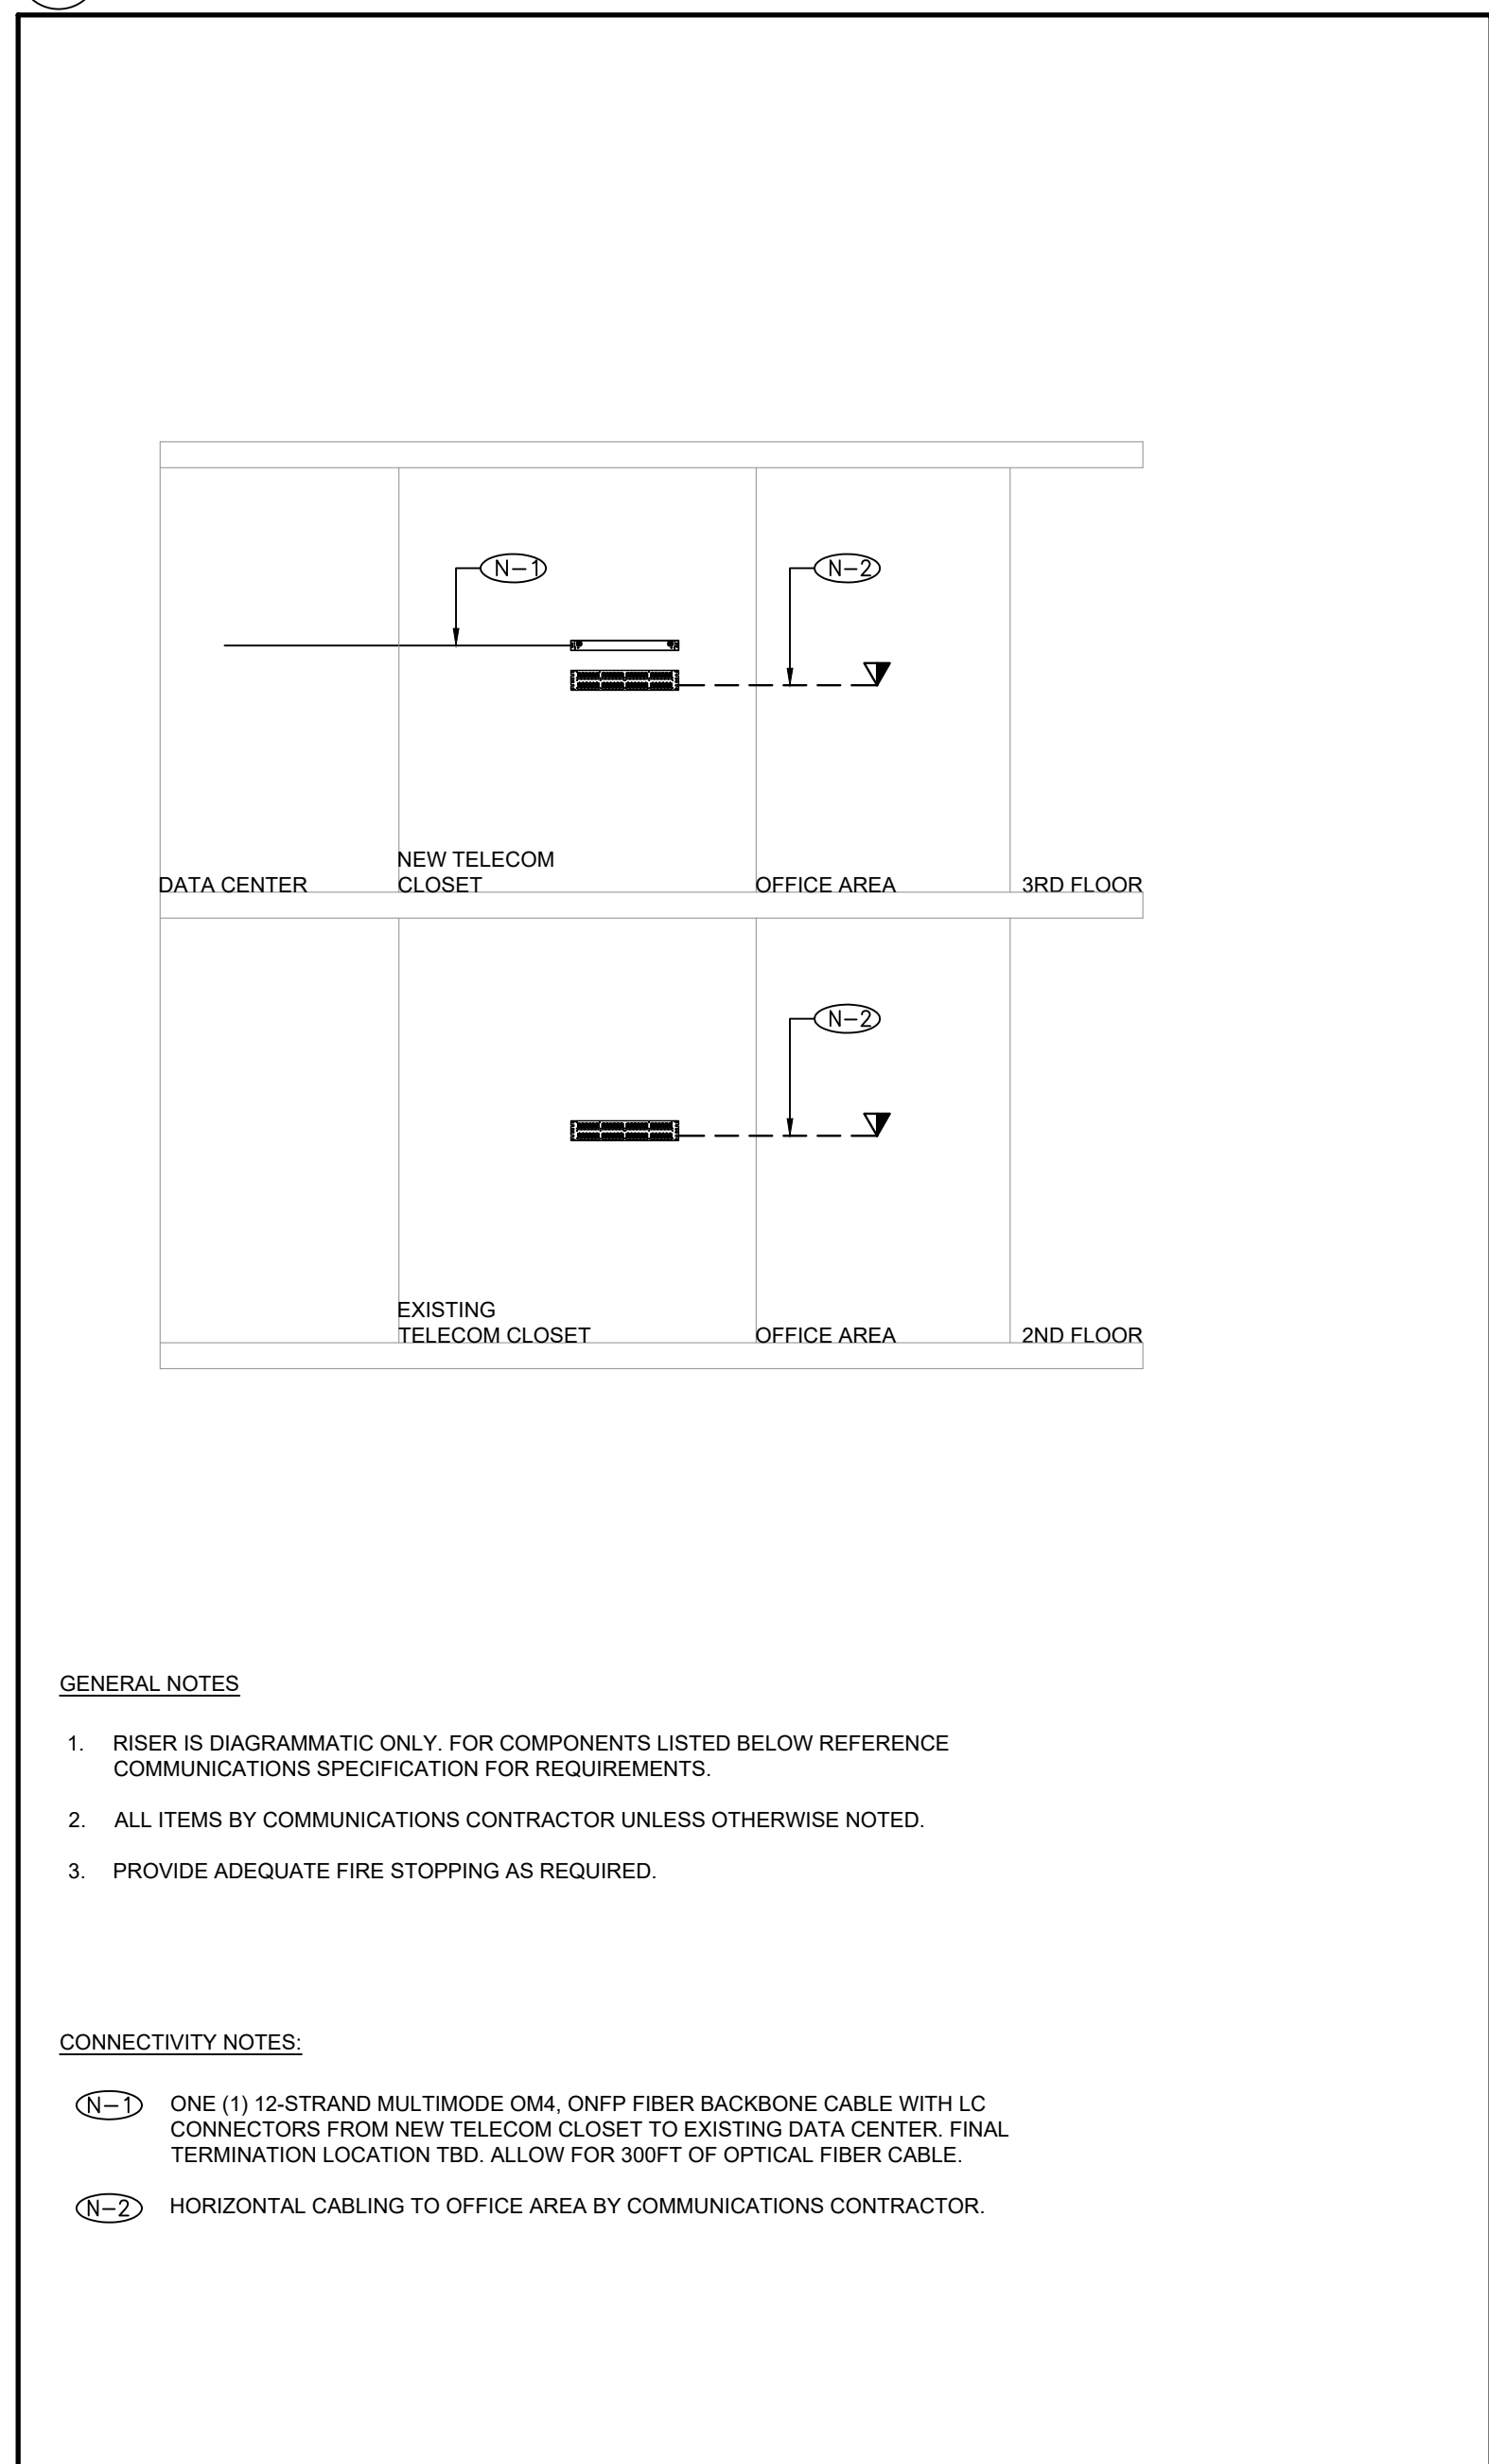


8 COMMUNICATIONS RISER DIAGRAM
SCALE: N.T.S.

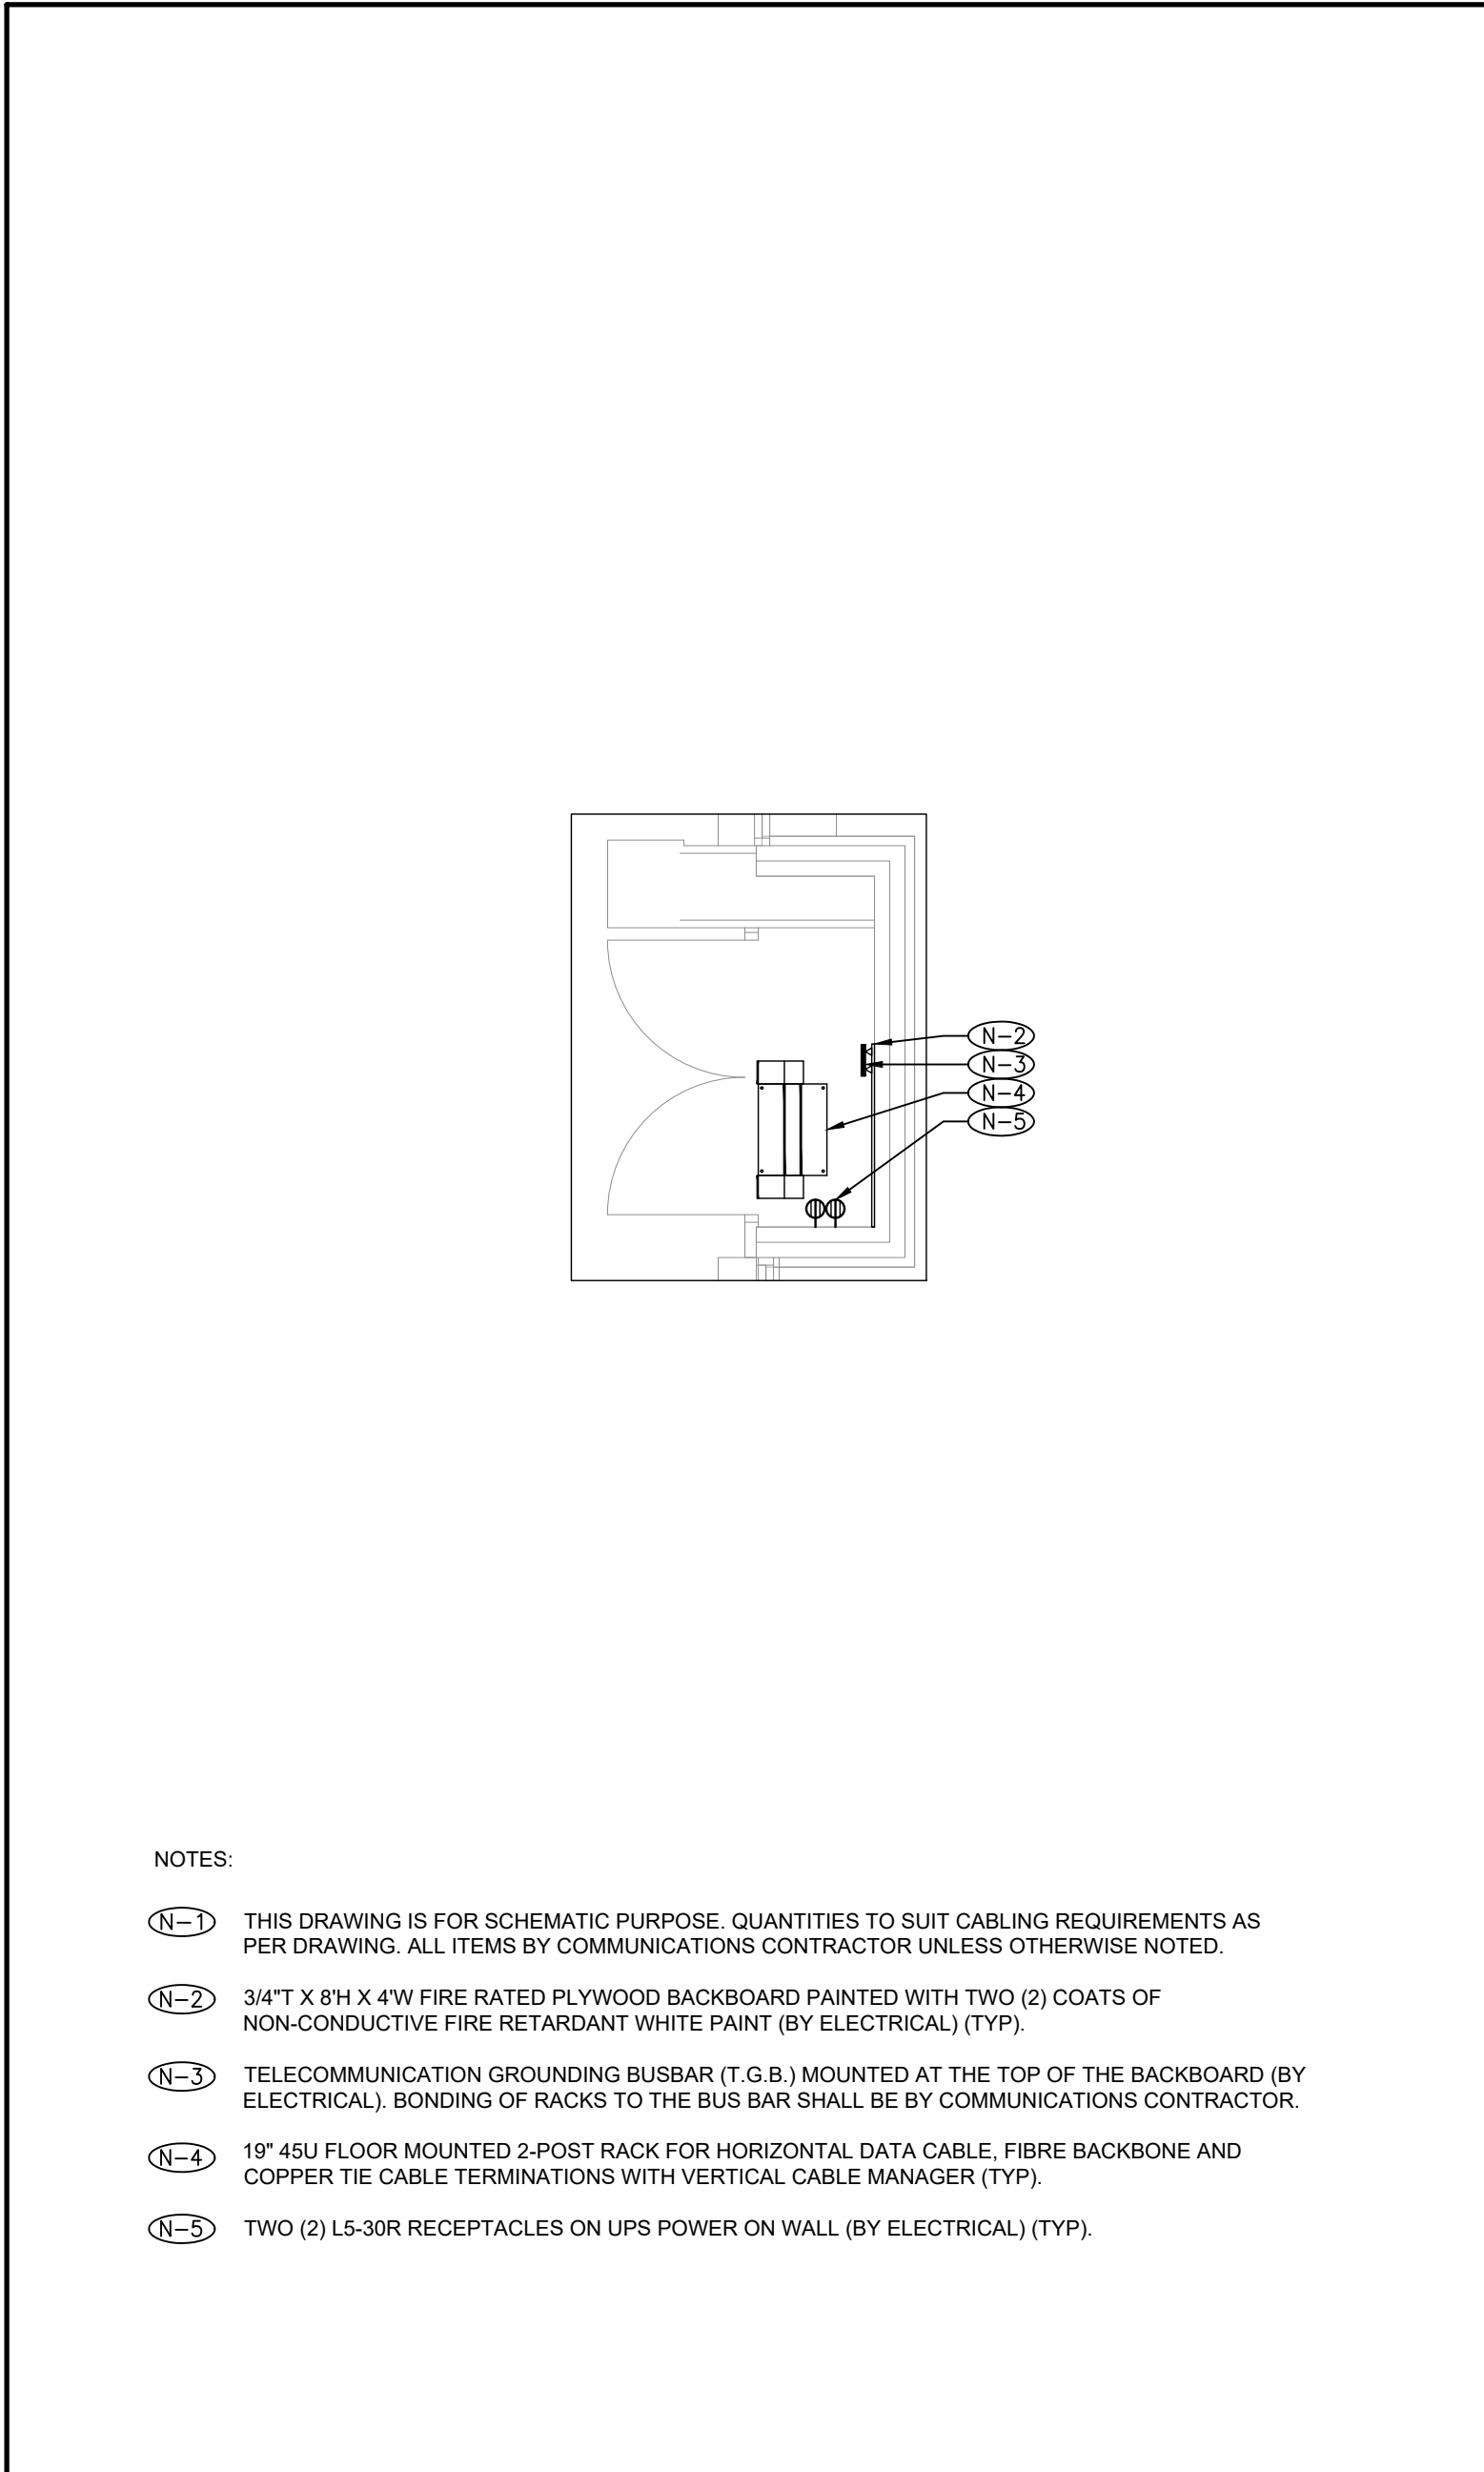


9 TELECOM CLOSET PLAN DETAIL
SCALE: N.T.S.

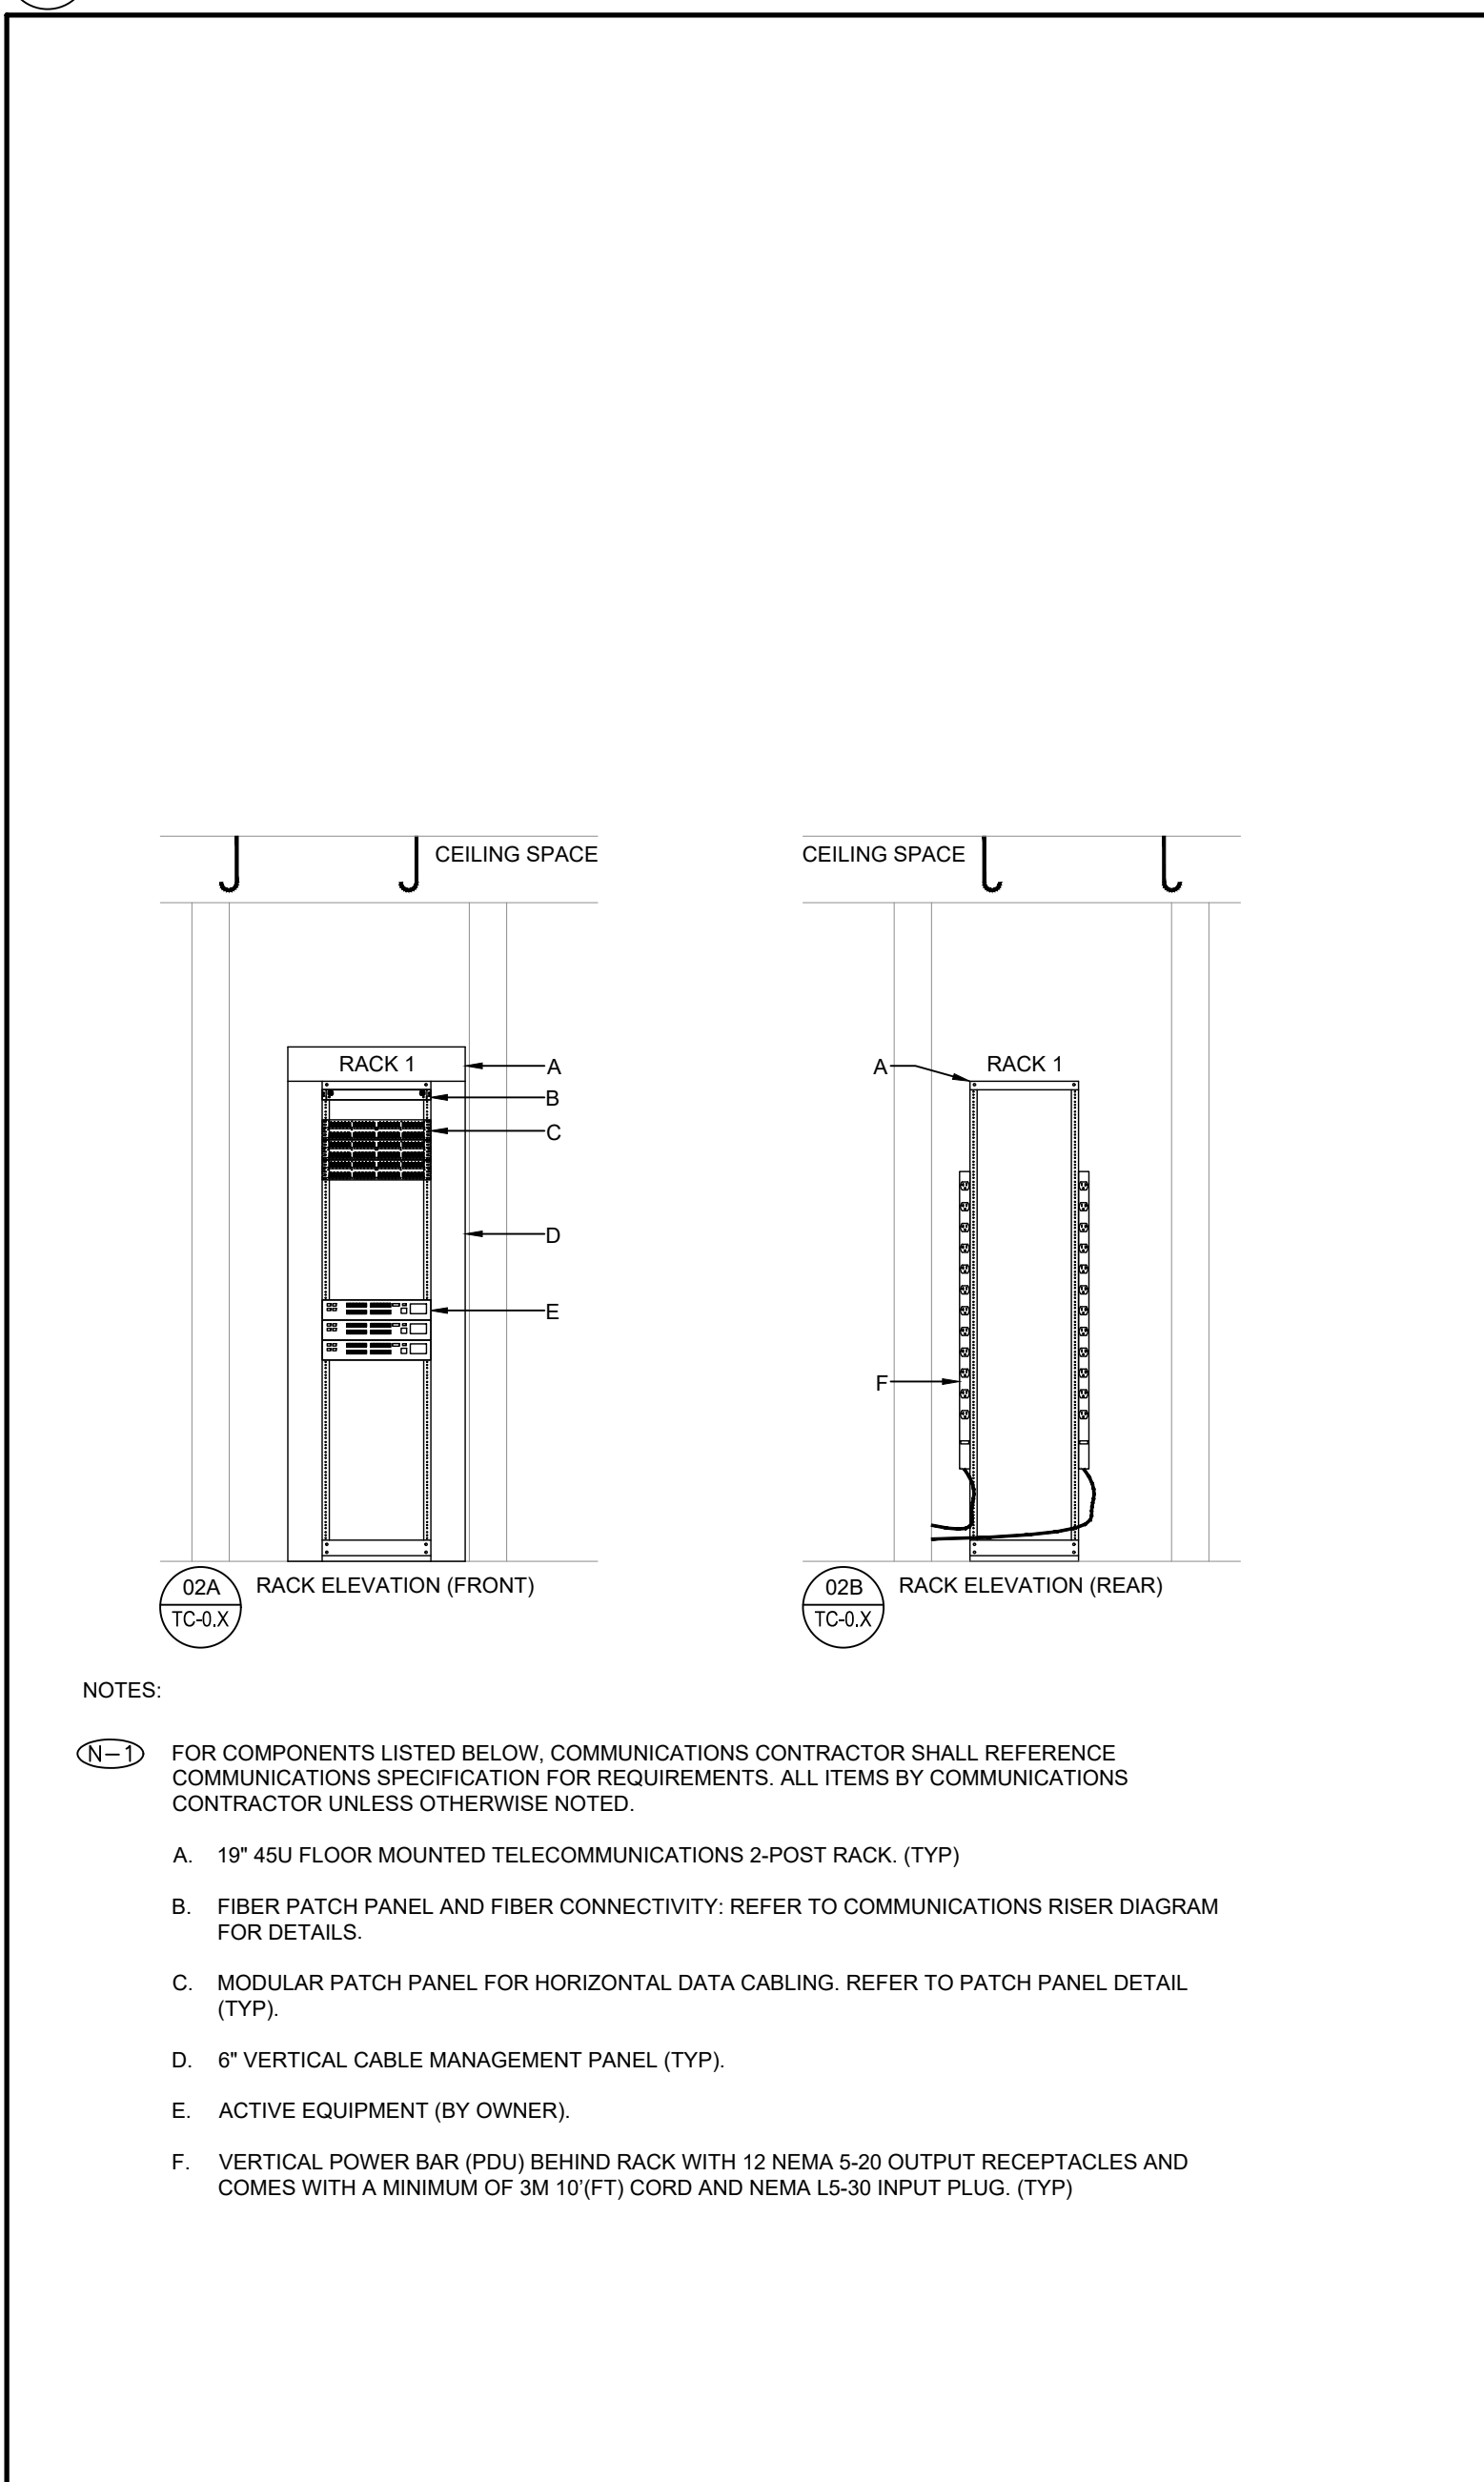


10 COMMUNICATIONS RACK ELEVATION DETAIL
SCALE: N.T.S.

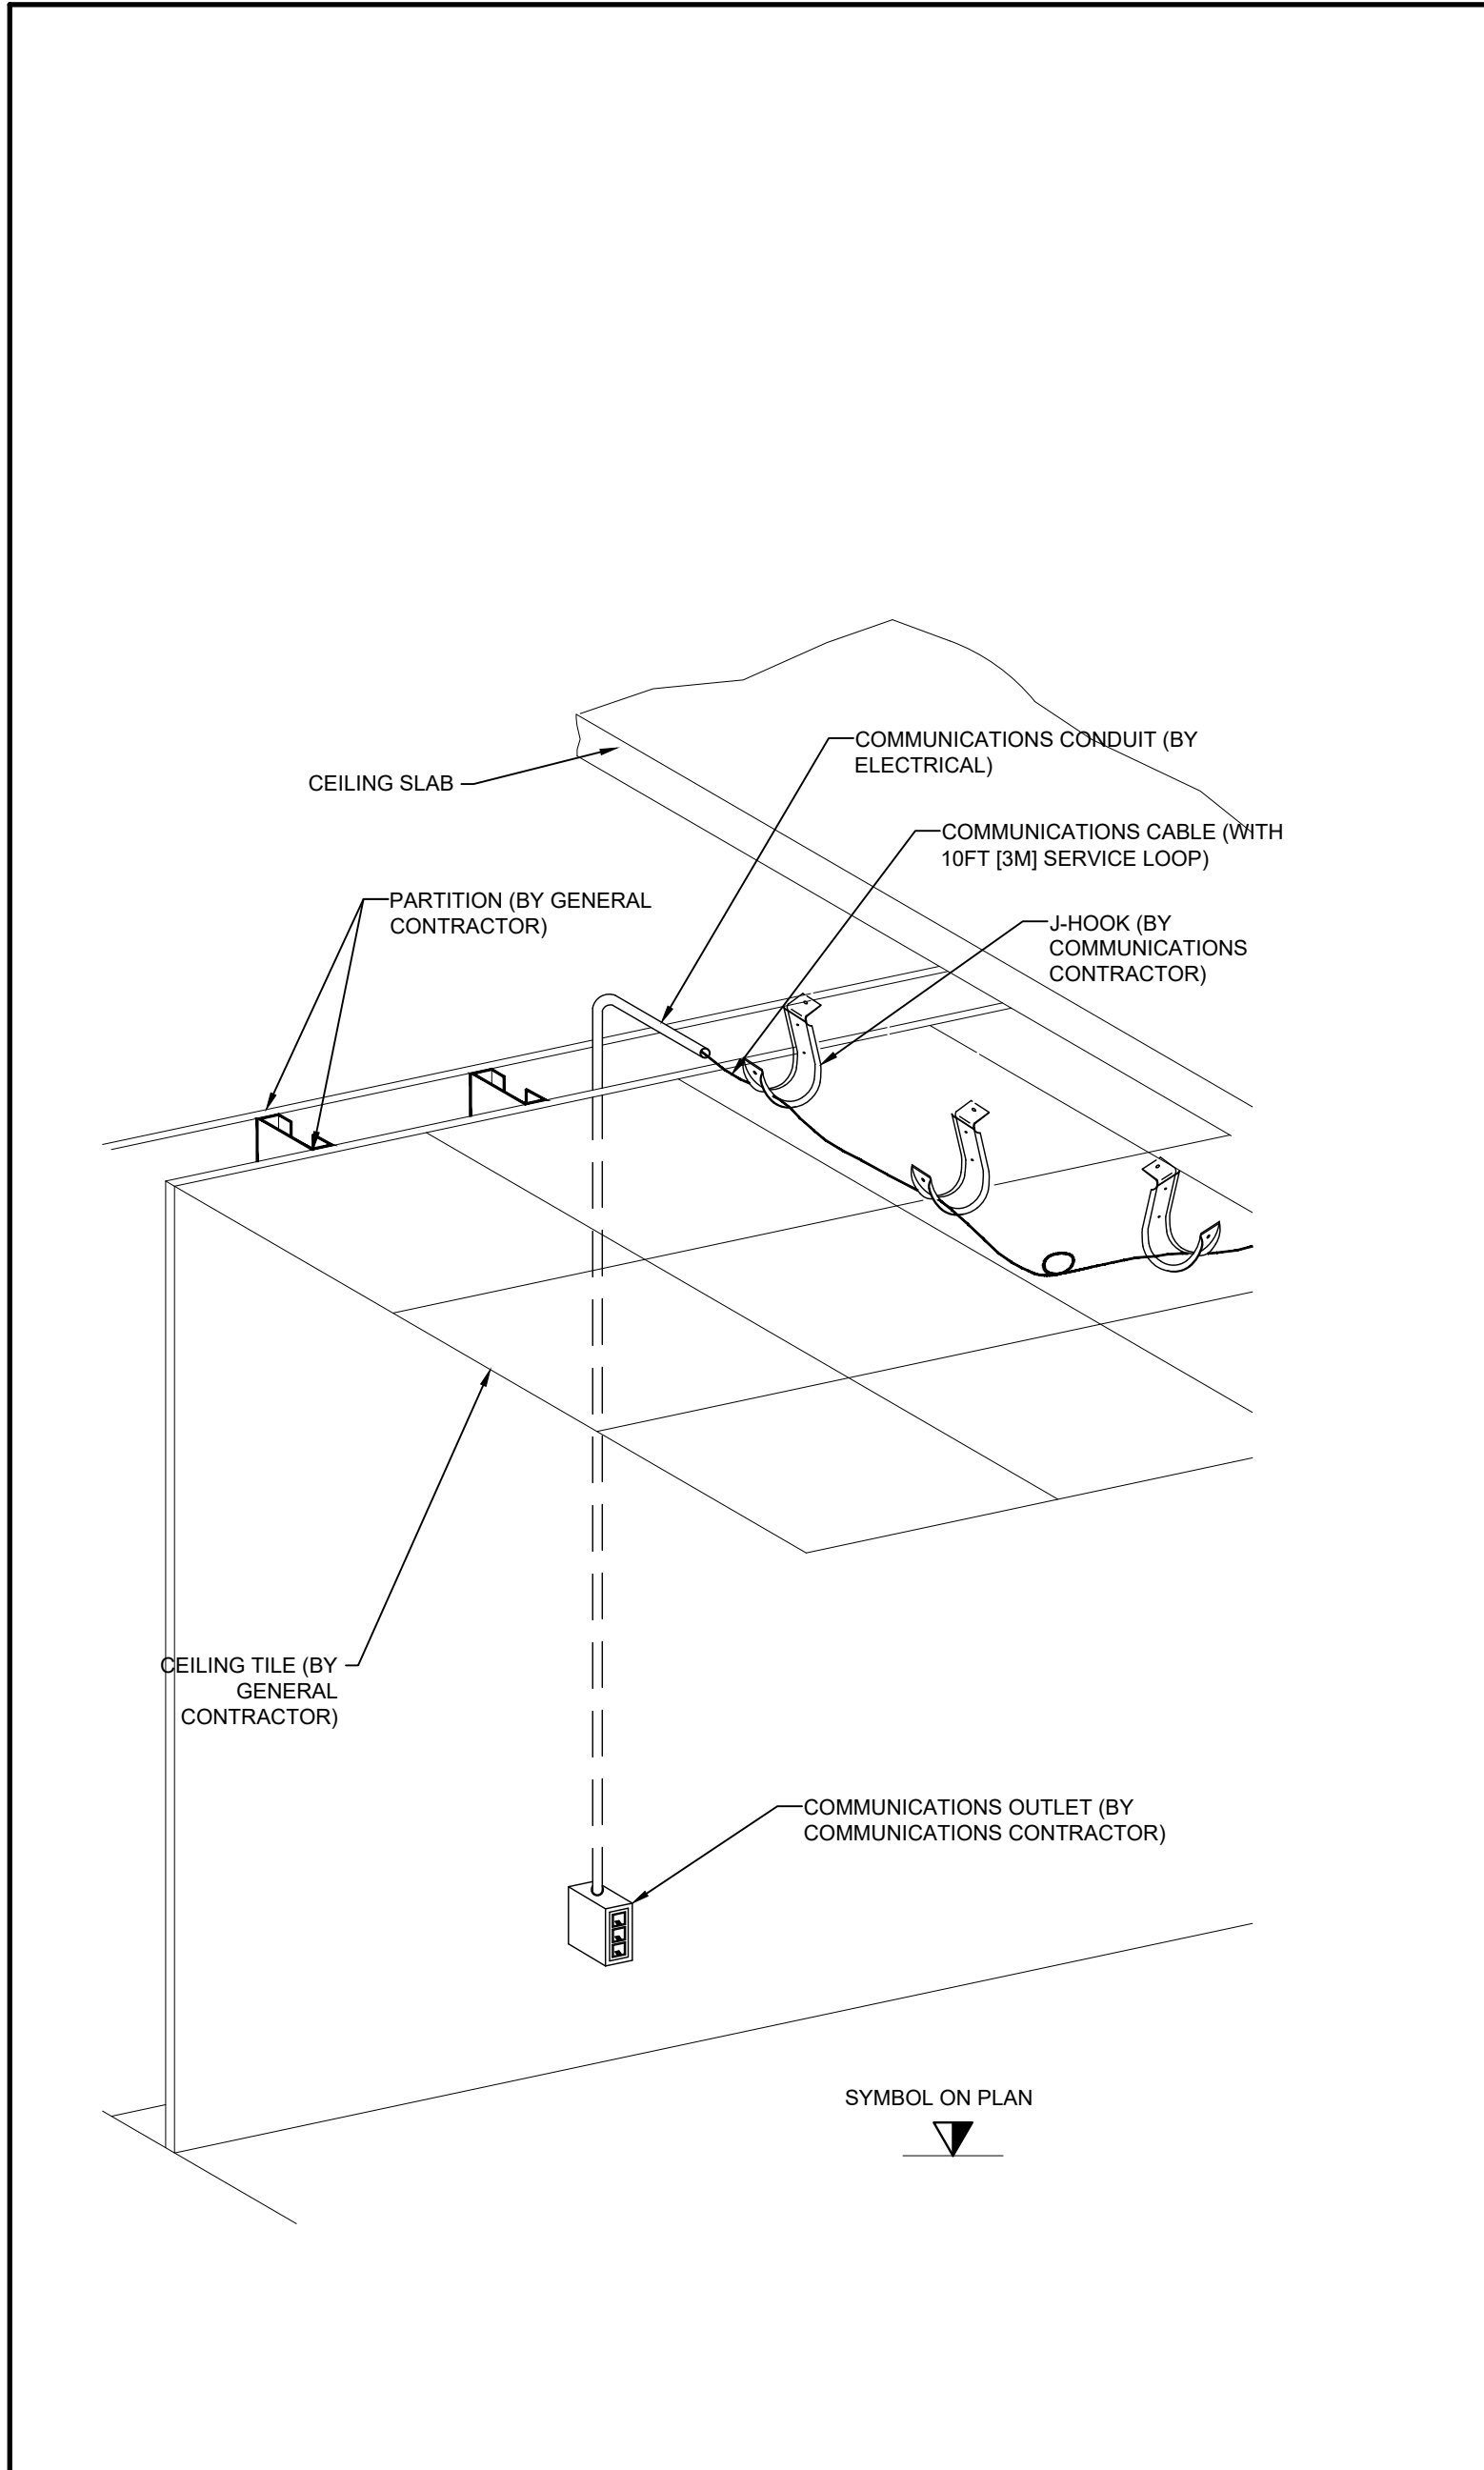


3 TYPICAL COMMUNICATIONS CABLE WALL ROUTING DETAIL - ACCESSIBLE CEILING
SCALE: N.T.S.

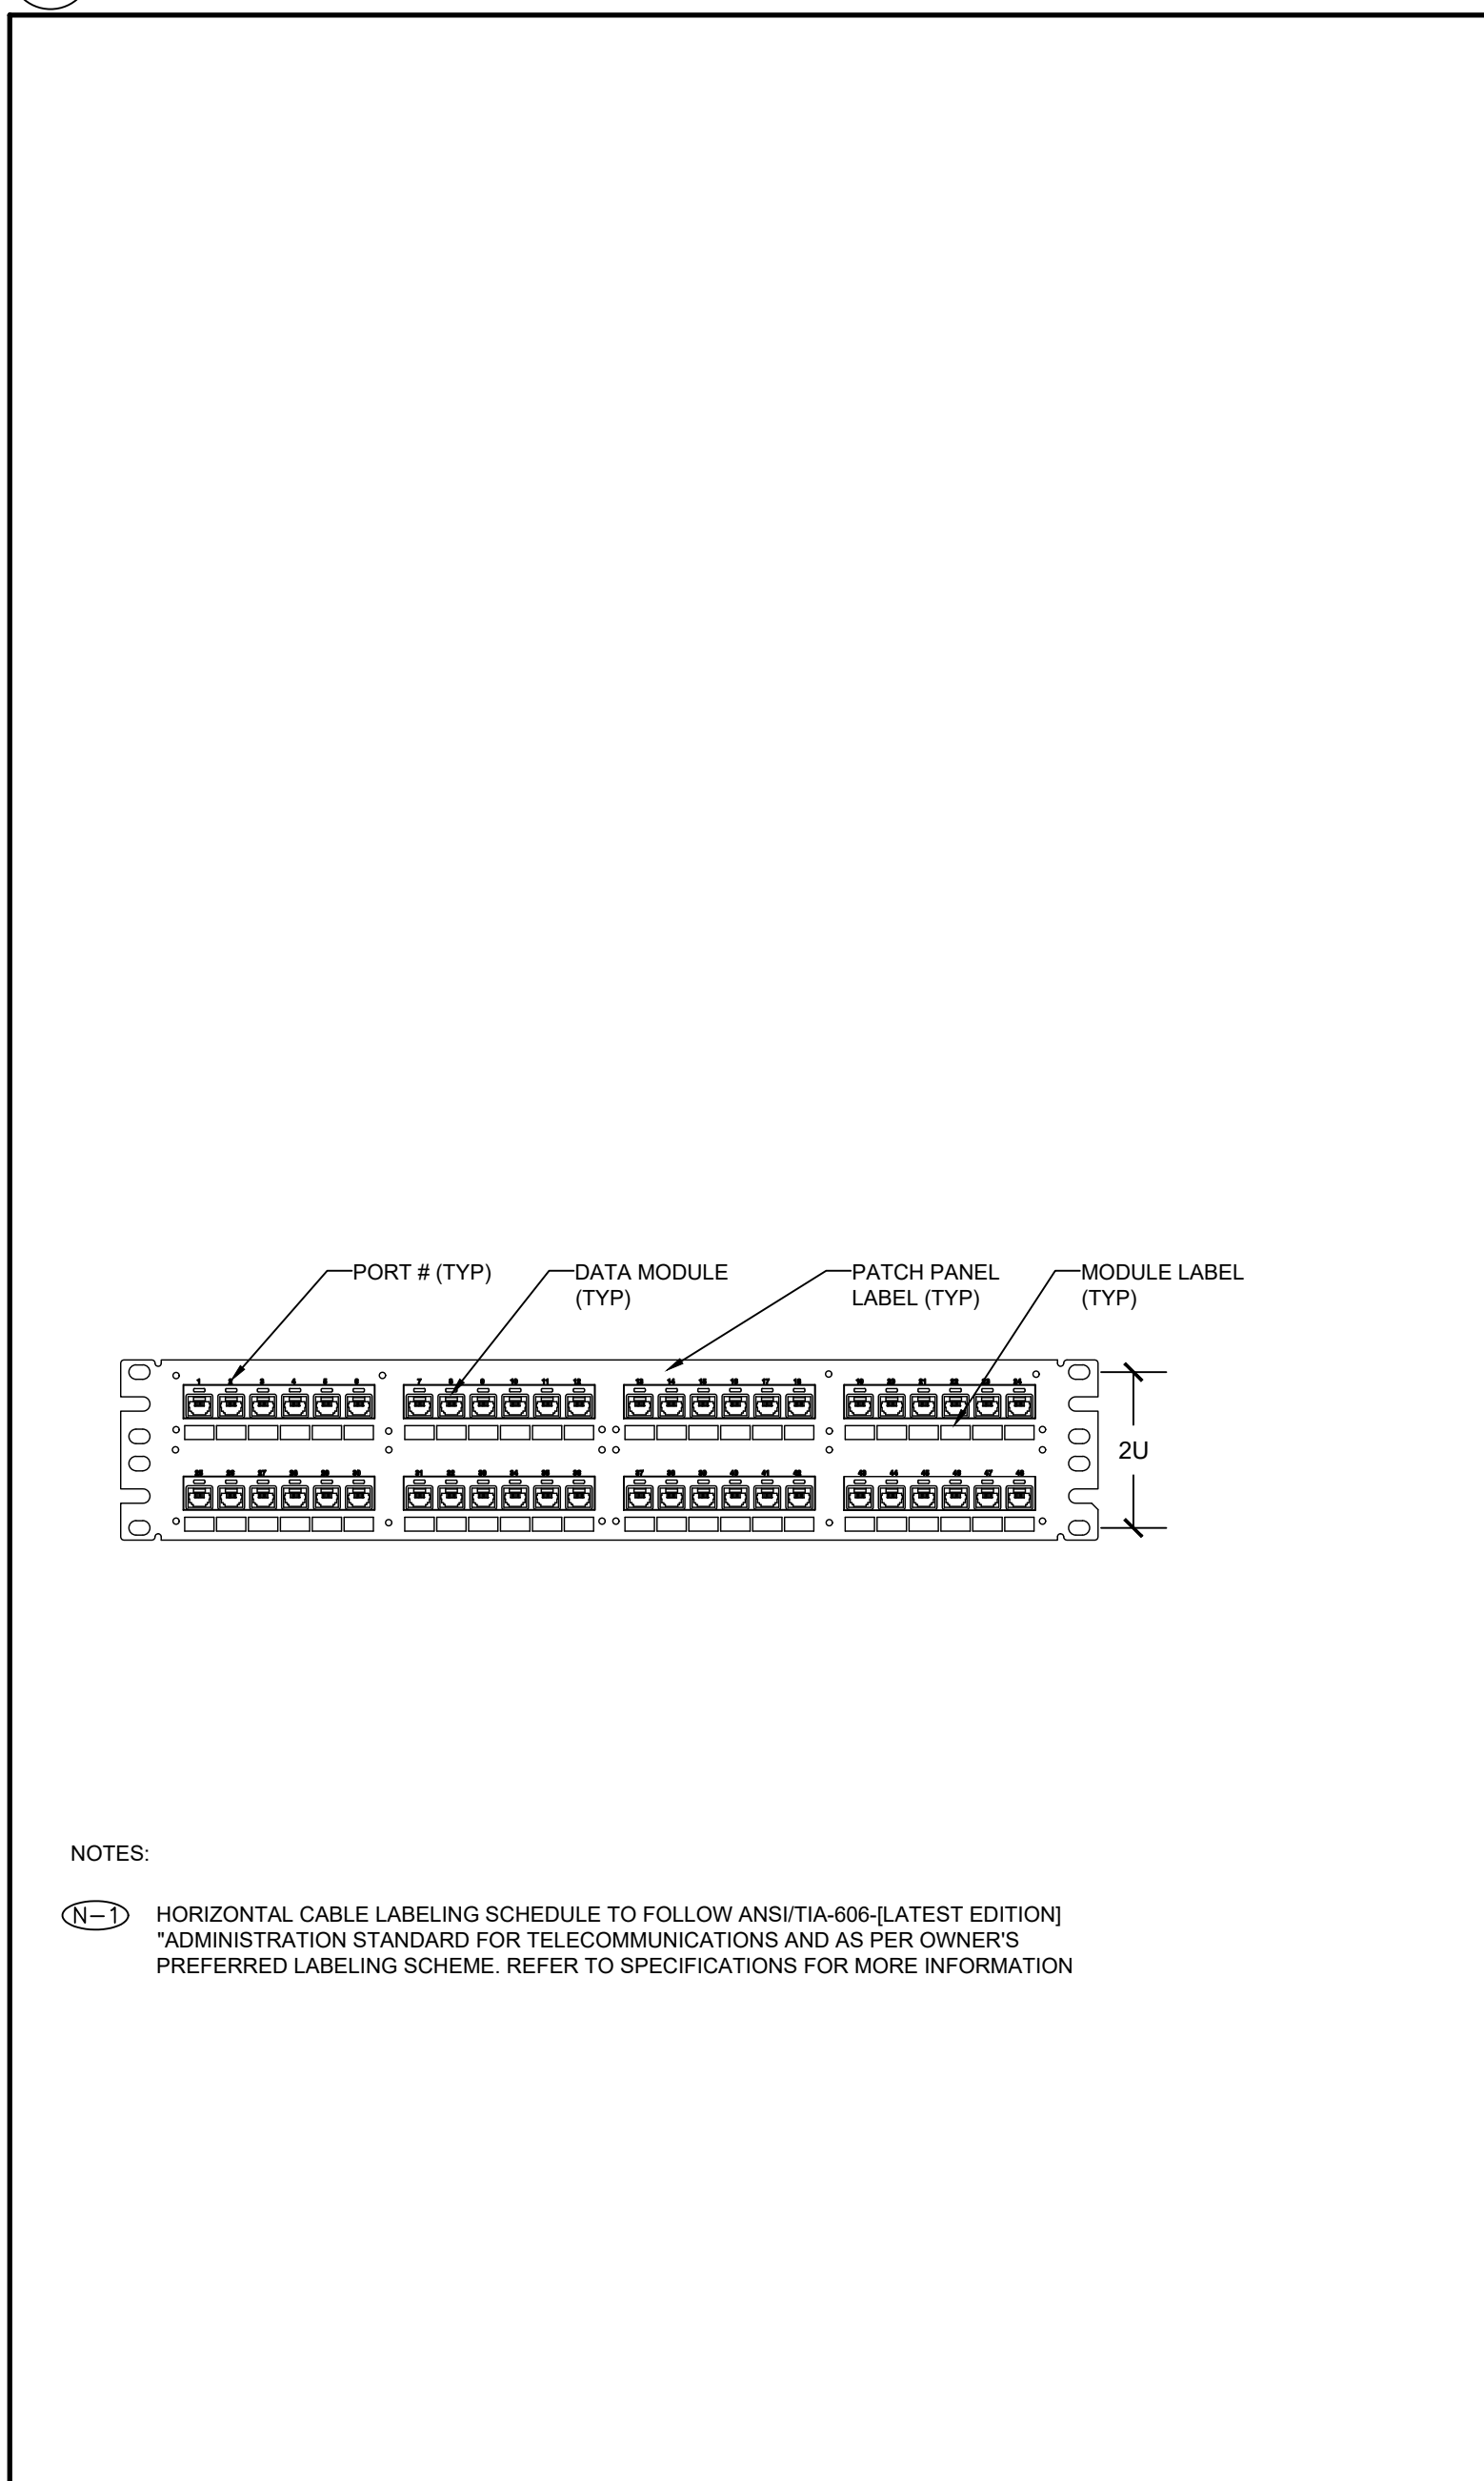

4 TYPICAL 2U-48 PORT MODULAR PATCH PANEL DETAIL
SCALE: N.T.S.

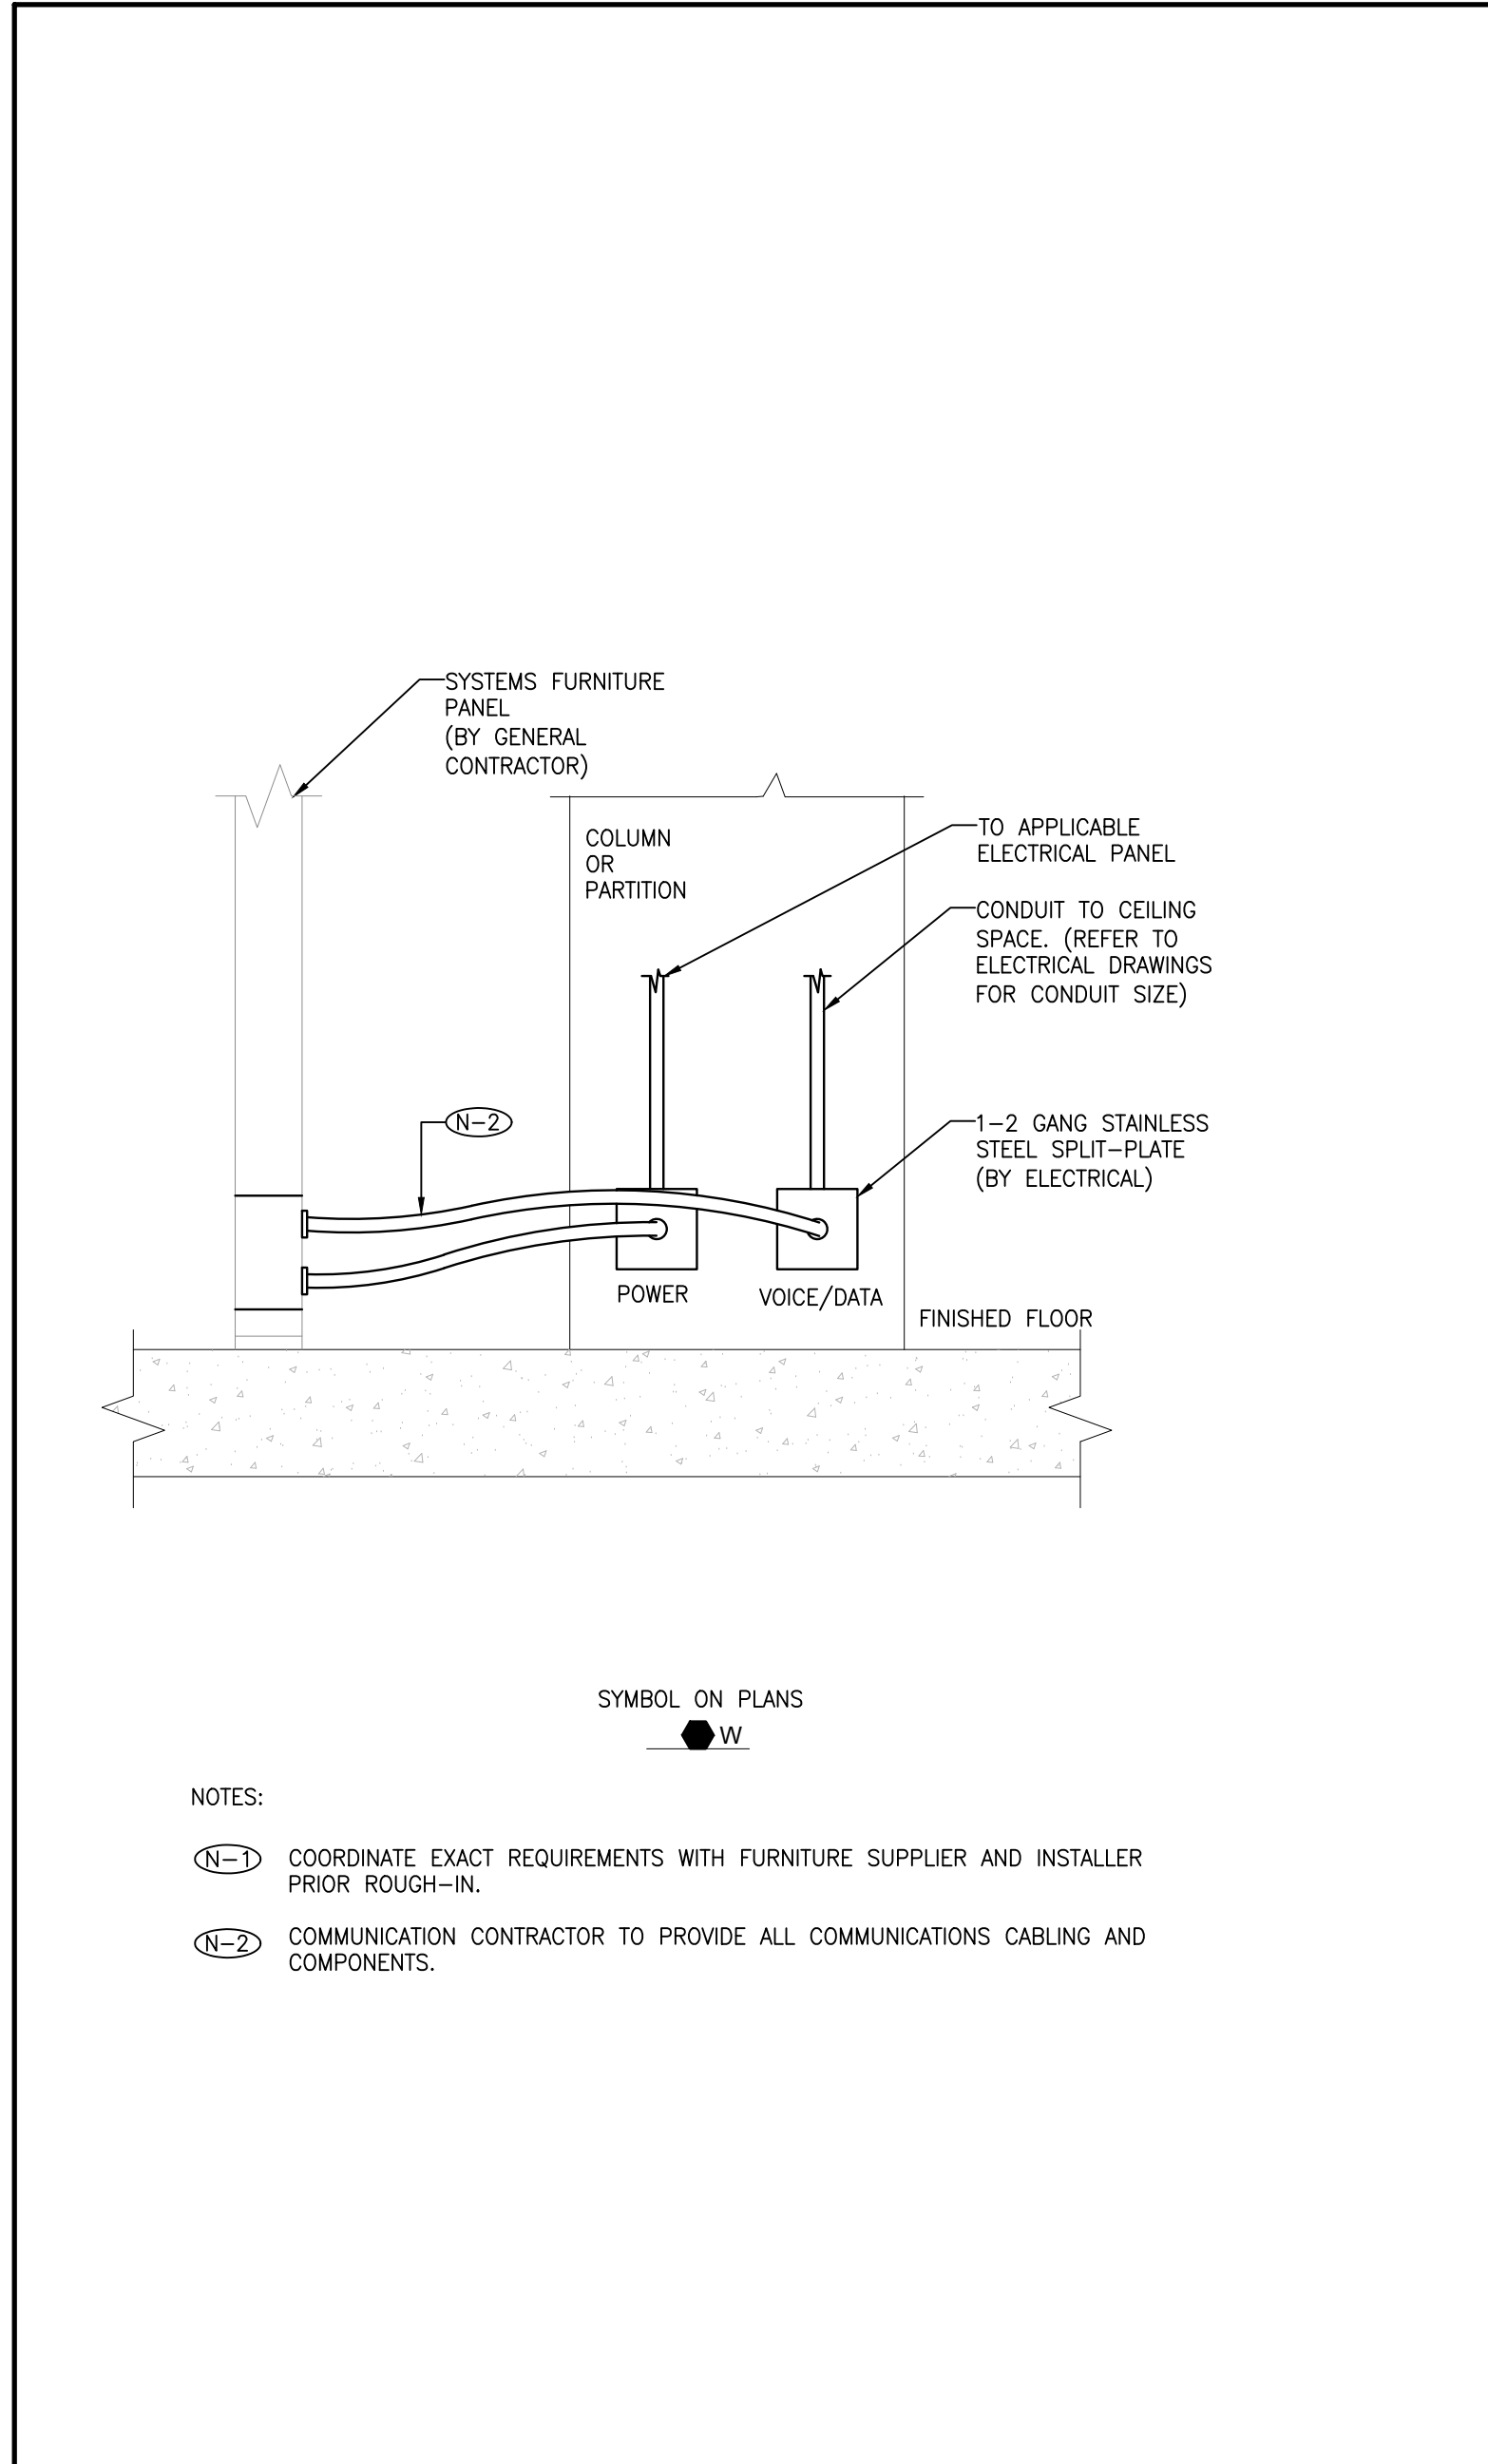

1 FURNITURE SYSTEM CONNECTION - WALL FEED
SCALE: N.T.S.

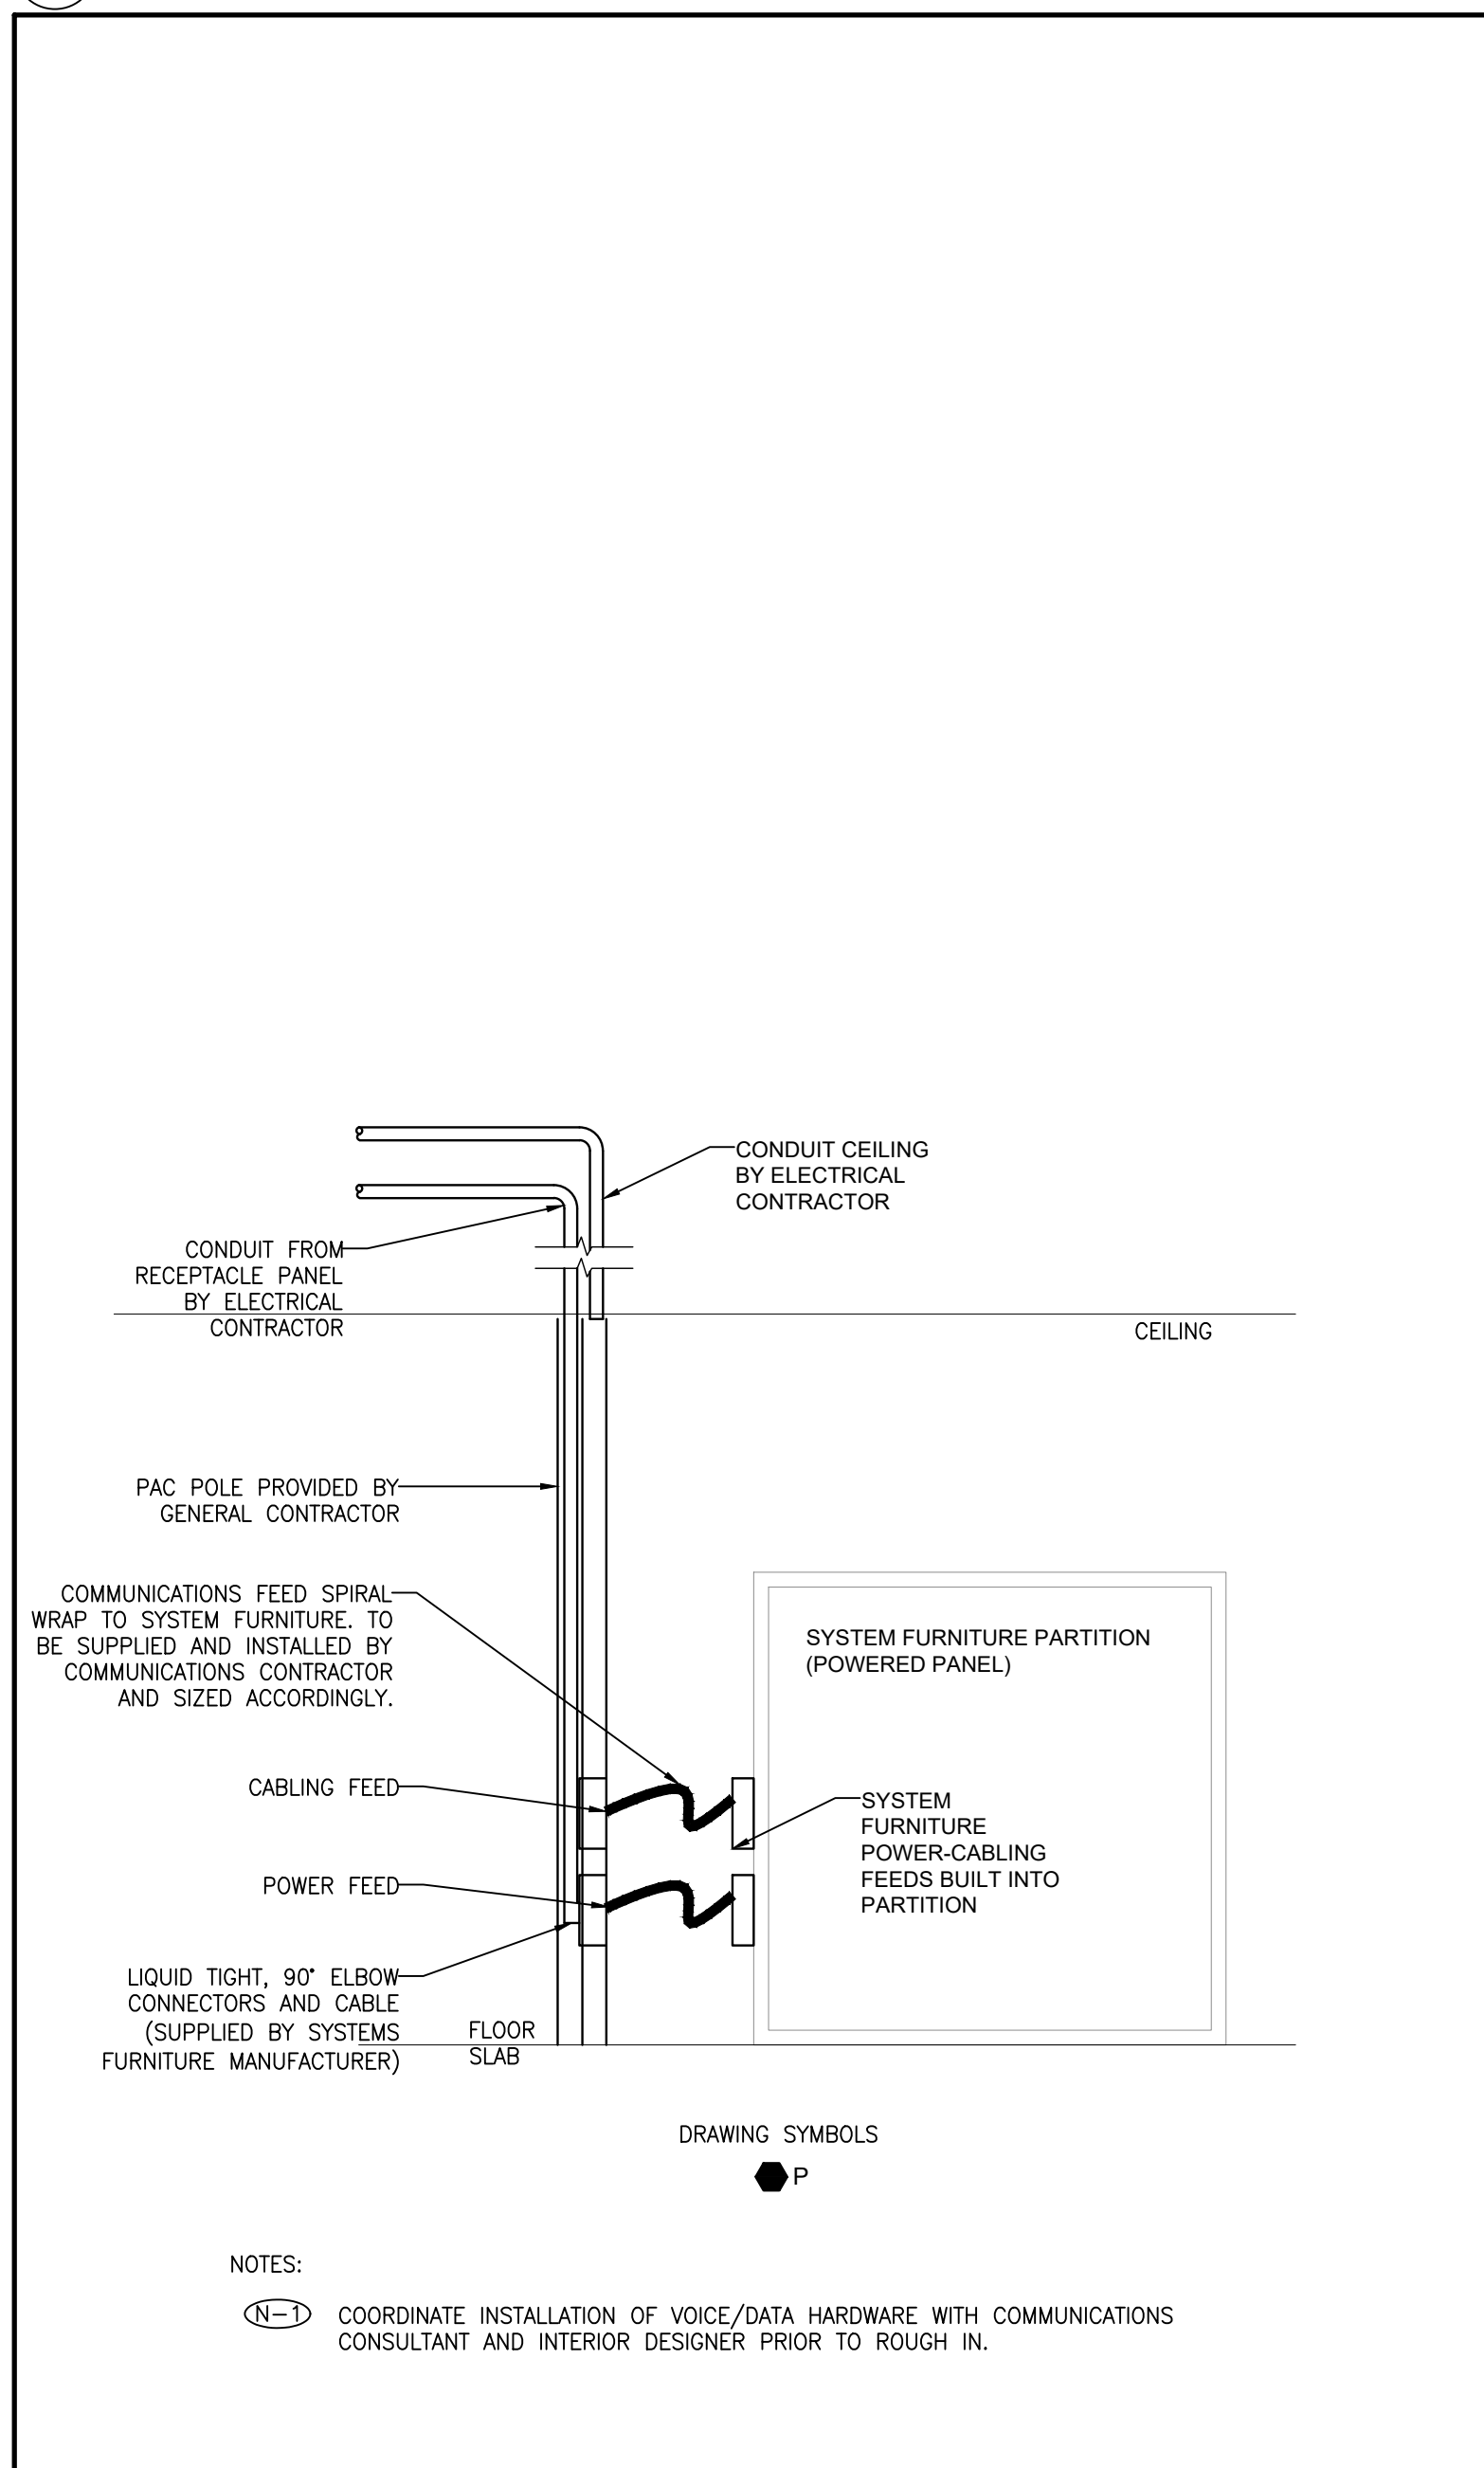

2 PAC POLE SYSTEM FURNITURE FEED
SCALE: N.T.S.

ATHENA

41 DOVERCOURT ROAD | SUITE 505 | TORONTO | M6J 0G6

416 525 6810
WWW.STUDIOATHENA.CA

02026 STUDIO ATHENA, INC. ALL DRAWINGS AND WRITTEN MATERIAL HEREIN CONSTITUTE THE ORIGINAL AND UNPUBLISHED WORK OF THE DESIGNER, AND THE SAME MAY NOT BE DUPLICATED, USED, OR DISCLOSED WITHOUT THE WRITTEN CONSENT OF THE DESIGNER.

NO.	ISSUE	DATE
01.	ISSUED FOR REVIEW	2026-05-26
02.	ISSUED FOR TENDER REVIEW	2026-06-12
03.	ISSUED FOR TENDER	2026-07-24

SYMBOL ON PLANS
● W

NOTES:

- (N-1) COORDINATE EXACT REQUIREMENTS WITH FURNITURE SUPPLIER AND INSTALLER PRIOR TO ROUGH-IN.
- (N-2) COMMUNICATION CONTRACTOR TO PROVIDE ALL COMMUNICATIONS CABLING AND COMPONENTS.

PROJECT CONTACT

NAME: JOSHUA BLIZZARD

TEL: 647 943 0261

EMAIL: joshua.blizzard@smithandandersen.com

THIS DRAWING SHALL BE READ IN CONJUNCTION WITH COMMUNICATIONS SPECIFICATION SUBMITTED FOR THIS PROJECT.

Smith + Andersen

1100 - 100 Sheppard Ave. East, Toronto On, M2N 6N5
416 487 8151 | 416 487 9104 smithandandersen.com

TORONTO EMERGENCY MANAGEMENT

703 DON MILLS ROAD, 02-03FL
TORONTO ON M3C 3N3

Drawing Title:

COMMUNICATIONS PATHWAY DETAILS

Drawn By: CV
Checked By: JB/TS
Scale: 1/8" = 1'-0"
Project number: 91002.010.MED.001
Drawing Number:

TC-0.2


- GENERAL NOTES
1. REFER TO THE ARCHITECT'S AND INTERIOR DESIGNER'S DRAWINGS TO DETERMINE COMPLETE EXTENT OF DEMOLITION AND ALLOW FOR ALL COSTS. COMPLETE EXTENT OF DEMOLITION IS NOT SHOWN.
 2. REMOVE ALL NOTED FLOOR, COLUMN, CEILING, AND WALL MOUNTED TELEPHONE DATA OUTLETS, CABLE BACK TO SOURCE TO SUIT NEW LAYOUT AND MAKE SAFE. VISIT SITE TO DETERMINE EXACT REQUIREMENTS AND REFER TO DEMOLITION DRAWINGS.
 3. MAKE GOOD ALL CORE HOLES FROM CABLEING, EQUIPMENT, AND DEVICES DISCONNECTED, RELOCATED AND OR REMOVED IN THIS PROJECT.
 4. NO ADDITIONAL COST WILL BE APPROVED FOR ANY REVISIONS/MODIFICATIONS REQUIRED BY ANY TRADE OR CONTRACTOR DUE TO THE LACK OF COORDINATION BETWEEN TRADES AND CONTRACTORS.
 5. COORDINATE WITH GENERAL CONTRACTOR AND LANDLORD FOR DISPOSAL OF ALL MATERIALS FROM SITE.

ATHENA

41 DOVERCOURT ROAD | SUITE 505 | TORONTO | M6J 0G6
416 525 6810
WWW.STUDIOATHENA.CA

©2026 STUDIOATHENA, INC.
ALL DRAWINGS AND WRITTEN MATERIAL HEREIN CONSTITUTE THE ORIGINAL AND UNPUBLISHED WORK OF THE DESIGNER, AND THE SAME MAY NOT BE DUPLICATED, USED, OR DISCLOSED WITHOUT THE WRITTEN CONSENT OF THE DESIGNER.

NO.	ISSUE	DATE
01.	ISSUED FOR REVIEW	2026-05-26
02.	ISSUED FOR TENDER REVIEW	2026-06-12
03.	ISSUED FOR TENDER	2026-07-24

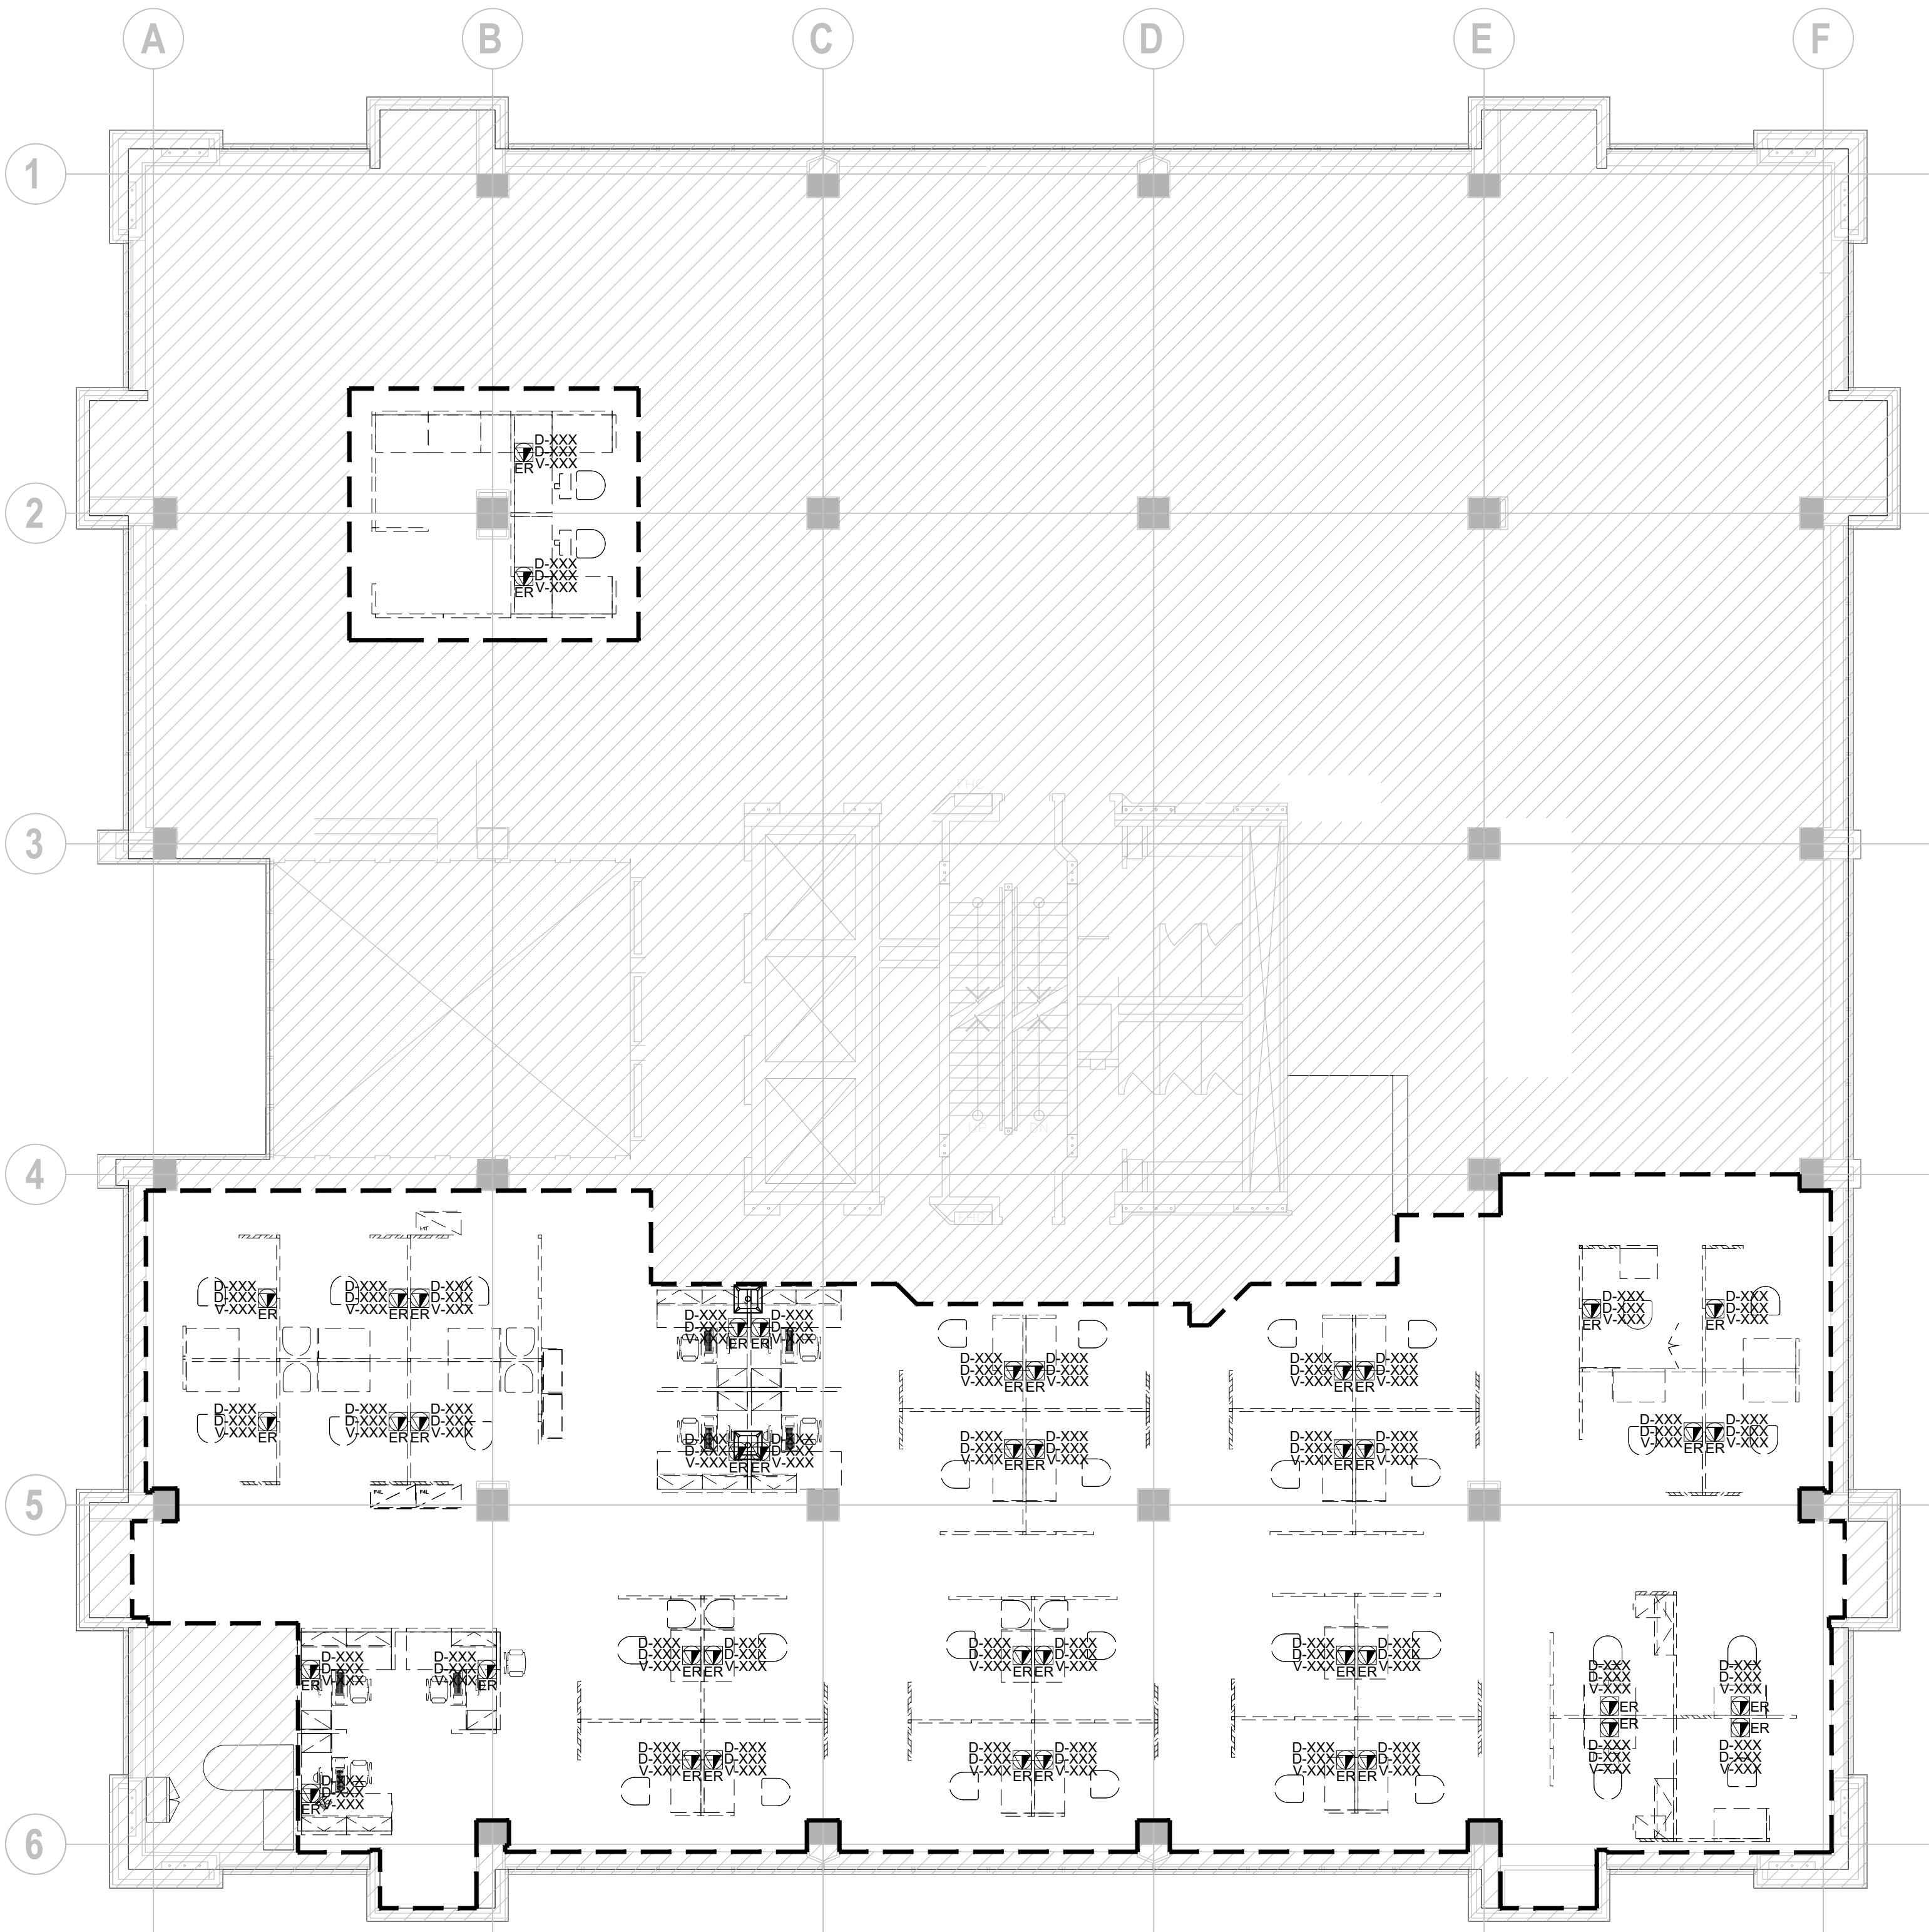

PROJECT CONTACT

NAME: JOSHUA BLIZZARD
TEL: 647 943 0261
EMAIL: joshua.blizzard@smithandandersen.com

THIS DRAWING SHALL BE READ IN CONJUNCTION WITH COMMUNICATIONS SPECIFICATION SUBMITTED FOR THIS PROJECT.



Smith + Andersen

1100 — 100 Sheppard Ave. East, Toronto On, M2N 6N5
416 487 8151 | 416 487 9104 smithandandersen.com

TORONTO EMERGENCY
MANAGEMENT

703 DON MILLS ROAD, 02-03FL
TORONTO ON M3C 3N3

Drawing Title:

2ND FLOOR COMMUNICATIONS
DEMOLITION LAYOUT

Drawn By: CV
Checked By: JBT/S
Scale: 1/8" = 1'-0"
Project number: 91002.010.MED.001
Drawing Number:


TC-2.0

ATHENA

41 DOVERCOURT ROAD | SUITE 505 | TORONTO | M6J 0G6
416 525 6810
WWW.STUDIOATHENA.CA

©2026 STUDIO ATHENA, INC.
ALL DRAWINGS AND WRITTEN MATERIAL HEREIN CONSTITUTE THE ORIGINAL AND UNPUBLISHED WORK OF THE DESIGNER, AND THE SAME MAY NOT BE DUPLICATED, USED, OR DISCLOSED WITHOUT THE WRITTEN CONSENT OF THE DESIGNER.

NO.	ISSUE	DATE
01.	ISSUED FOR REVIEW	2026-05-26
02.	ISSUED FOR TENDER REVIEW	2026-06-12
03.	ISSUED FOR TENDER	2026-07-24

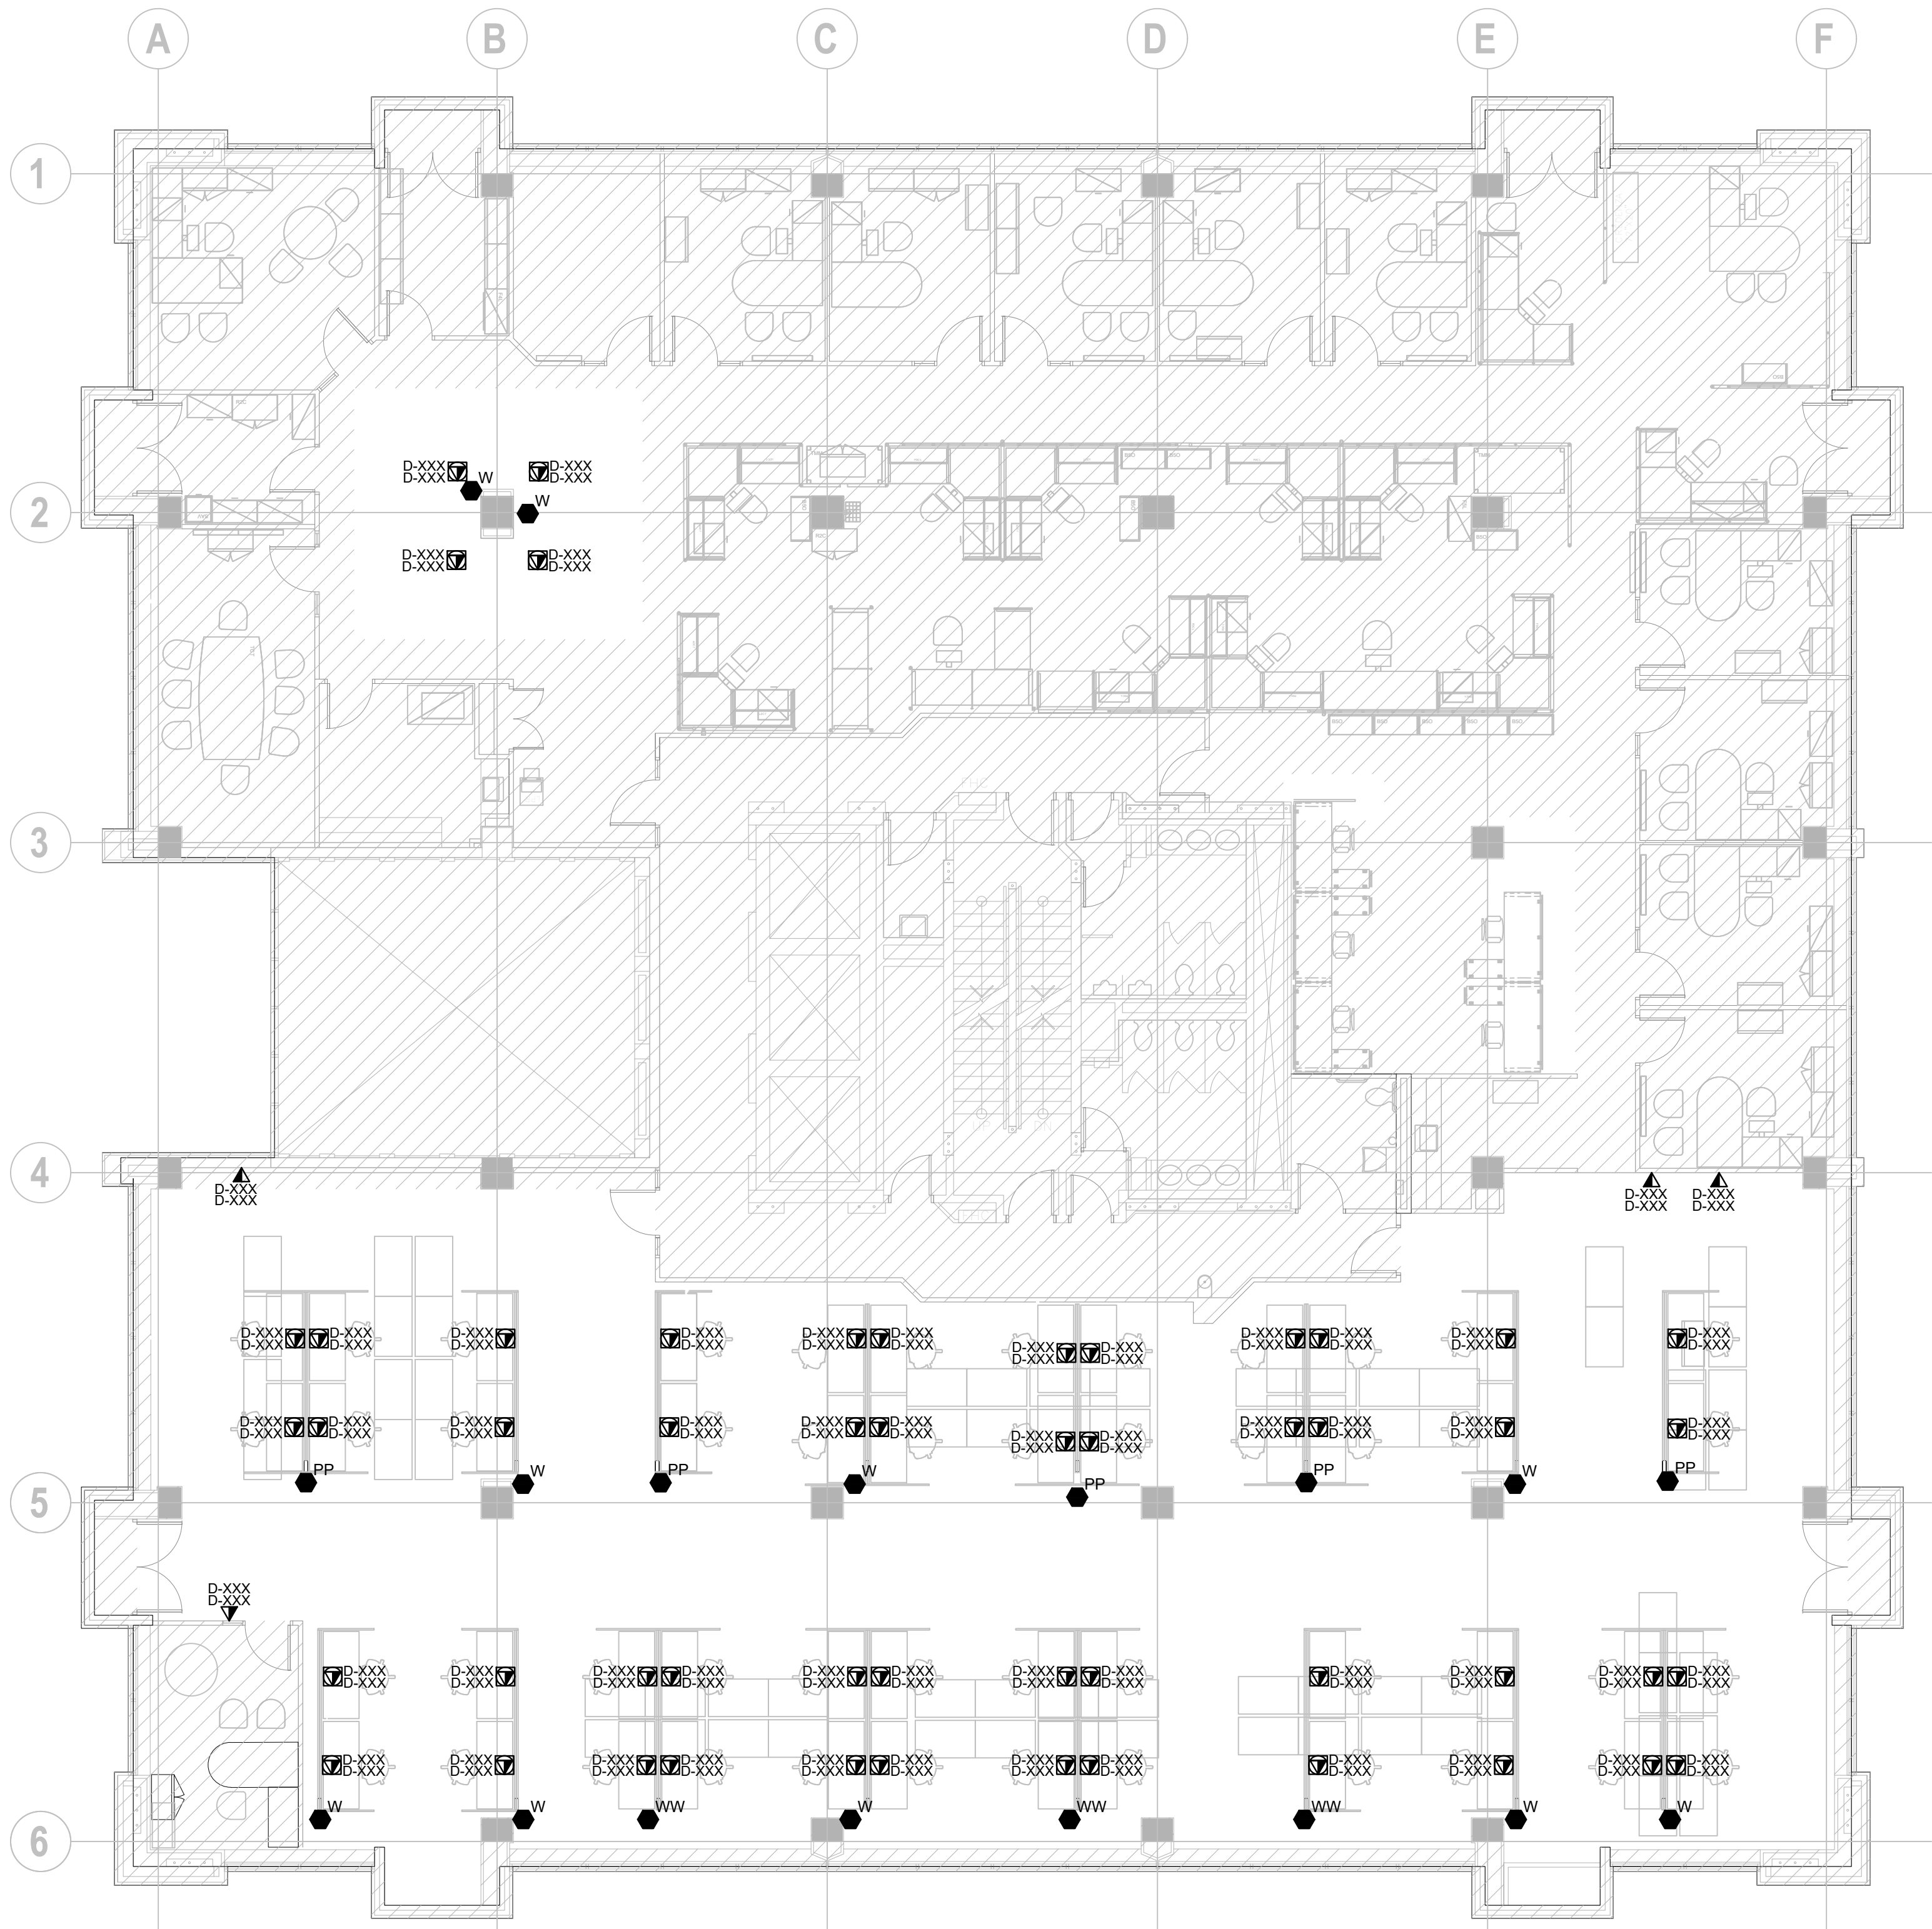

PROJECT CONTACT

NAME: JOSHUA BLIZZARD
TEL: 647 943 0261
EMAIL: joshua.blizzard@smithandandersen.com

THIS DRAWING SHALL BE READ IN CONJUNCTION WITH COMMUNICATIONS SPECIFICATION SUBMITTED FOR THIS PROJECT.



Smith + Andersen

1100 — 100 Sheppard Ave. East, Toronto On, M2N 6N5
416 487 8151 f 416 487 9104 smithandandersen.com

TORONTO EMERGENCY MANAGEMENT

703 DON MILLS ROAD, 02-03FL
TORONTO ON M3C 3N3


Drawing Title:

2ND FLOOR COMMUNICATIONS LAYOUT

Drawn By: CV
Checked By: JB/TJS
Scale: 1/8" = 1'-0"
Project number: 91002.010.MED.001
Drawing Number:

TC-2.1

- GENERAL NOTES
- REFER TO THE ARCHITECTS AND INTERIOR DESIGNER'S DRAWINGS TO DETERMINE COMPLETE EXTENT OF DEMOLITION AND ALLOW FOR ALL COSTS. COMPLETE EXTENT OF DEMOLITION IS NOT SHOWN.
 - REMOVE ALL NOTED FLOOR, COLUMN, CEILING, AND WALL MOUNTED TELEPHONE DATA OUTLETS, CABLING BACK TO SOURCE TO SUIT NEW LAYOUT AND MAKE SAFE. VISIT SITE TO DETERMINE EXACT REQUIREMENTS AND REFER TO DEMOLITION DRAWINGS.
 - MAKE GOOD ALL CORE HOLES FROM CABLING, EQUIPMENT, AND DEVICES DISCONNECTED, RELOCATED AND OR REMOVED IN THIS PROJECT.
 - NO ADDITIONAL COST WILL BE APPROVED FOR ANY REVISIONS/MODIFICATIONS REQUIRED BY ANY TRADE OR CONTRACTOR DUE TO THE LACK OF COORDINATION BETWEEN TRADES AND CONTRACTORS.
 - COORDINATE WITH GENERAL CONTRACTOR AND LANDLORD FOR DISPOSAL OF ALL MATERIALS FROM SITE.

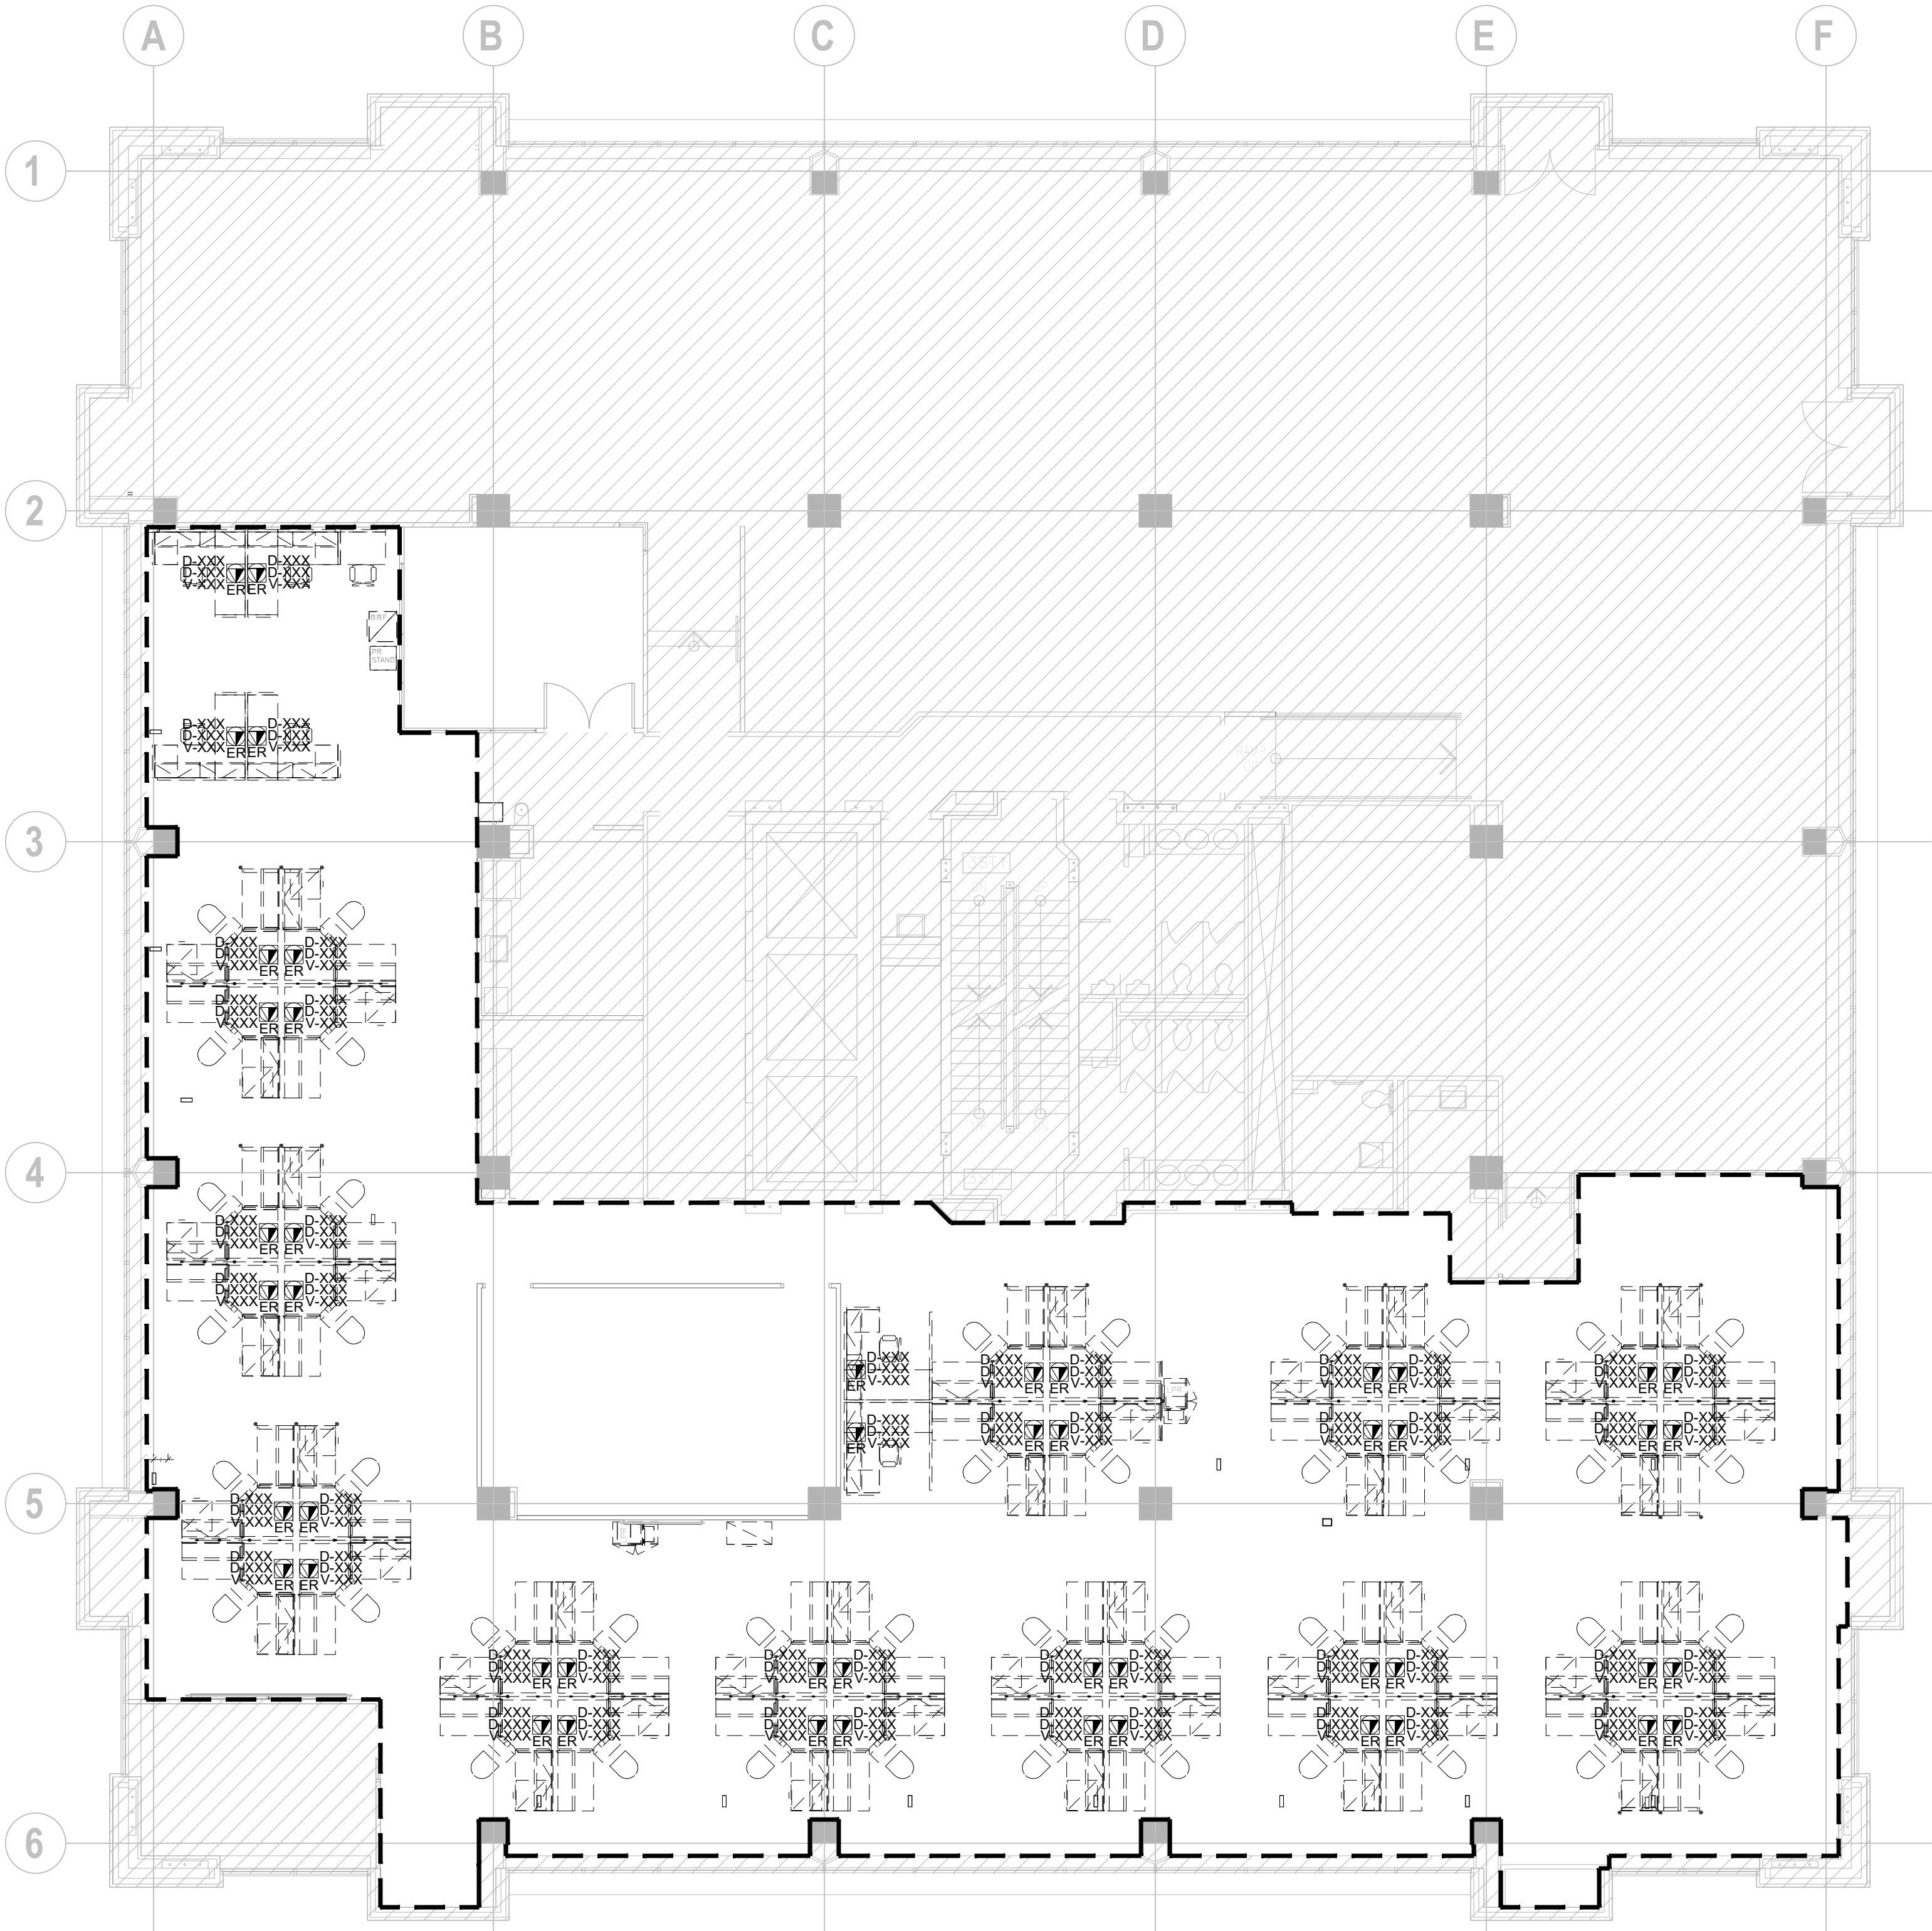

ATHENA

41 DOVERCOURT ROAD | SUITE 505 | TORONTO | M6J 0G6
416 525 6810
WWW.STUDIOATHENA.CA

©2026 STUDIOATHENA, INC.
ALL DRAWINGS AND WRITTEN MATERIAL HEREIN CONSTITUTE THE ORIGINAL AND UNPUBLISHED WORK OF THE DESIGNER, AND THE SAME MAY NOT BE DUPLICATED, USED, OR DISCLOSED WITHOUT THE WRITTEN CONSENT OF THE DESIGNER.

NO.	ISSUE	DATE
01.	ISSUED FOR REVIEW	2026-05-26
02.	ISSUED FOR TENDER REVIEW	2026-06-12
03.	ISSUED FOR TENDER	2026-07-24

PROJECT CONTACT

NAME: JOSHUA BLIZZARD
TEL: 647 943 0261
EMAIL: joshua.blizzard@smithandandersen.com

THIS DRAWING SHALL BE READ IN CONJUNCTION WITH COMMUNICATIONS SPECIFICATION SUBMITTED FOR THIS PROJECT.



Smith + Andersen

1100 — 100 Sheppard Ave. East, Toronto On, M2N 6N5
416 487 8151 | 416 487 9104 smithandandersen.com

TORONTO EMERGENCY
MANAGEMENT

703 DON MILLS ROAD, 02-03FL
TORONTO ON M3C 3N3

Drawing Title:

3RD FLOOR COMMUNICATIONS
DEMOLITION LAYOUT

Drawn By: CV
Checked By: JB/TJS
Scale: 1/8" = 1'-0"
Project number: 91002.010.MED.001
Drawing Number:

TC-3.0


DRAWING NOTES:
CABLES TAGGED WITH "NOC-" PREFIX TERMINATE IN THE STAGING ROOM INSTEAD OF THE TELECOM ROOM

ATHENA

41 DOVERCOURT ROAD | SUITE 505 | TORONTO | M6J 0G6
416 525 6810
WWW.STUDIOATHENA.CA

©2026 STUDIO ATHENA, INC.
ALL DRAWINGS AND WRITTEN MATERIAL HEREIN CONSTITUTE THE ORIGINAL AND UNPUBLISHED WORK OF THE DESIGNER, AND THE SAME MAY NOT BE DUPLICATED, USED, OR DISCLOSED WITHOUT THE WRITTEN CONSENT OF THE DESIGNER.

NO.	ISSUE	DATE
01.	ISSUED FOR REVIEW	2026-05-26
02.	ISSUED FOR TENDER REVIEW	2026-06-12
03.	ISSUED FOR TENDER	2026-07-24

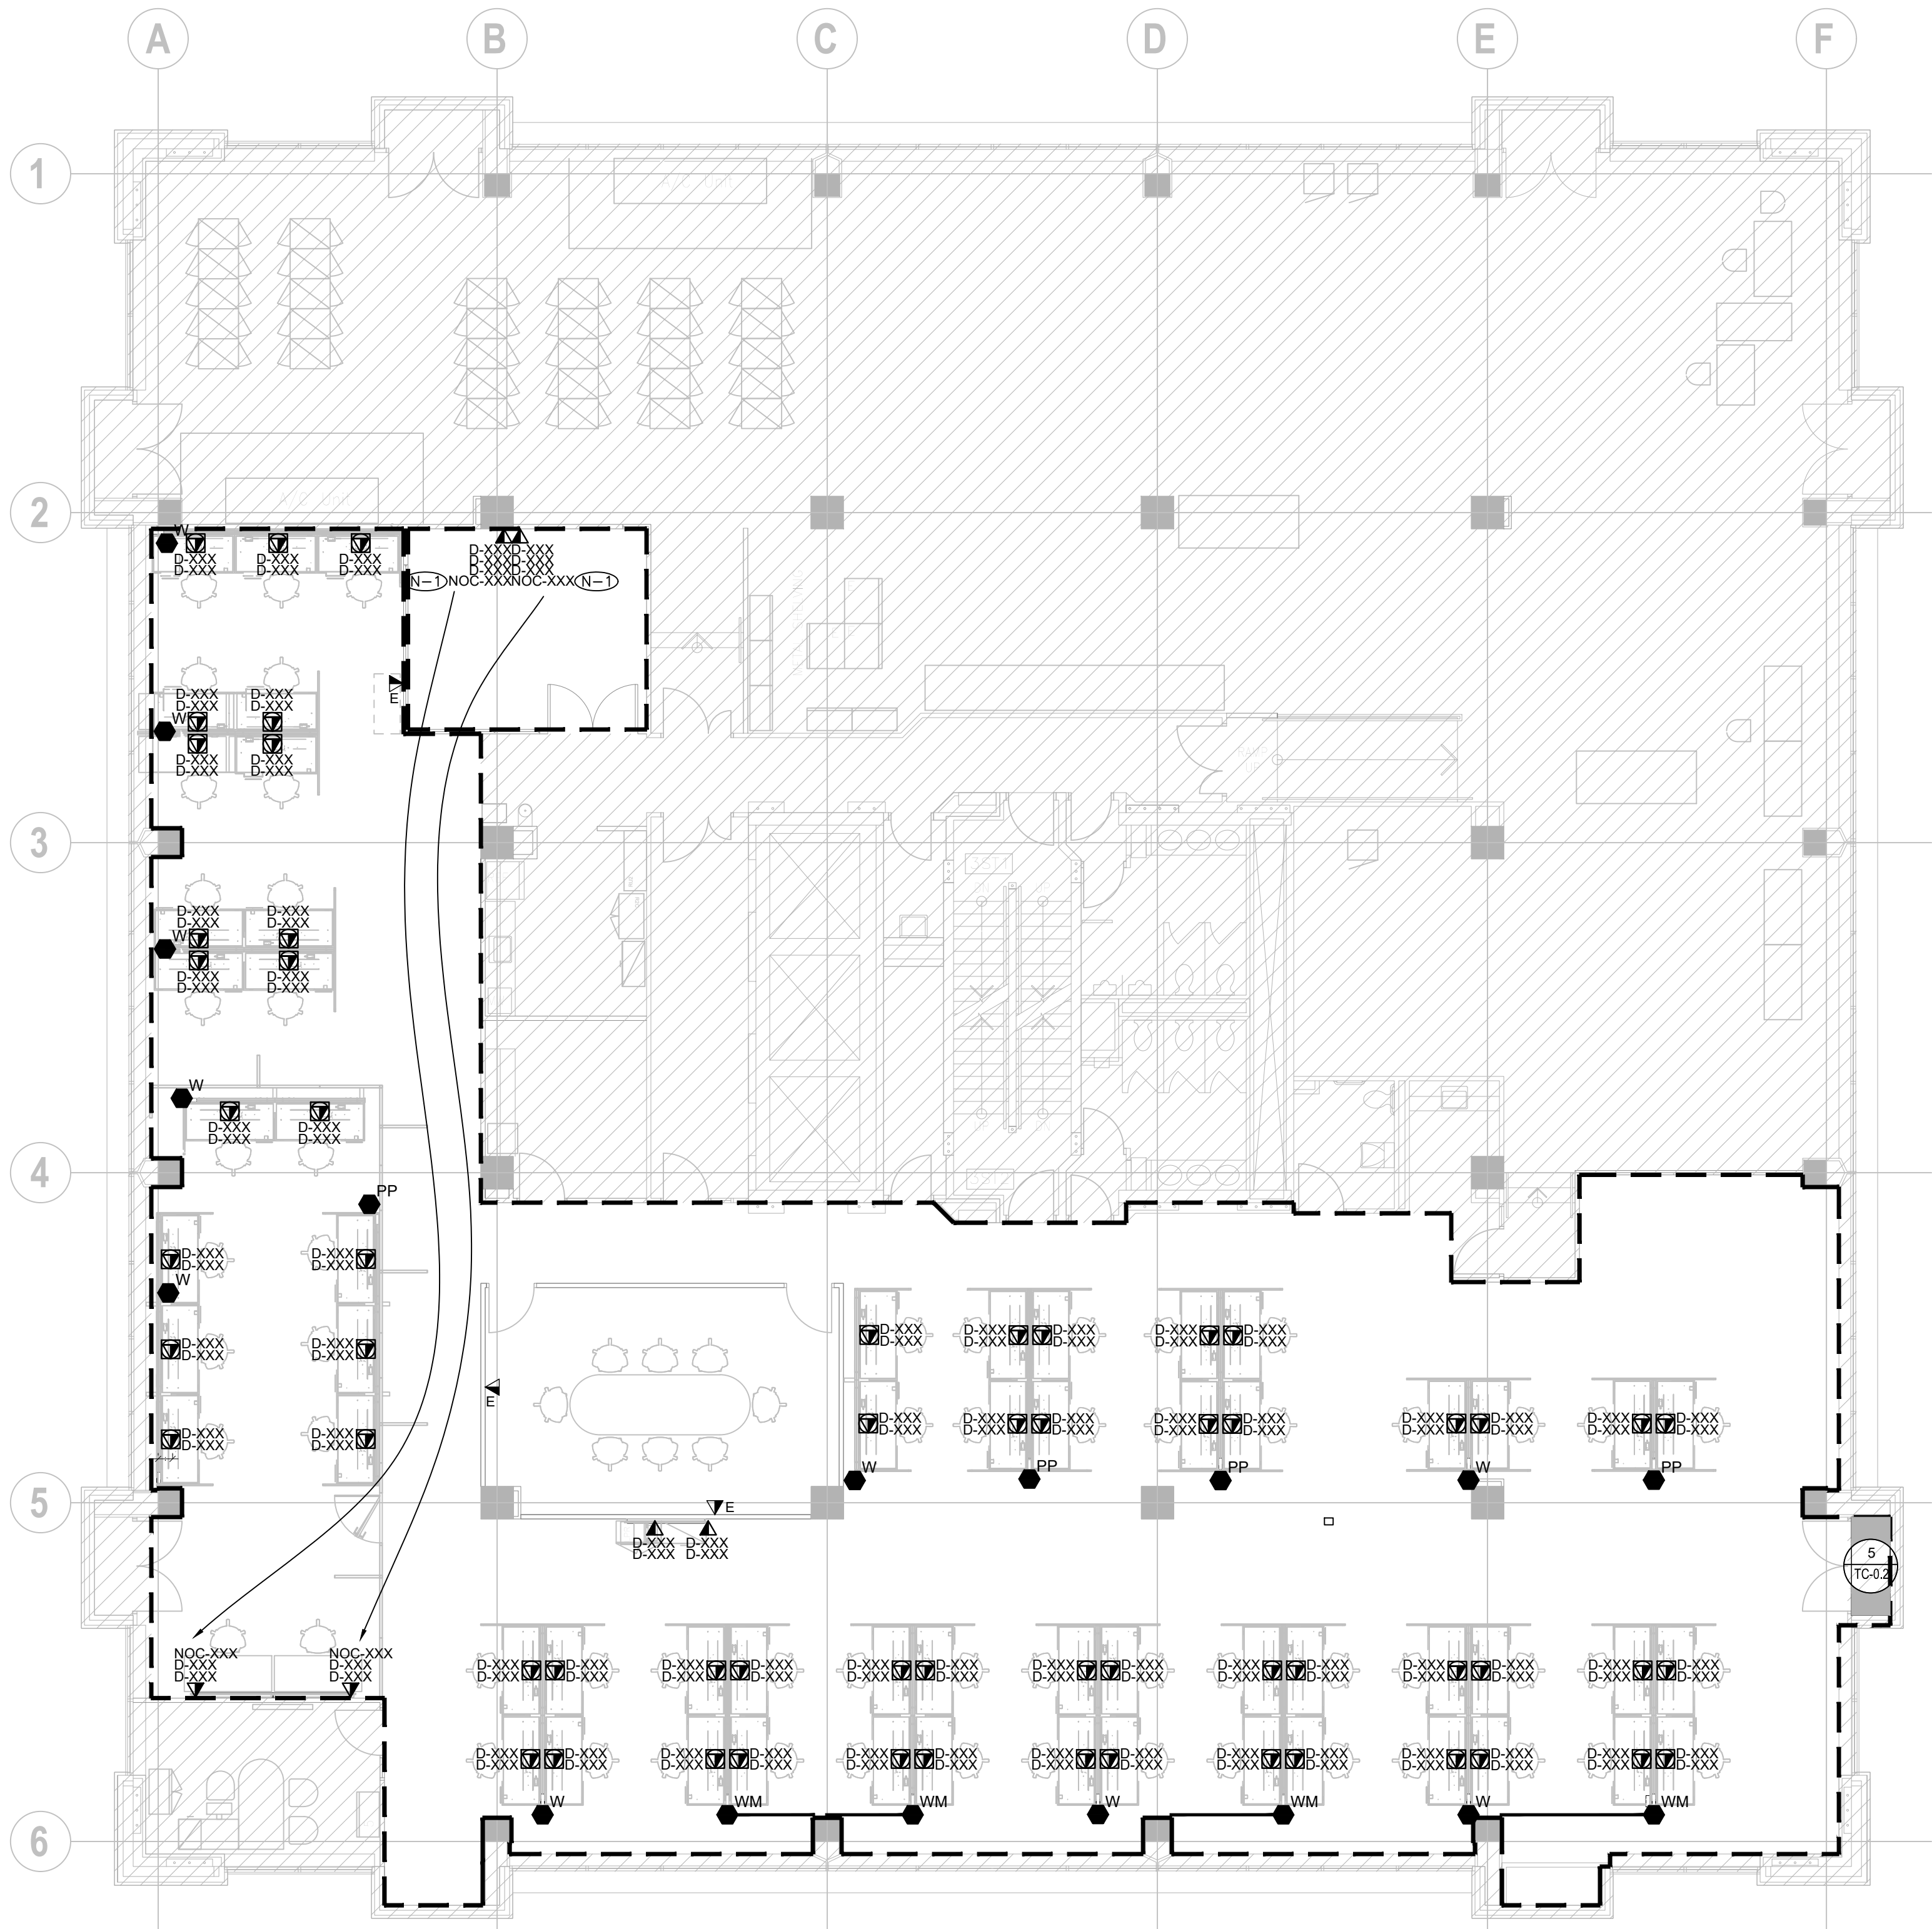

PROJECT CONTACT

NAME: JOSHUA BLIZZARD
TEL: 647 943 0261
EMAIL: joshua.blizzard@smithandandersen.com

THIS DRAWING SHALL BE READ IN CONJUNCTION WITH COMMUNICATIONS SPECIFICATION SUBMITTED FOR THIS PROJECT.



Smith + Andersen

1100 — 100 Sheppard Ave. East, Toronto On, M2N 6N5
416 487 8151 f 416 487 9104 smithandandersen.com

TORONTO EMERGENCY MANAGEMENT

703 DON MILLS ROAD, 02-03FL
TORONTO ON M3C 3N3

Drawing Title:

3RD FLOOR COMMUNICATIONS LAYOUT

Drawn By: CV
Checked By: JBT/S
Scale: 1/8" = 1'-0"
Project number: 91002.010.MED.001
Drawing Number:

TC-3.1